
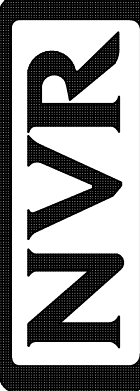


1 PLUMBING PLAN
A-5 SCALE: 1/4" = 1'-0"

SHEET NO. A-5	MODEL LONDON	SET NO. LDN00	REV. NO. DATE	REMARKS
	DRAWING TITLE PLUMBING PLAN	VERSION 02		
OPTION DESCRIPTION 33	DRAWN BY PTH	DATE: 8/13/15		<p>NVR, Inc., owner, expressly reserves its copyright in these plans. These plans are not to be reproduced, changed, copied, or otherwise used in any way without the written consent of NVR, Inc.</p>
		OPTION		
 <p>NVR, Inc. Architectural Services 5285 Westheimer, Suite 100 Frederick, MD 21703</p>				
<p>C:\NVR\Solves\LONDON_LDNO0_02\DCV-B1-0019\620008\SheetA.Lot_Specific\A-5_A-5_PLMG_LS.dwg 12/17/17 - 3:03 pm</p>				

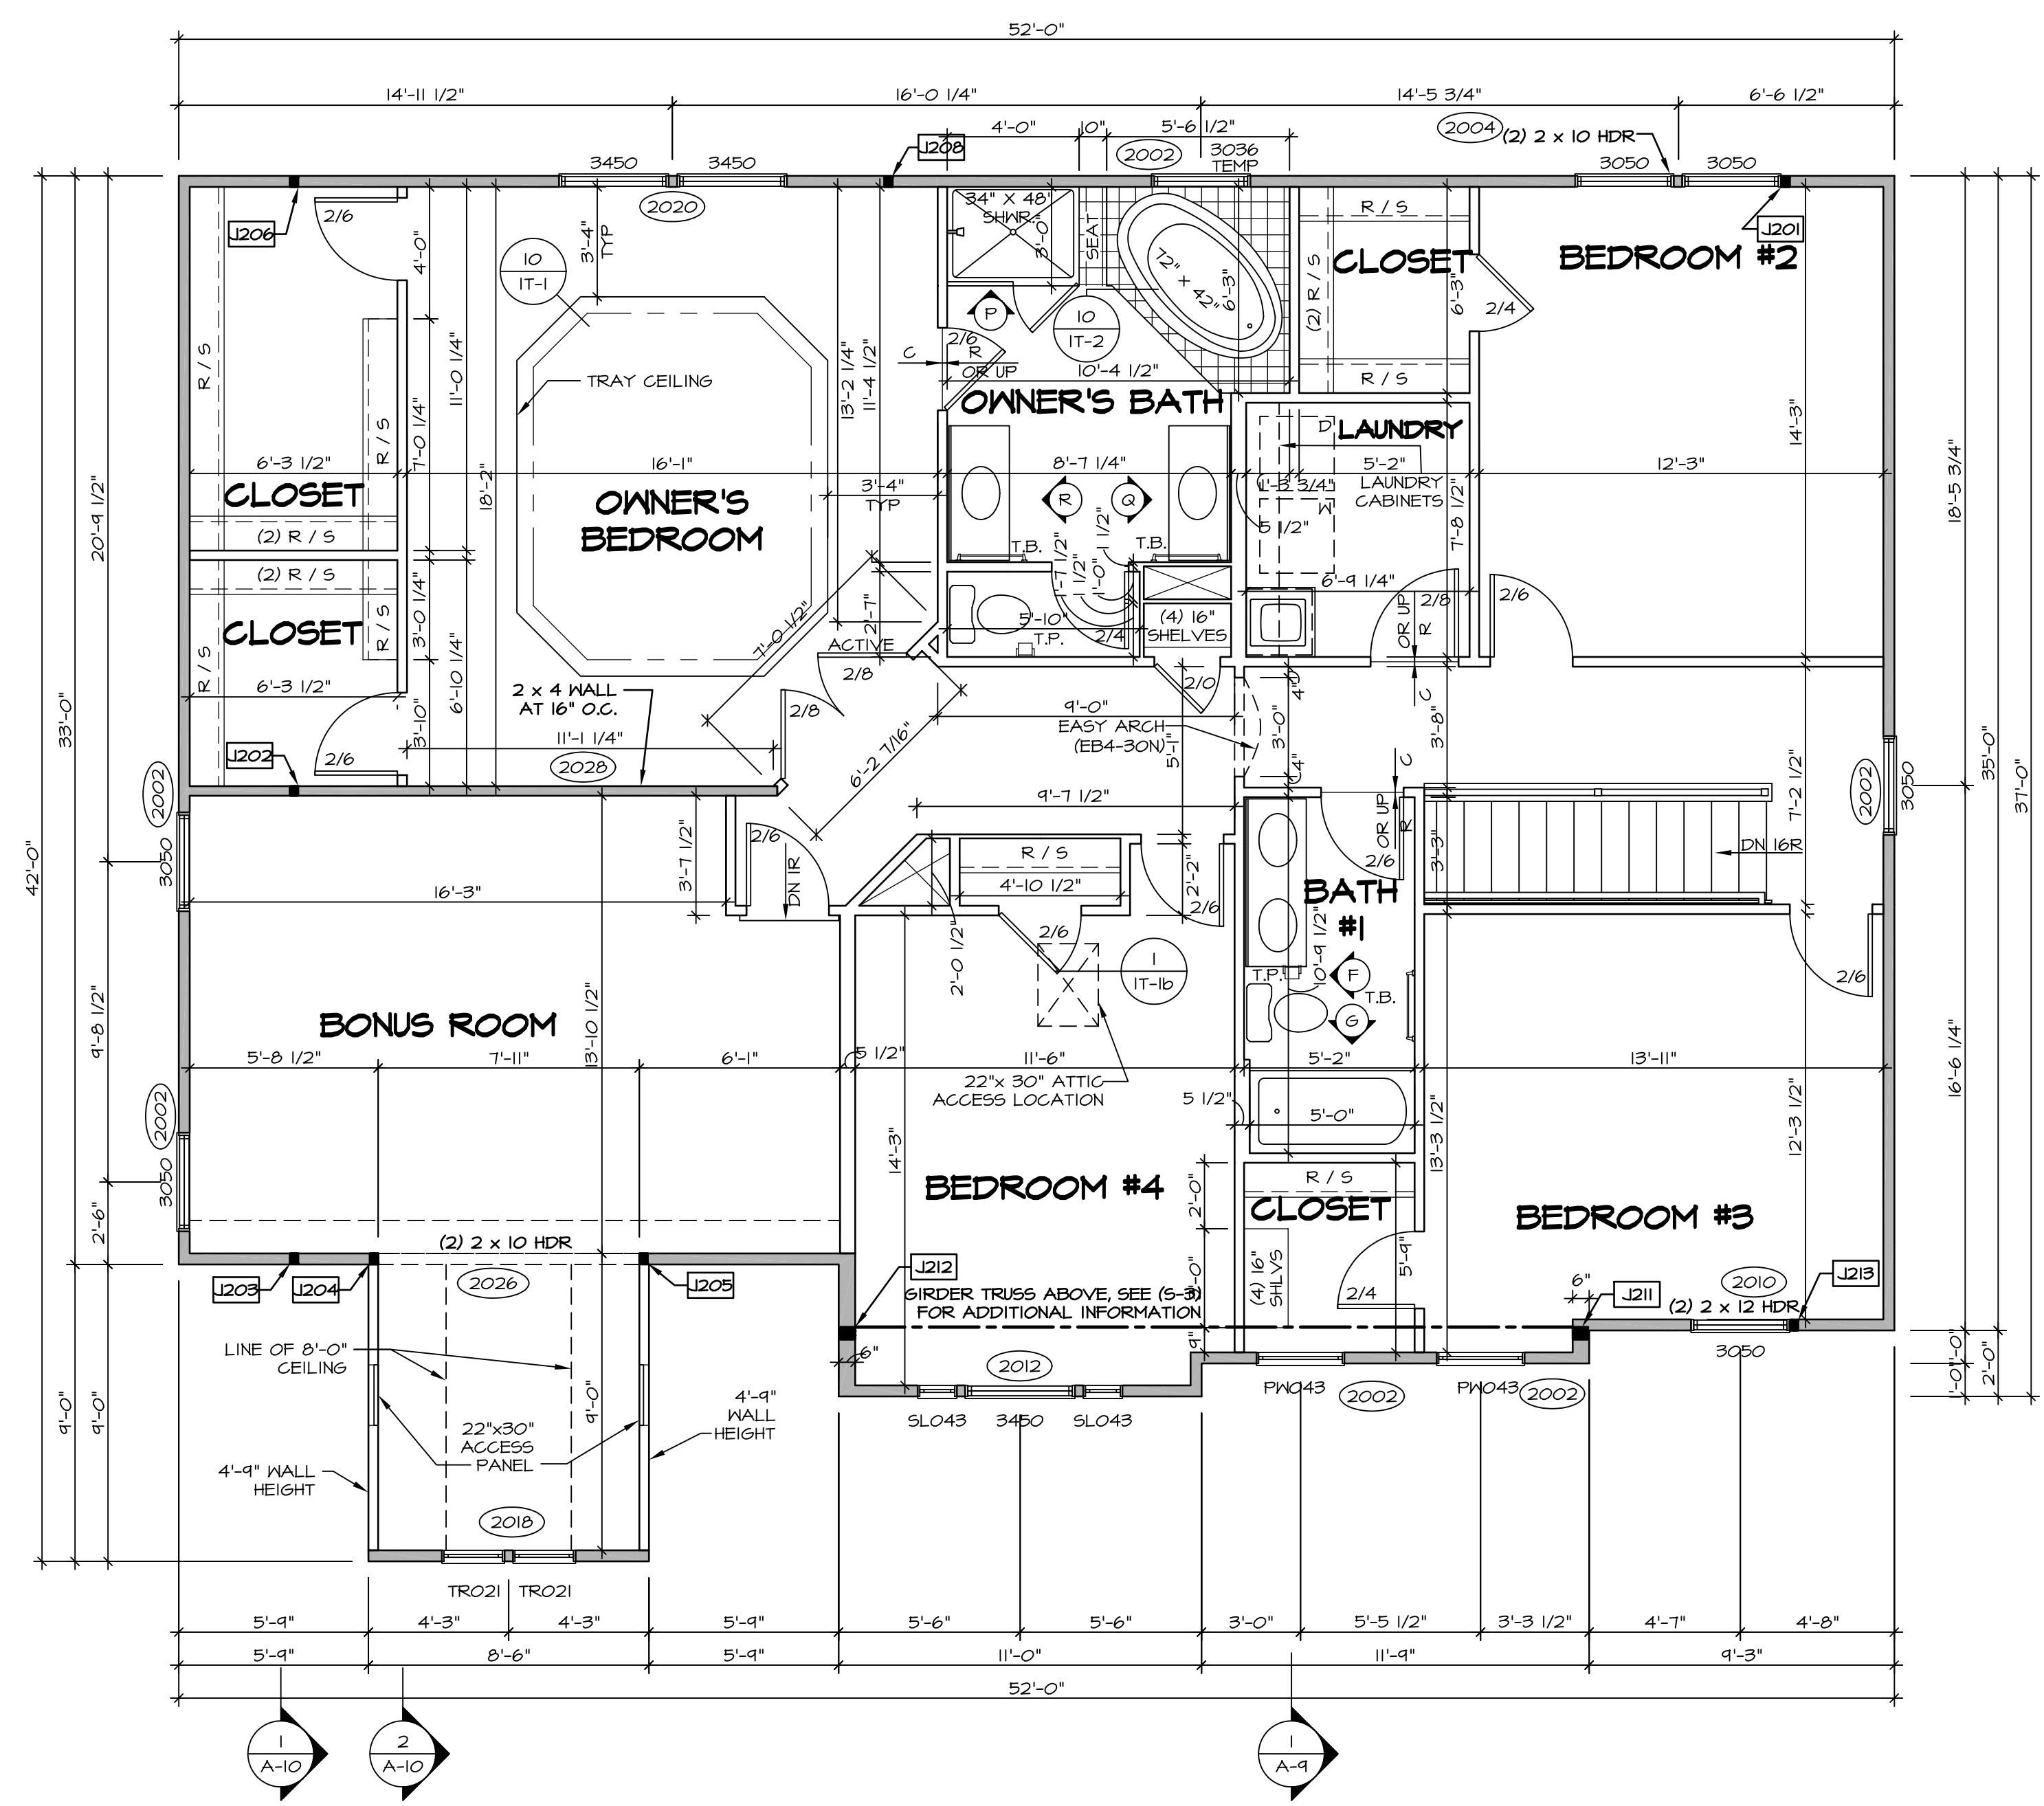

LEGEND

- BEARING WALL
- NON BEARING WALL
- INDICATES BEARING FROM POINT-LOAD ABOVE
- JACKS
- BEAM/HEADER
- PAD FOOTING
- STEEL COLUMN
- PORTAL FRAME
- JOIST/TRUSS
- LVL
- ENGINEERING PAGE NUMBER

SEE FC DETAILS FOR FRAMING CONNECTORS

- FLOOR PLAN NOTES**
1. ALL HEADERS ARE (2) 2x6 w/ 2x4 WALLS OR (3) 2x6 w/ 2x6 WALLS, UNLESS OTHERWISE NOTED.
 2. ALL HEADERS TO HAVE (1) 2x4 OR 2x6 JACK EACH END, UNLESS OTHERWISE NOTED.
 3. ALL EXTERIOR WALLS TO BE 4" AND ALL INTERIOR WALLS TO BE 3 1/2", UNLESS OTHERWISE NOTED.
 4. HATCHED AREAS INDICATE DROPPED CEILINGS. ALL DROPPED CEILINGS ARE 12" UNLESS OTHERWISE NOTED.
 5. SEE "BRACED WALL PANEL DETAIL SHEET" FOR SPECIAL WALL FRAMING LOCATIONS AND HEADER SIZES, IF APPLICABLE.
 6. SEE STANDARD DETAIL CATEGORY "IT" SHEET(S) FOR INTERIOR TRIM DETAILS.
 7. SEE ARCHITECTURAL DETAIL SHEET "AD" FOR HOUSE SPECIFIC INTERIOR TRIM OPTION TABLE.
 8. ALL WINDOWS HAVE 7'-0 1/2" HEADER HEIGHT UNLESS OTHERWISE NOTED.

- GYPSUM NOTES**
- AT GARAGE:
GYPSUM BOARD AT COMMON WALLS, CEILINGS, BEAM WRAPS AND SUPPORTS PER STANDARD DETAIL FA-100 FIRE ASSEMBLIES OR AS REQUIRED BY LOCAL CODE.
- AT STAIRS:
1/2" GYPSUM BOARD AT UNDERSIDE OF STAIRS AND WALLS IN CLOSET

SECOND FLOOR JACK SCHEDULE

IDENTIFIER	DESCRIPTION	OPTIONS	ENG. NUM.	REMARKS
J201	JACK - (2) 2X4 SFF STUD GRADE	ELC, ELL	2001a	
J202	JACK - (2) 2X4 SFF STUD GRADE	ELC, ELL, MAV	2001	
J203	JACK - (2) 2X4 SFF STUD GRADE	ELC, ELL, MAV	2001	
J204	JACK - (2) 2X4 SFF STUD GRADE	MAV		
J205	JACK - (2) 2X4 SFF STUD GRADE	MAV		
J206	JACK - (2) 2X4 SFF STUD GRADE	ELC, ELL, MAV	2001	
J208	JACK - (2) 2X4 SFF STUD GRADE	ELC, ELL, MAA	2000	
J211	JACK - (3) 2X6 SFF STUD GRADE	ELC	2000	EXTEND TO THRU. TOP PLATE
J212	JACK - (3) 2X6 SFF STUD GRADE	ELC	2000	EXTEND TO THRU. TOP PLATE
J213	JACK - (2) 2X4 SFF STUD GRADE	ELC	2010	


SECOND FLOOR PLAN
SCALE: 1/4" = 1'-0"

NVR, Inc., owner, expressly reserves its copyright in these plans. These plans are not to be reproduced, changed, copied, or otherwise used without the written consent of NVR, Inc.

NVR
Architectural Services
5285 Washington Blvd
Frederick, MD 21703

MODEL	LNDNOO	DRAWING TITLE	SECOND FLOOR PLAN	SHEET NO.	A-9	DATE	7/3/15	OPTION	41
VERSION	02	DRAWN BY	SDTT	SET NO.	LNDNOO	DATE	7/3/15	OPTION	


C:\NVR\Solves\LNDNOO_02\DCI-B1-0019\62000A\Sheet\Lot_Specific\41_A-9_PLN2_LS.dwg 12/17/17 - 3:03 pm

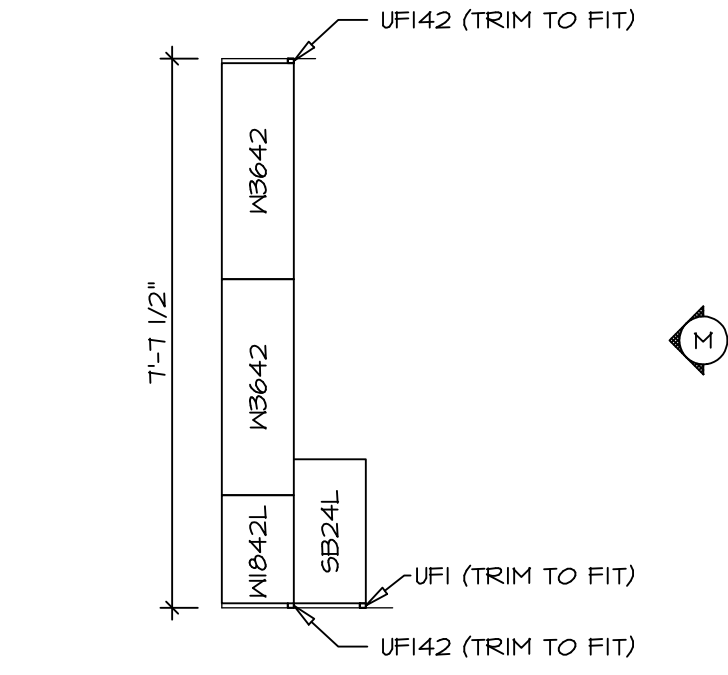

CABINET PLAN
KC - 2964

SCALE: 3/8" = 1'-0"


1
A-12b

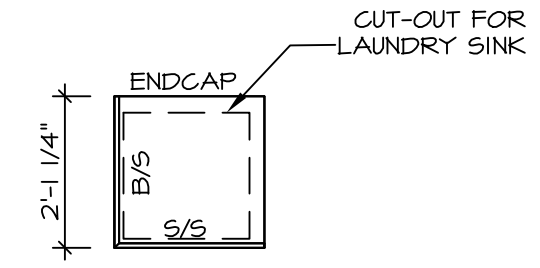

COUNTERTOP PLAN
KC - 2964

SCALE: 3/8" = 1'-0"

2
A-12b

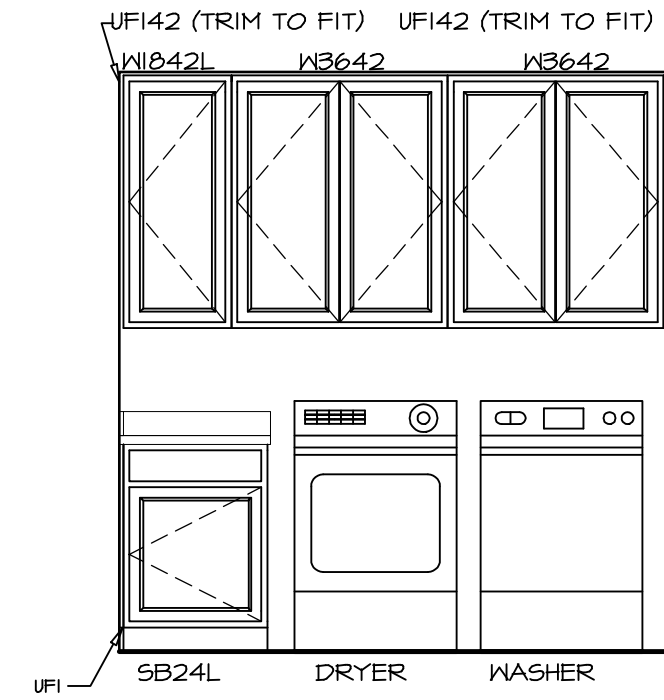

ELEVATION "M"









SCALE: 3/8" = 1'-0"

M

SHEET NO.	MODEL	SET NO.	VERSION	DRAWN BY	DATE	OPTION	REVISIONS	REMARKS
A-12b	LONDON	LDN00	02	SDTT	8/6/15			
52								


NVR
Architectural Services
5285 Washburne Circle
Frederick, MD 21703

NVR, Inc., owner, expressly reserves its copyright in these plans. These plans are not to be reproduced, changed, adapted, or used in any way without the prior written consent of NVR, Inc.

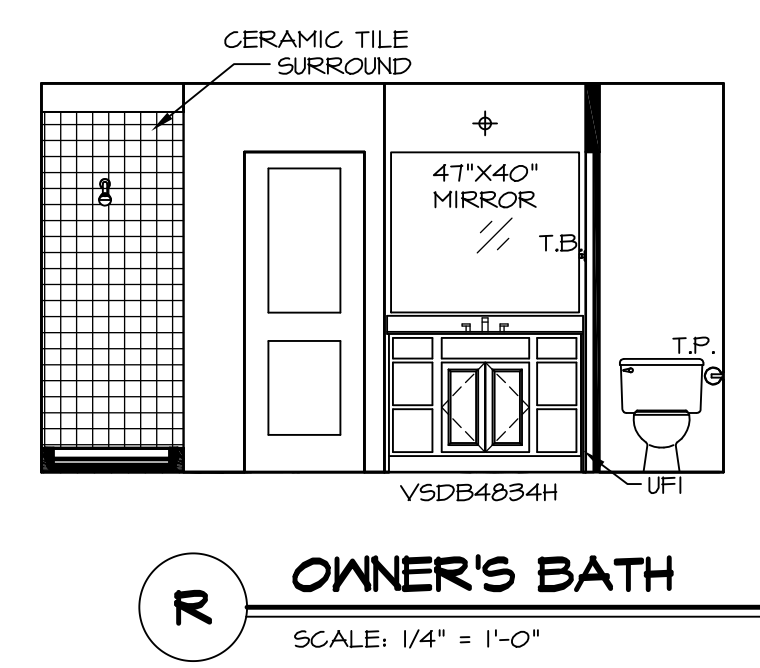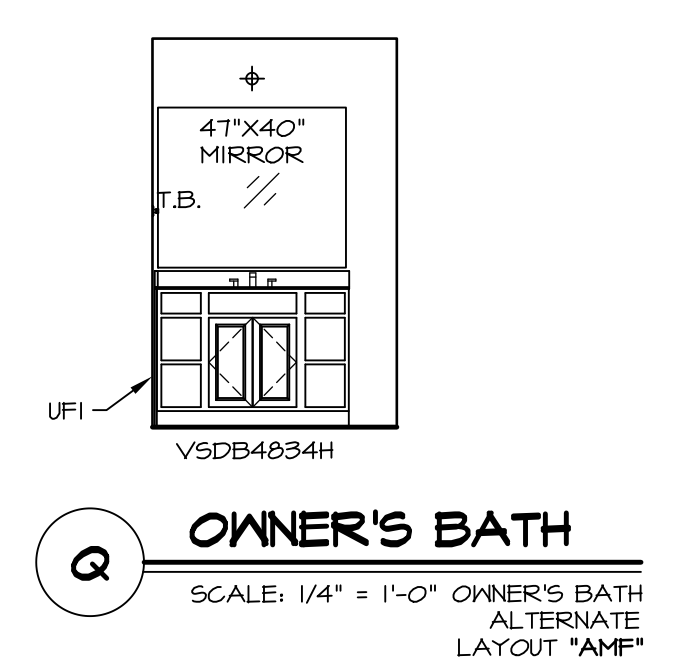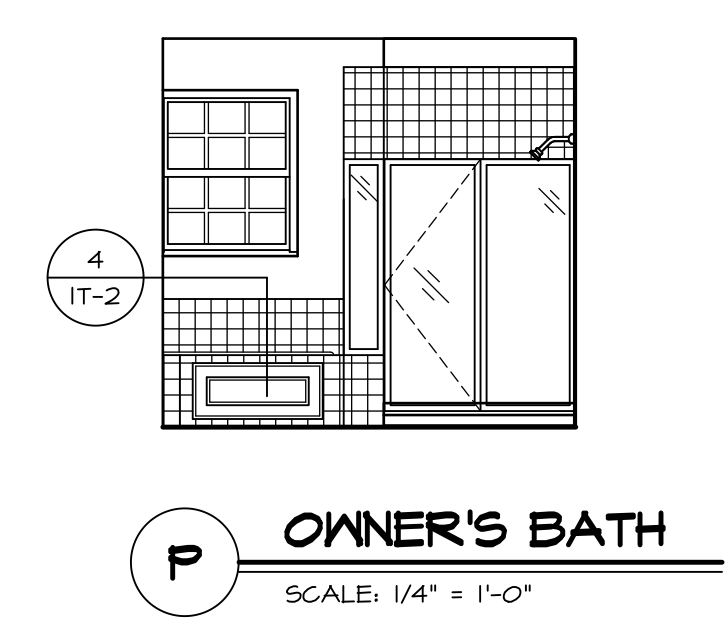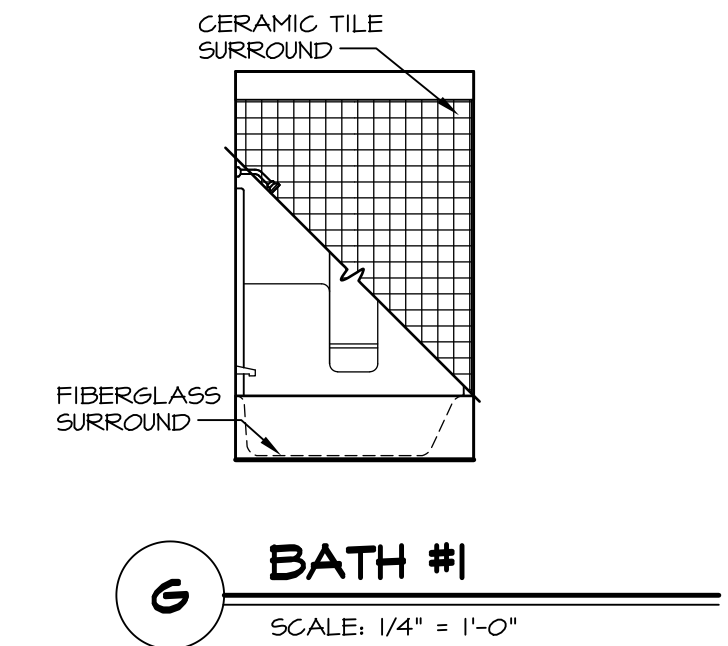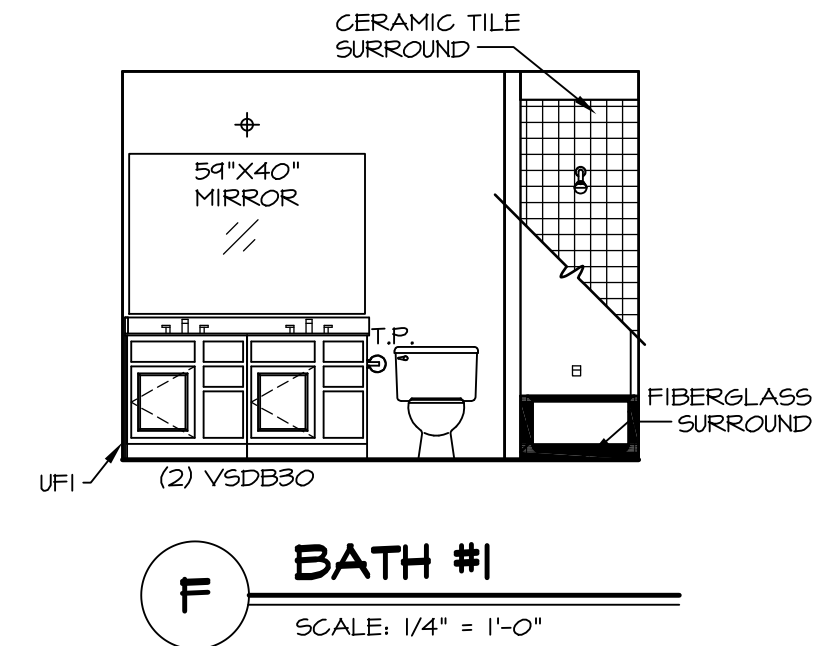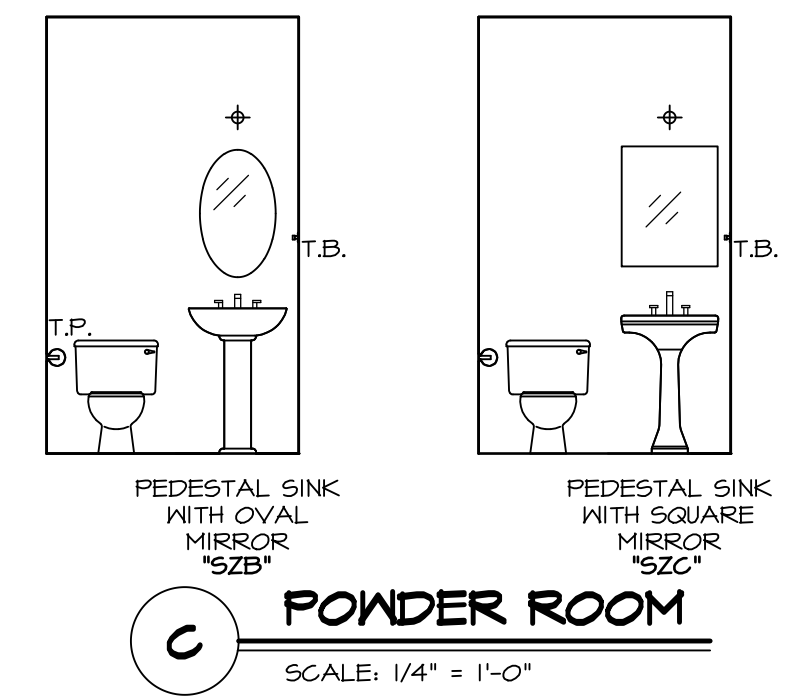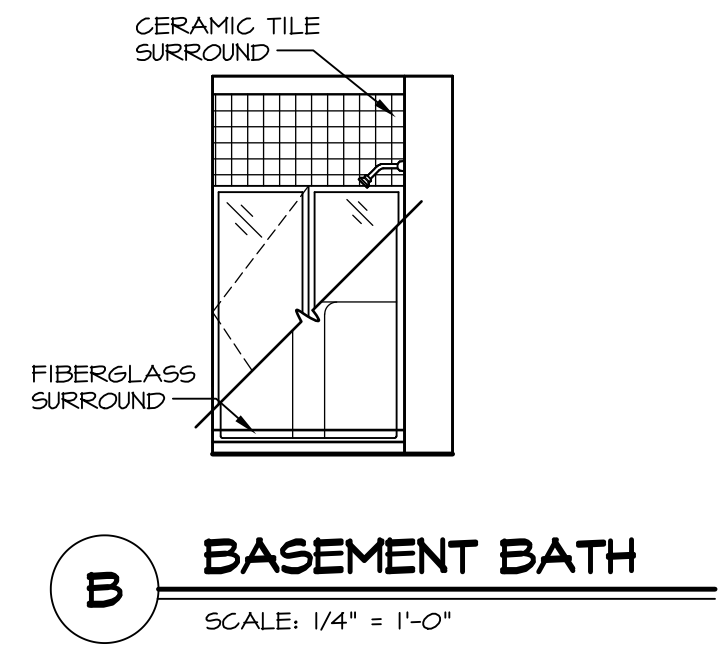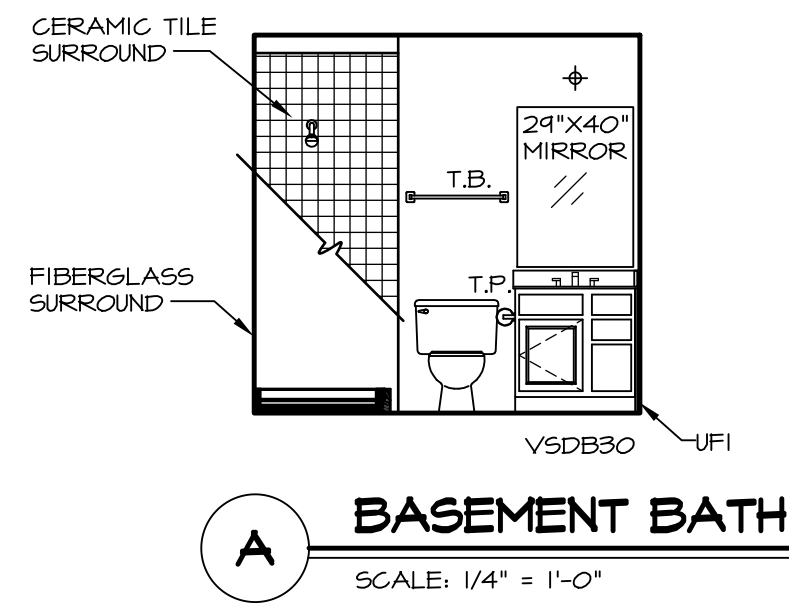


- NOTES:**
- TEMPERED GLASS SHOWER ENCLOSURE WITH SWING DOOR OR OPTIONAL SLIDING DOOR BY DIVISION
 - TUB ACCESS PANELS PROVIDED AS NEEDED, ALL MATERIALS BY DIVISION
 - REFER TO SHEET IT-2 FOR TUB AND SHOWER DETAILS.
 - ALL VSDB24-42 DRAWERS TO BE SET ON RIGHT HAND.
 - BATH ELEVATIONS ARE SHOWN PER PLAN.

SHEET NO. A-13	MODEL LONDON	SET NO. LDN00	VERSION 02	DRAWN BY SDTT	DATE: 7/30/15	OPTION
		DRAWING TITLE BATH ELEVATIONS				
OPTION DESCRIPTION		NVR, Inc. owner, expressly reserves its copyright in these plans. These plans are not to be reproduced, changed, copied, or otherwise used in any way without the written consent of NVR, Inc.				
55		 NVR, Inc. Architectural Services Architects 5285 Westpark Drive Frederick, MD 21703				
C:\NVR\Solves\LONDON_LDNO0_02\DCY-B1-0019\62000A\SheetA Lot_Specific\55 A-13 BATH_LS.dwg 12/17/17 - 3:03 PM						

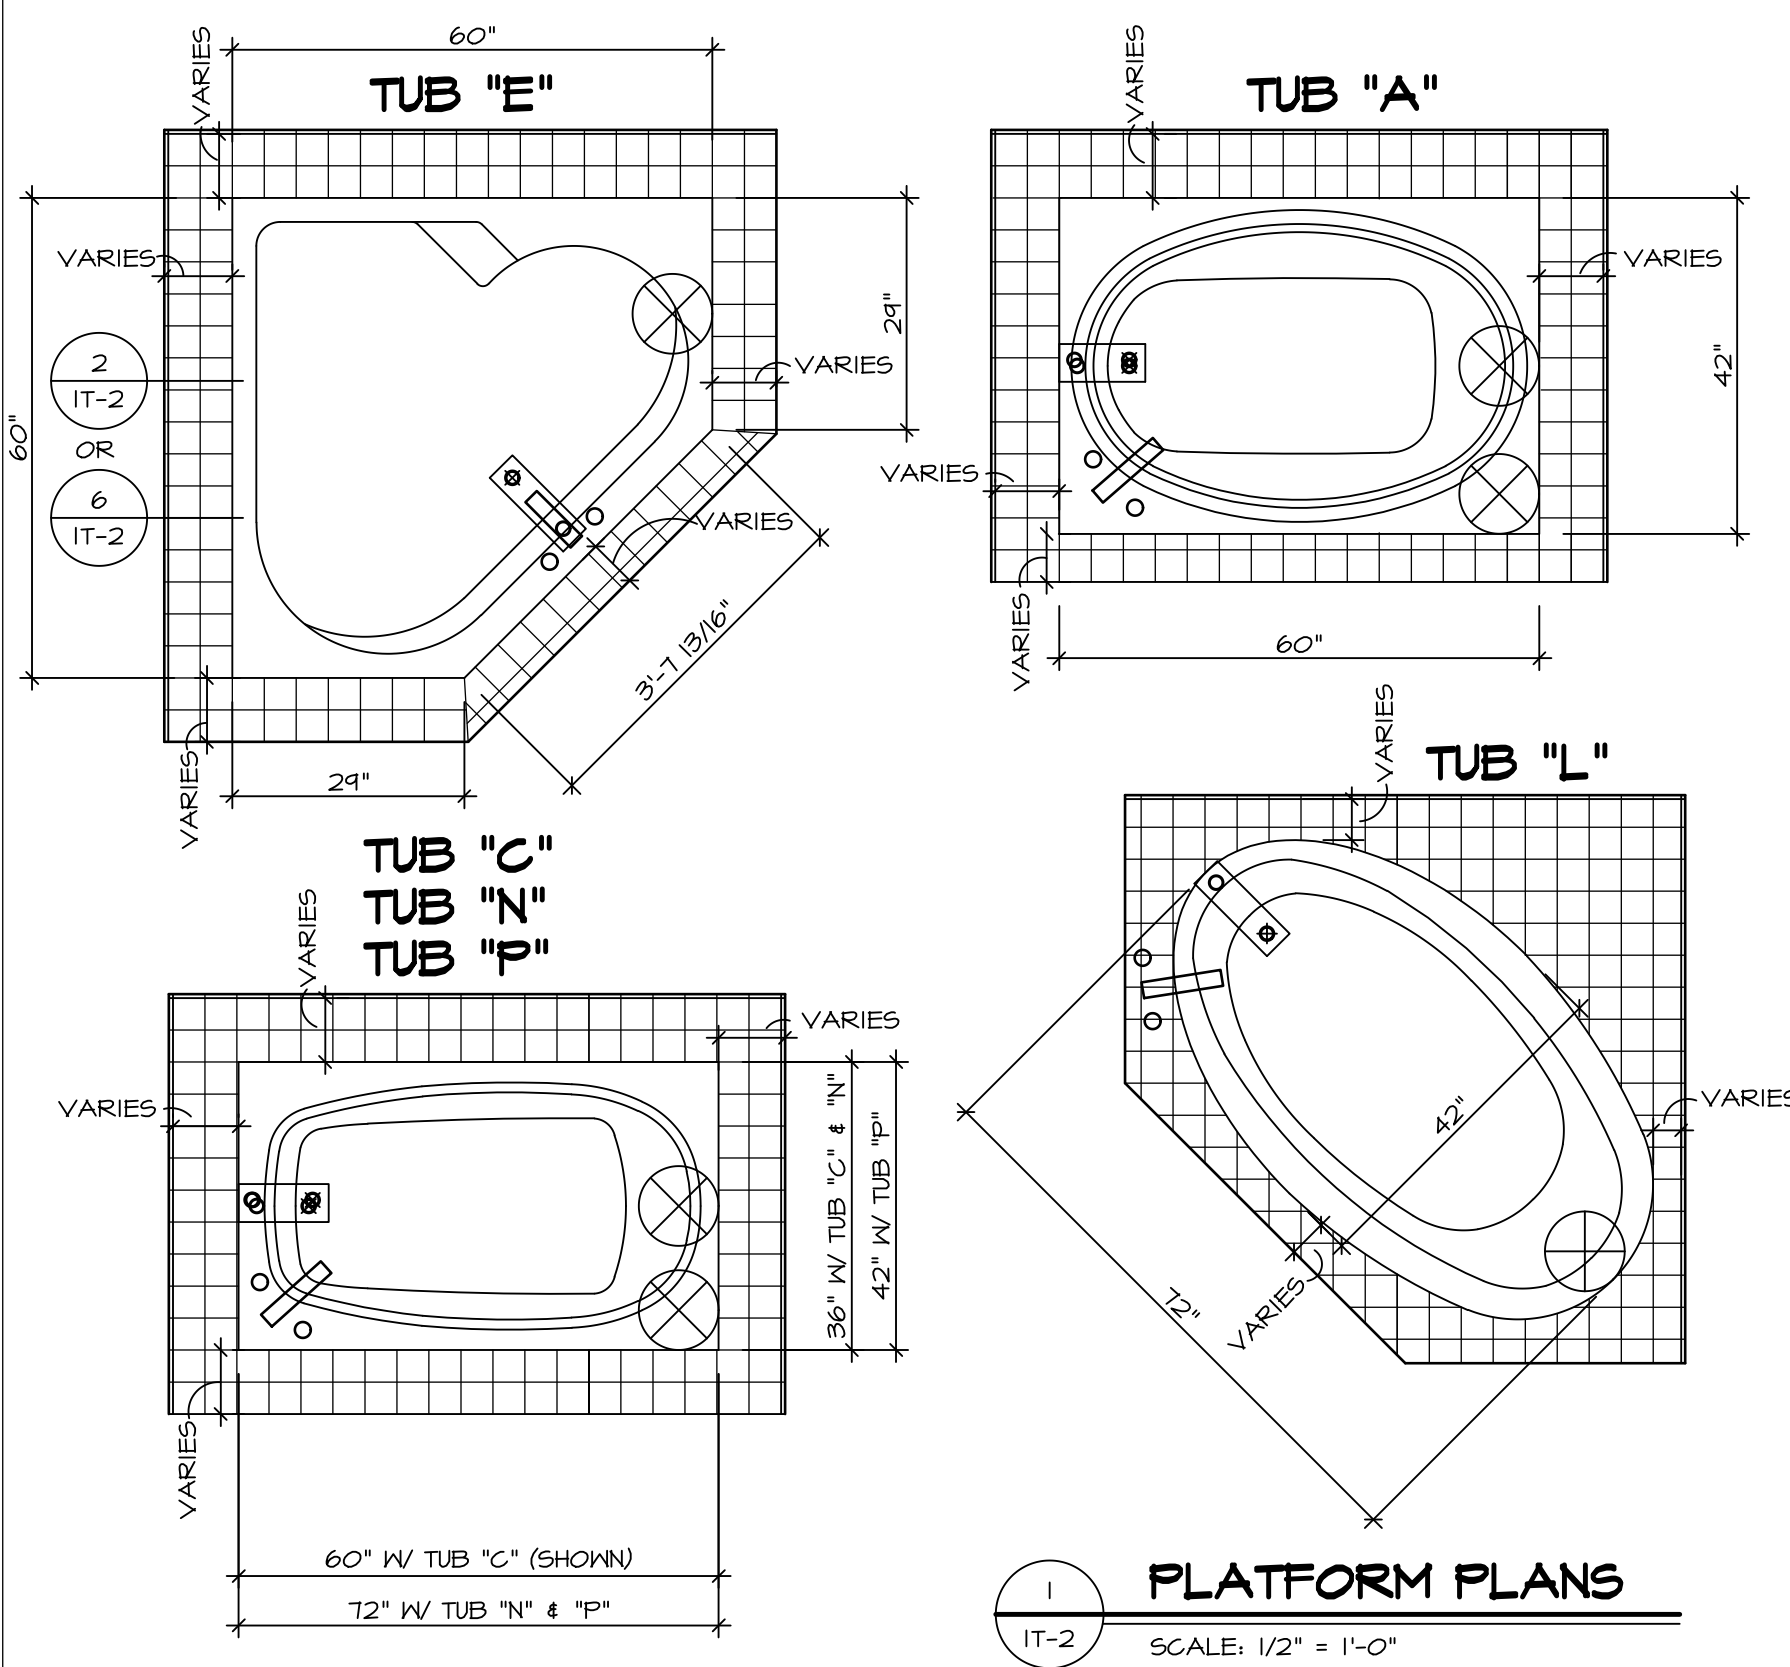


1 PLATFORM PLANS
SCALE: 1/2" = 1'-0"


TUB	MANUF.	HEIGHT	WIDTH	LENGTH	TUB DECK PANEL HEIGHT
"A"	KOHLER/STERLING	18 3/4"	42"	60"	17 1/8"
"C"	KOHLER/STERLING	18 3/4"	36"	60"	17 1/8"
"E"	KOHLER/STERLING	19 1/2"	60"	60"	17 7/8"
"L"	KOHLER/STERLING	18 1/2"	42"	72"	16 7/8"
"N"	KOHLER/STERLING	18 3/4"	36"	72"	17 1/8"
"P"	KOHLER/STERLING	18 3/4"	42"	72"	17 1/8"

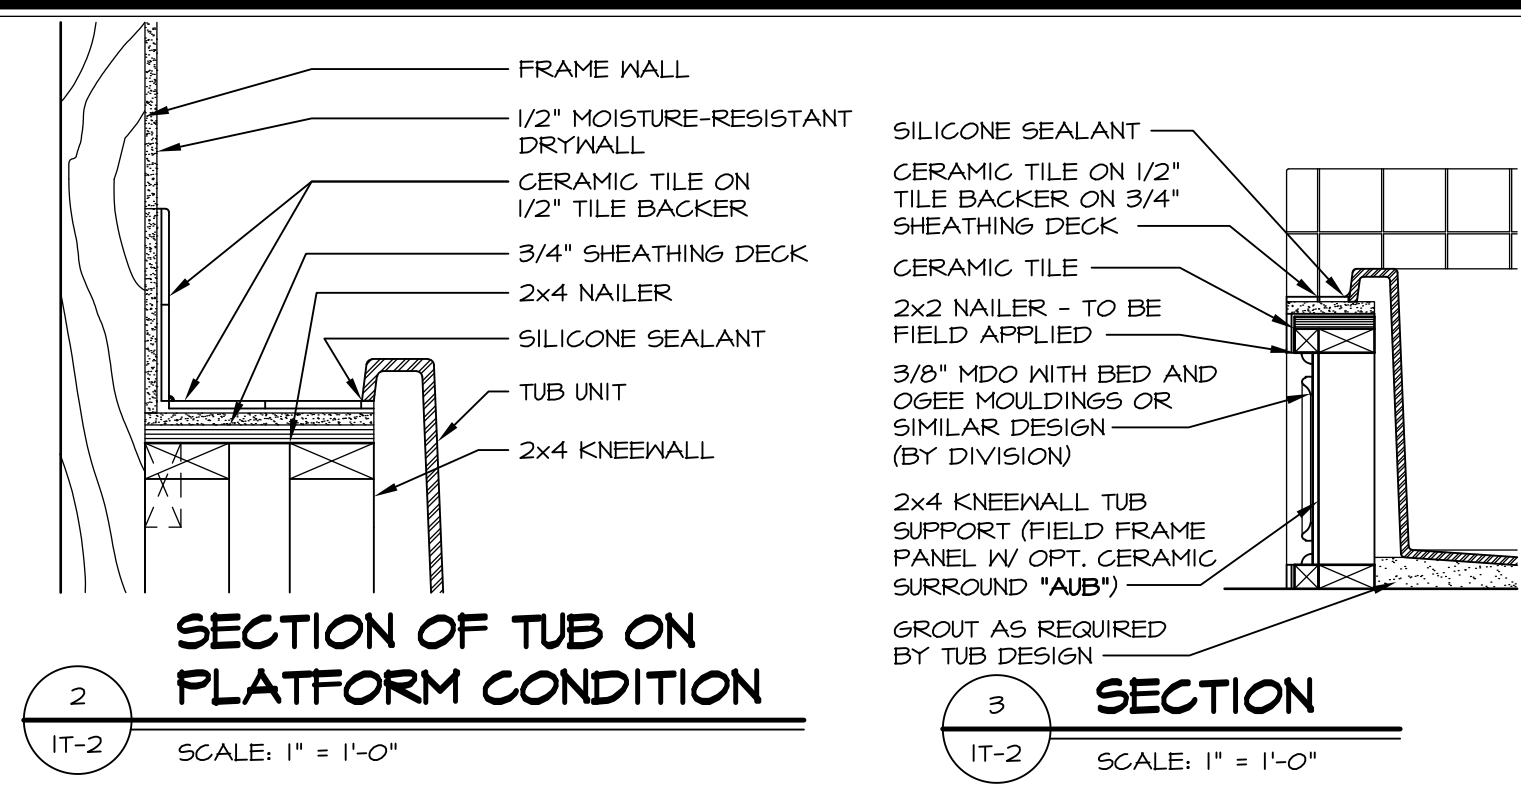


2 SECTION OF TUB ON PLATFORM CONDITION
SCALE: 1" = 1'-0"

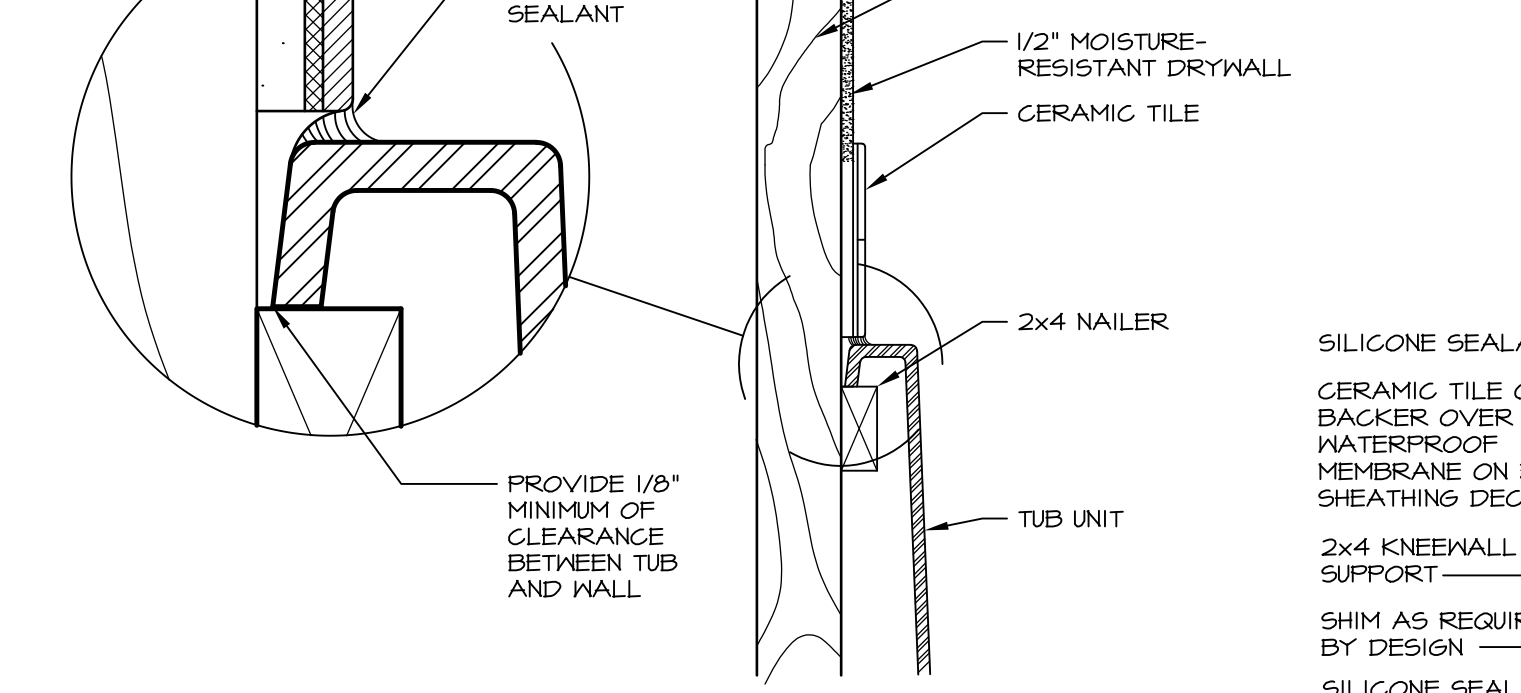


3 SECTION OF TUB TO WALL CONDITION
SCALE: 1" = 1'-0"

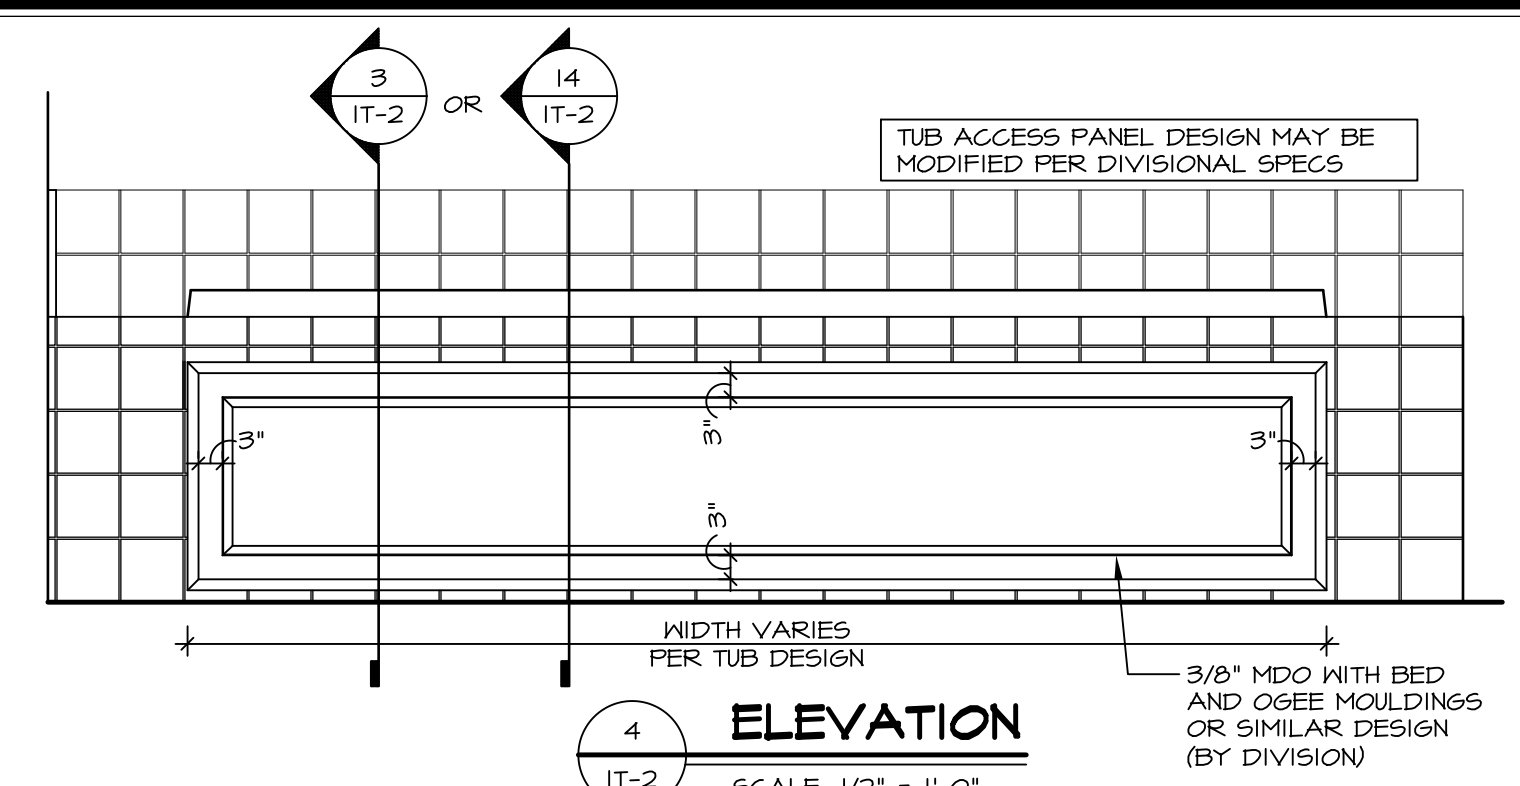


4 ELEVATION
SCALE: 1/2" = 1'-0"

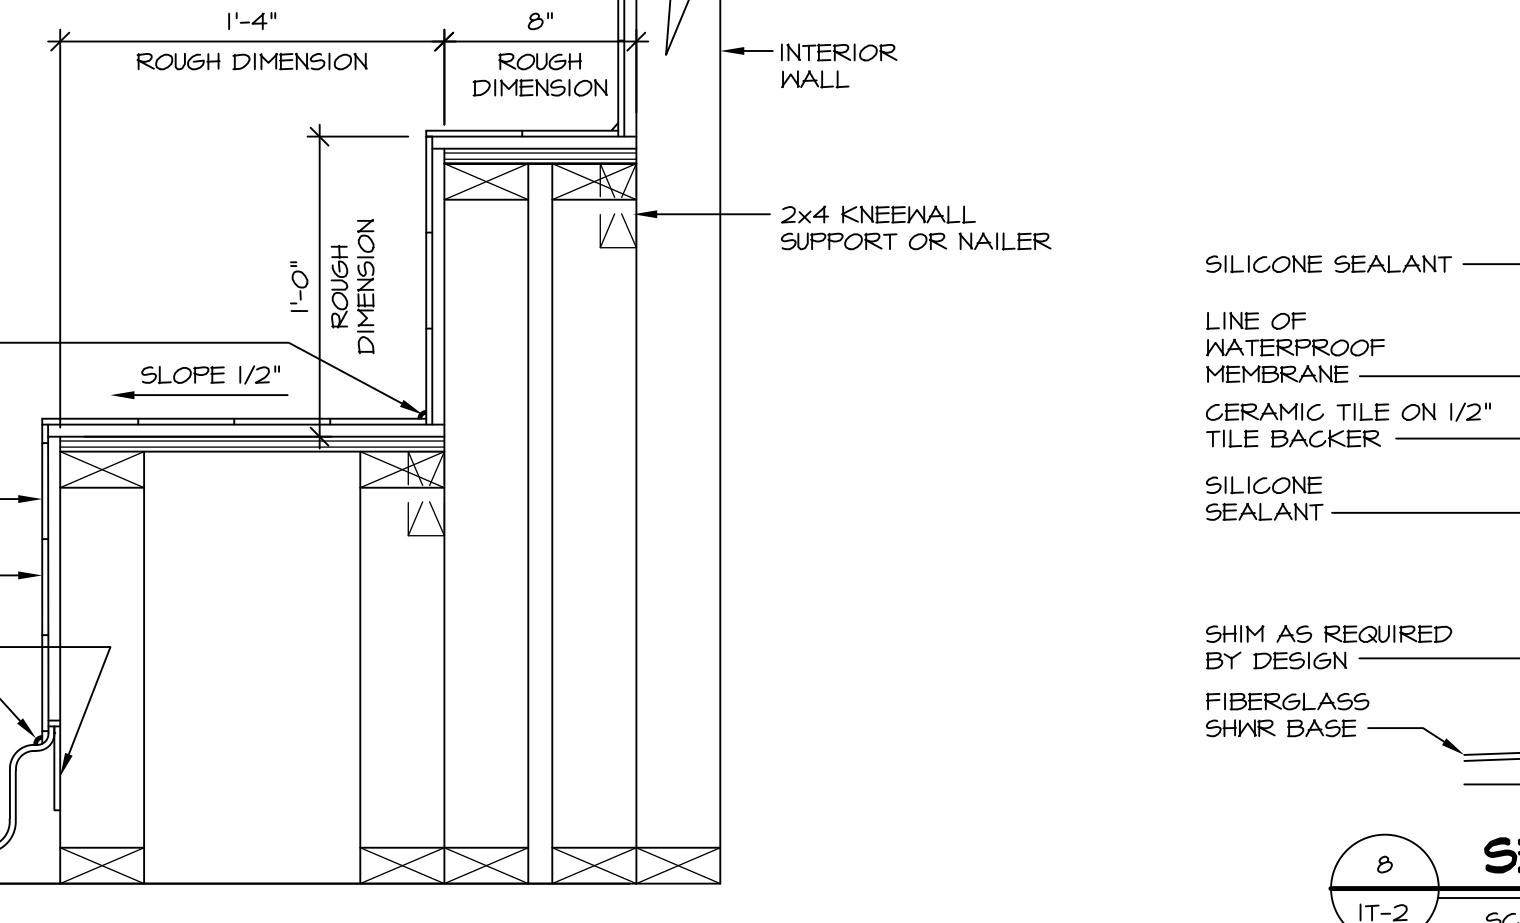


5 INSULATION DETAIL
SCALE: 1" = 1'-0" AT EXTERIOR WALL

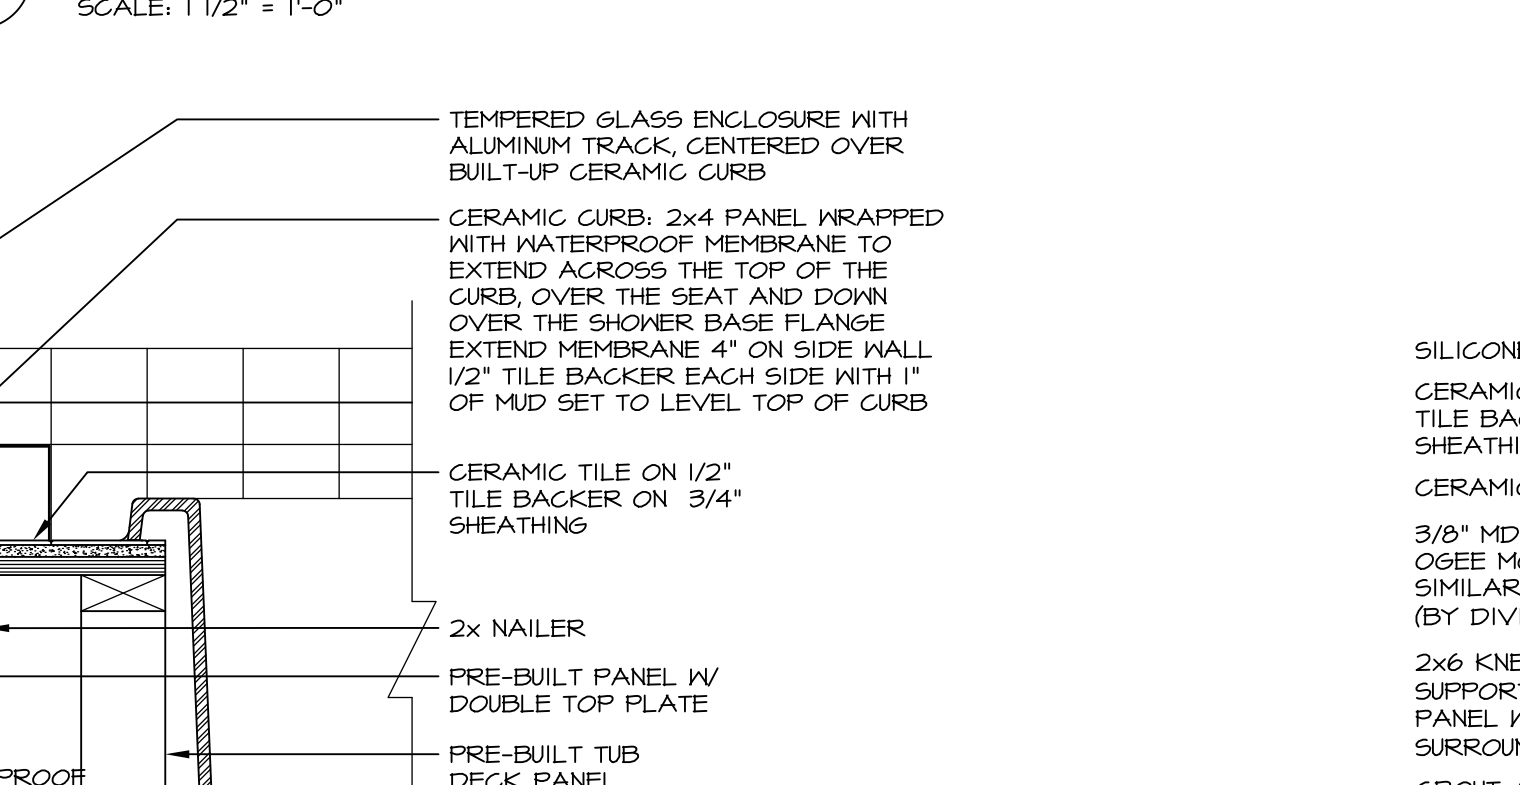


6 SECTION OF SHOWER SEAT AND SHELF
SCALE: 1/2" = 1'-0"

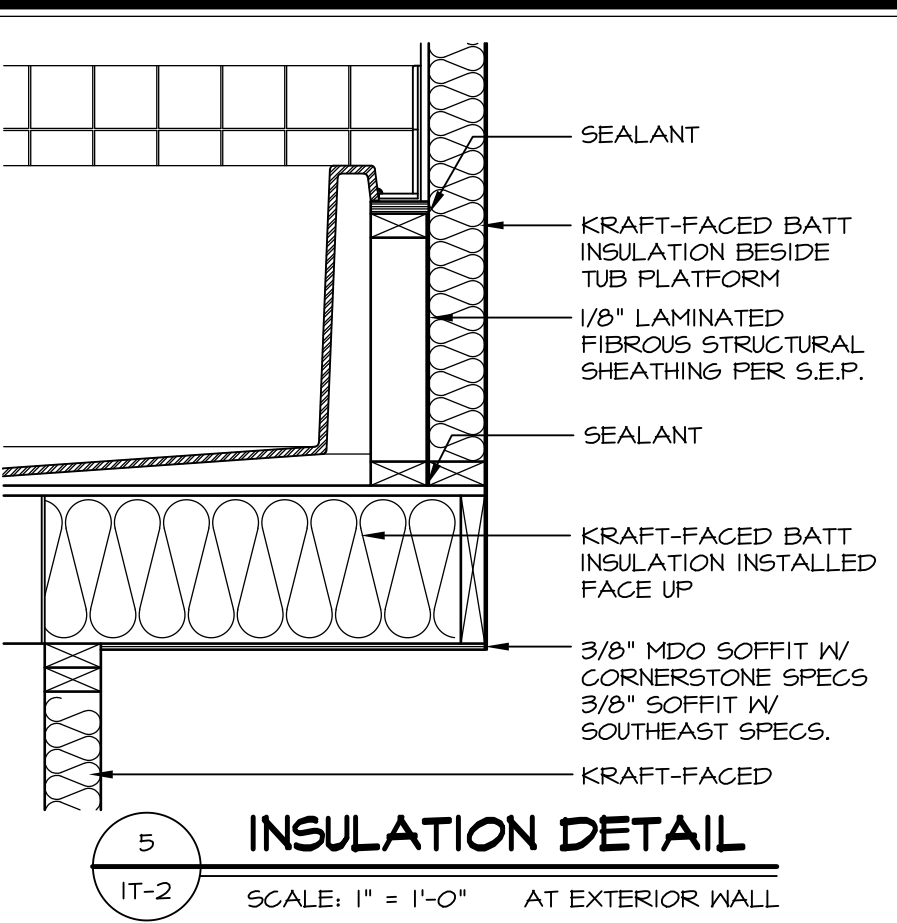


7 SECTION OF SHOWER SEAT
SCALE: 1-1/2" = 1'-0" FIBERGLASS SHOWER BASE

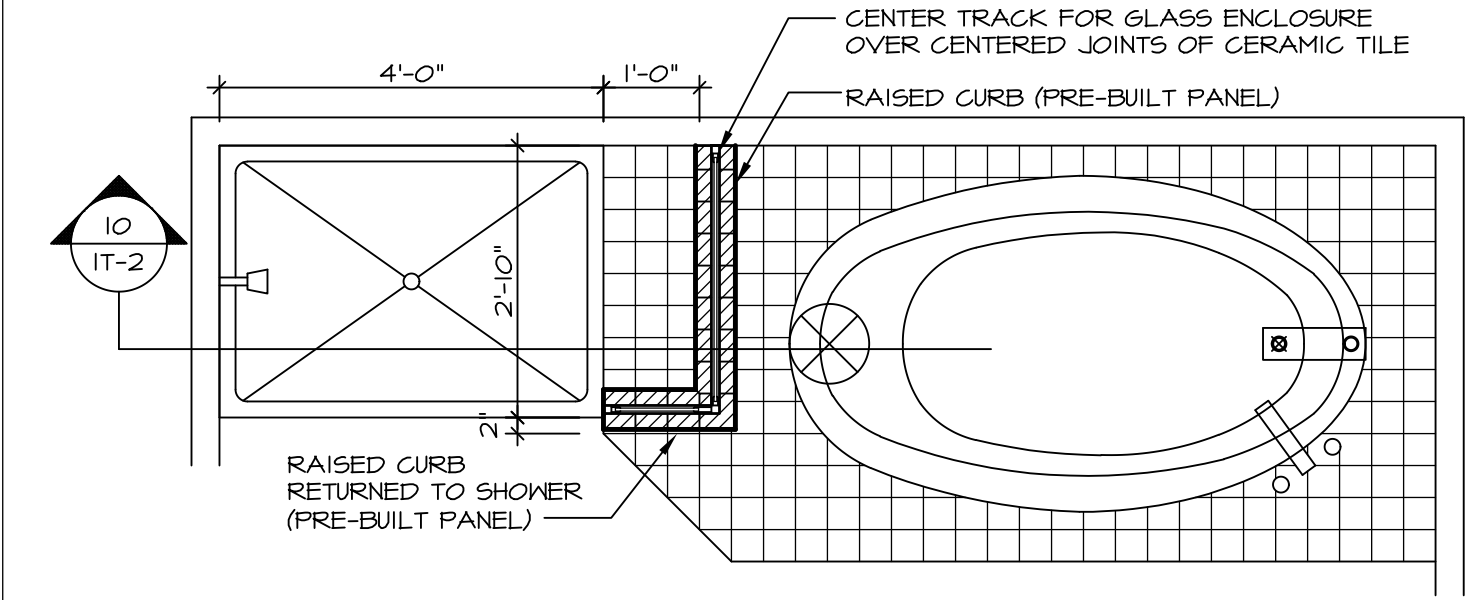


8 SHOWER SEAT PLAN / DETAIL
SCALE: 1/2" = 1'-0"

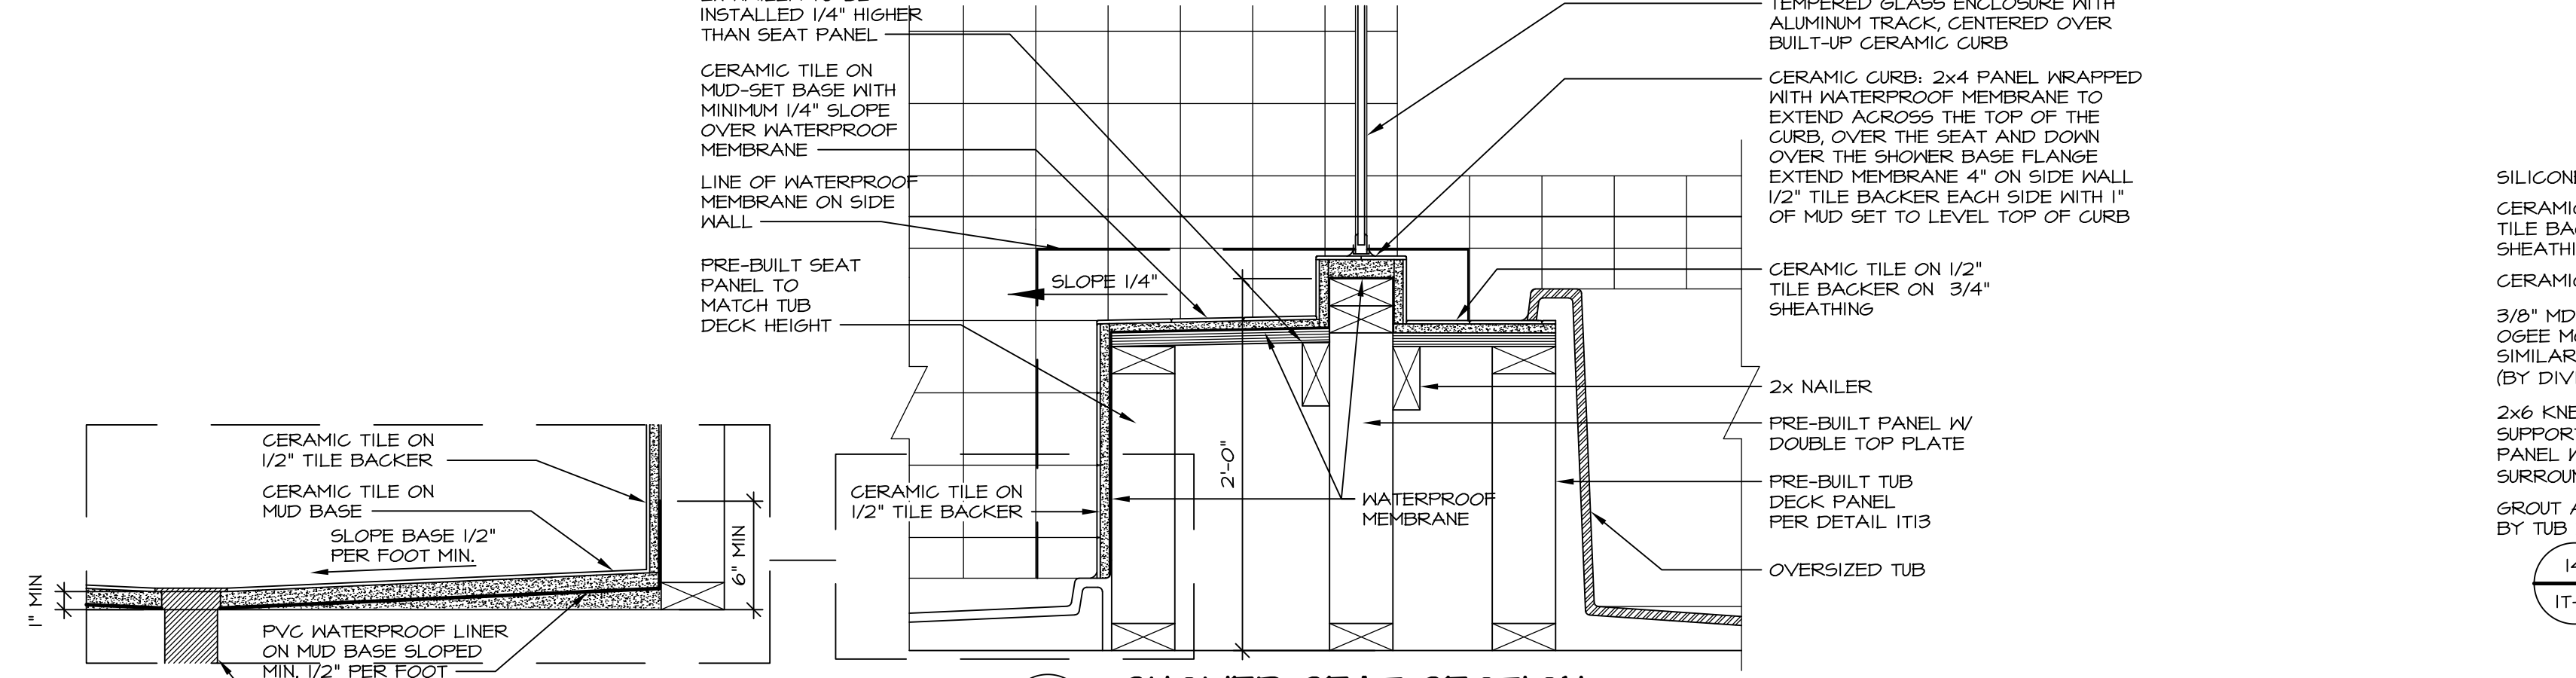


9 SHOWER SEAT SECTION
SCALE: 1-1/2" = 1'-0"

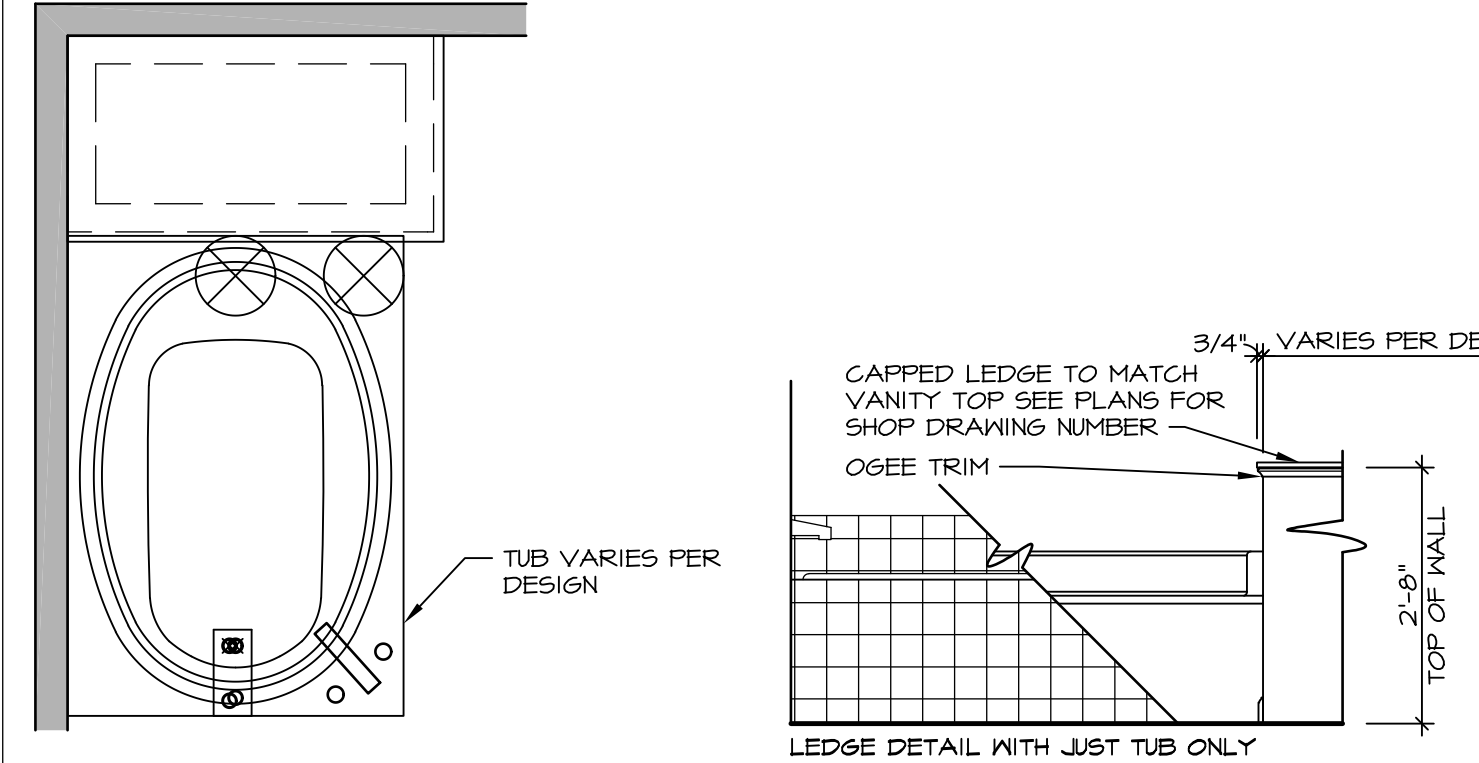


10 BATHROOM LEDGE DETAIL
SCALE: 1/2" = 1'-0"

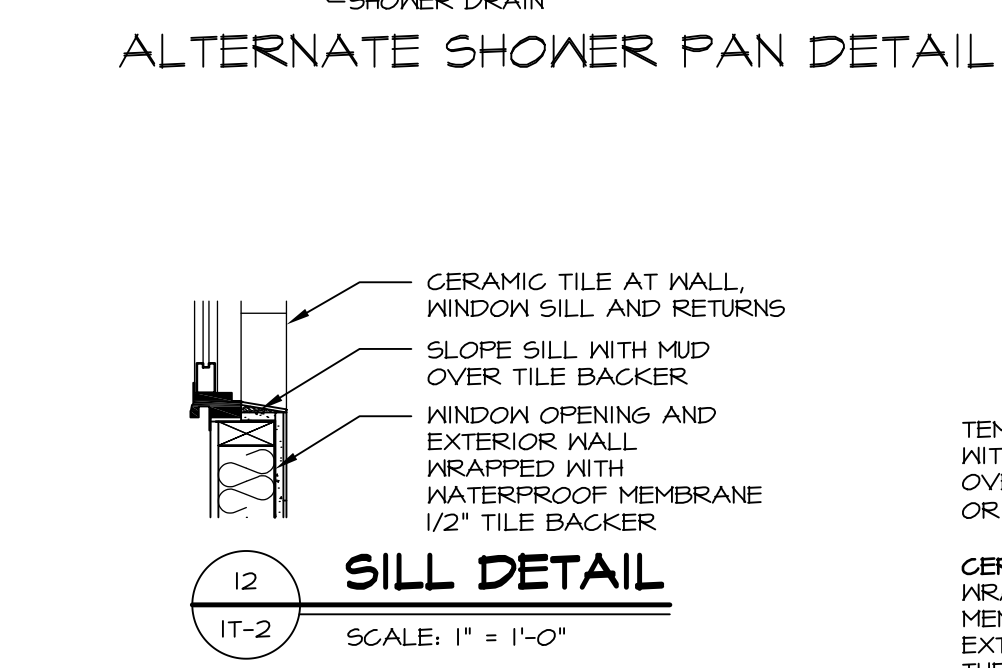


11 ALTERNATE SHOWER PAN DETAIL
SCALE: 1-1/2" = 1'-0"

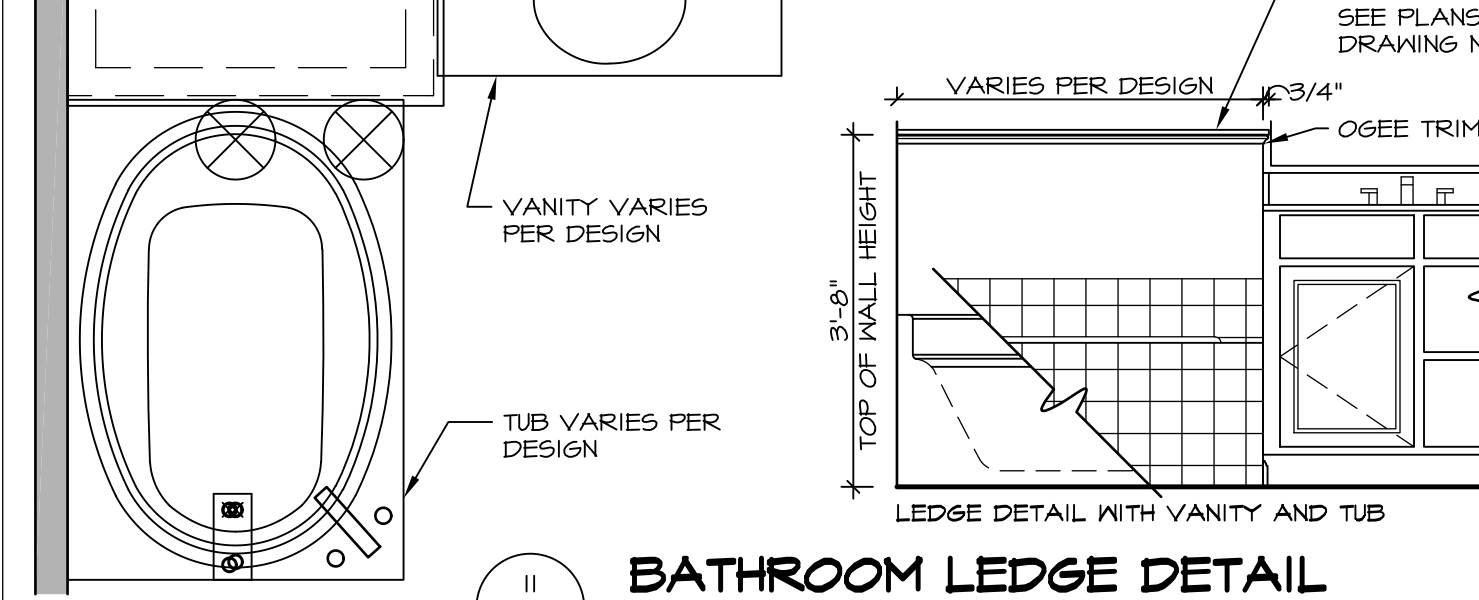

12 BATHROOM LEDGE DETAIL
SCALE: 1/2" = 1'-0"

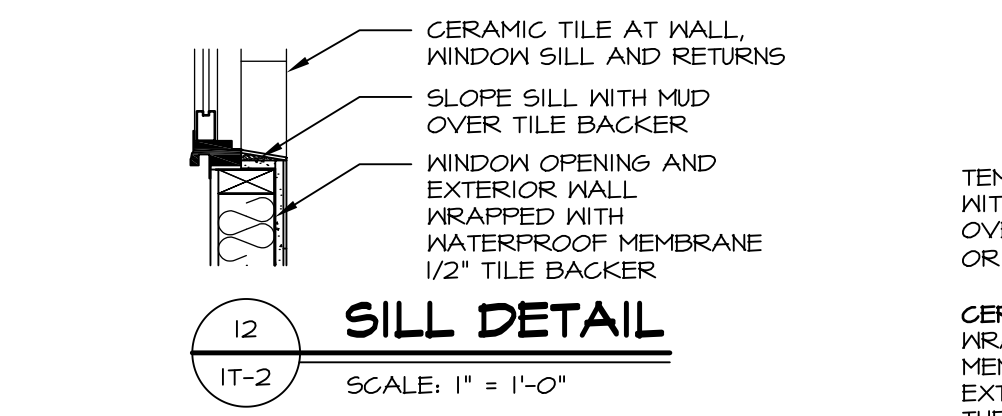

13 SILL DETAIL
SCALE: 1" = 1'-0"

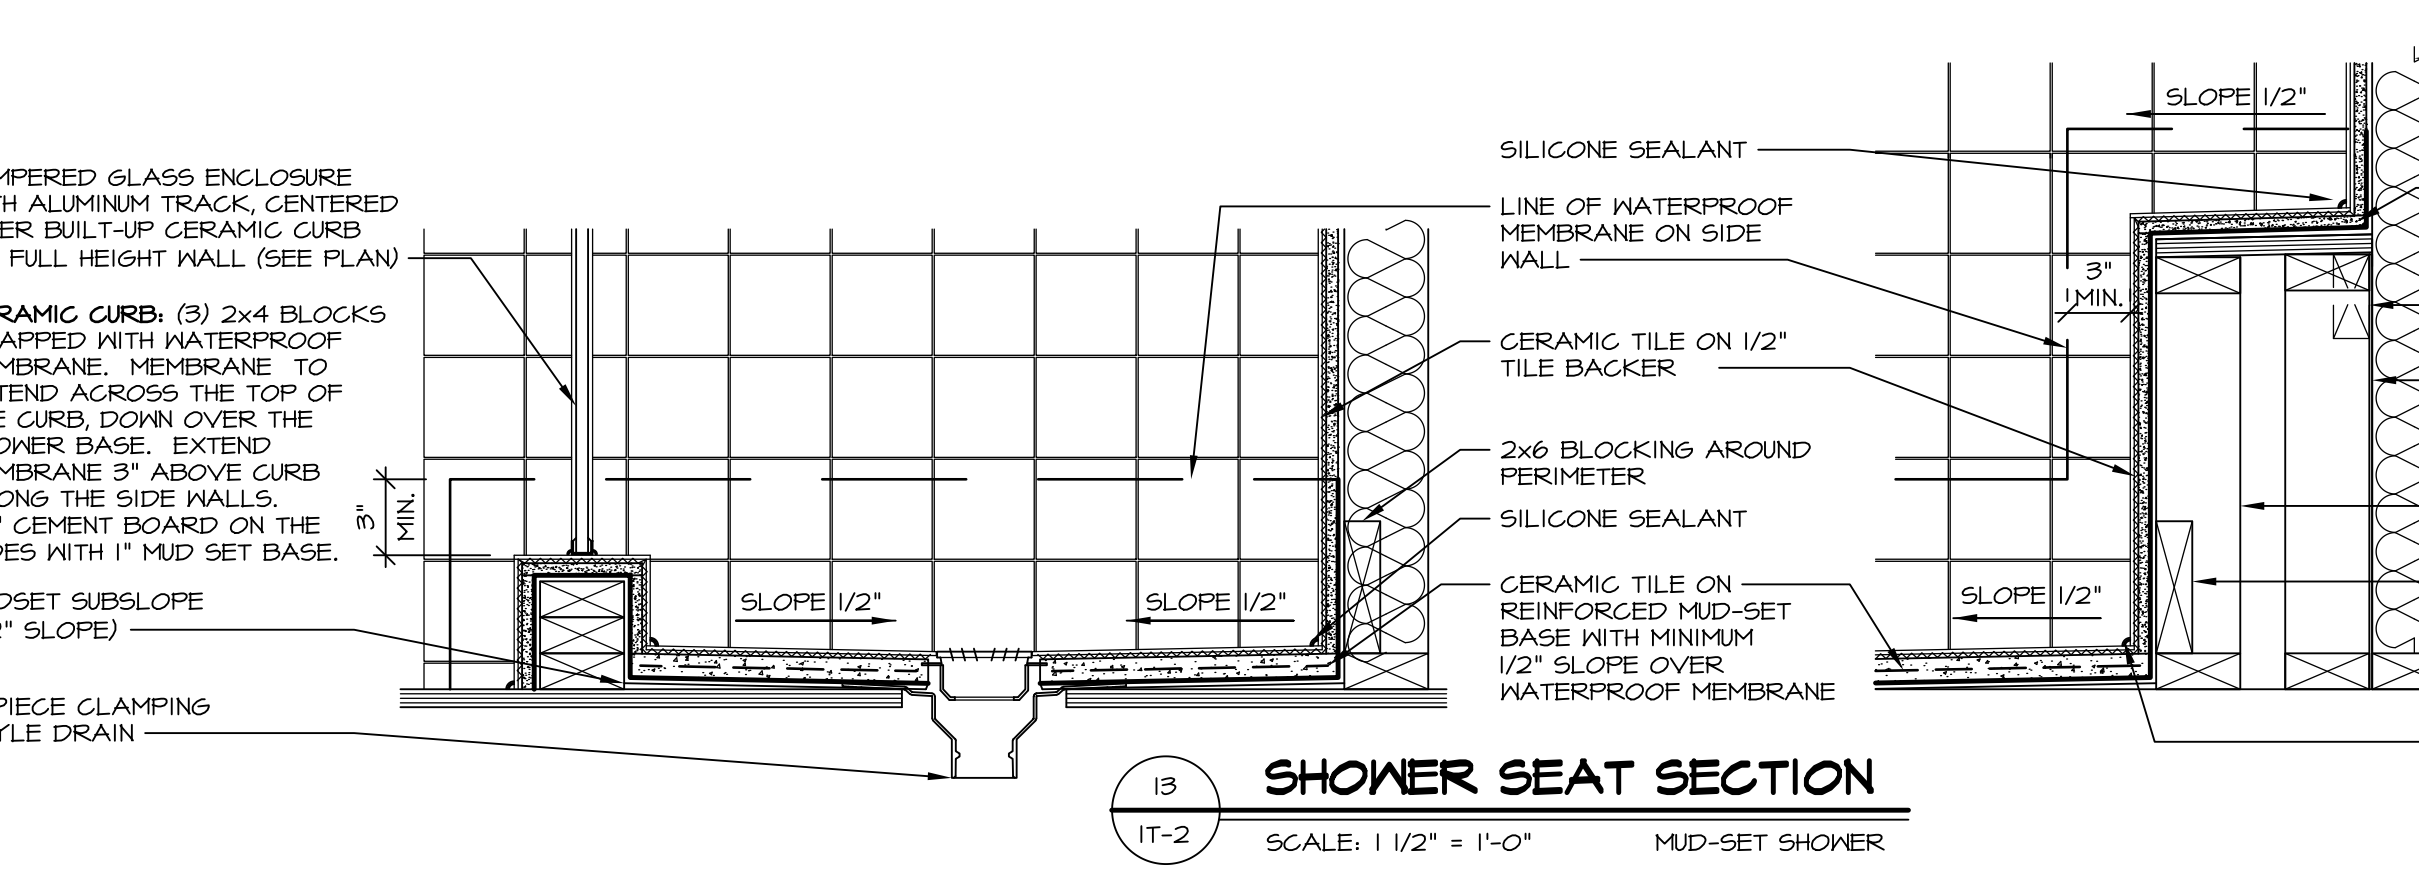


14 SHOWER SEAT SECTION
SCALE: 1-1/2" = 1'-0" MUD-SET SHOWER

REVISIONS

REV. NO.	DATE	DESCRIPTION
1	5/1/17	EBP - REVISED DETAIL 1 AND 11 TO REMOVE TUB ACCESS PANEL REF. (DSS #15 5414)
2	9/2/17	EBP - REVISED T-FLY NOTE TO CALL OUT LFS
3	9/2/17	EBP - REVISED NOTE ON DETAIL #1 - REVISED ORDER OF MATERIAL PARA#4934

NVR, Inc., owner, expressly reserves its common law copyright and other property rights in these plans. These plans are not to be reproduced, copied, or otherwise used in any way without the prior written consent of NVR, Inc.

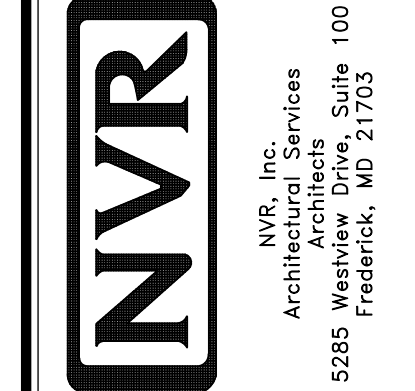

SET NO. NVR

VERSION

DRAWN BY

DATE:

OPTION

MODEL

STANDARD DETAILS

DRAWING TITLE

INTERIOR TRIM DETAILS

BATH DETAILS

OPTION DESCRIPTION

SHEET NO. **IT-2**

J:\Dwg\NVR\Interior Trim\IT2.dwg 09/27/17 - 9:20 am