

BH 172

7793 N. Bel Haven Lan

1 story slab

1 small tankless heater

Laundry Tub

2 Hose bibs - no valves required

1 - tiled shower

2 - LH Tub

Irrigation system

Ice maker

Humidifier valve

Gas Furnace , Range , Tankless Heater , Courtyard

Grill and Fireplace



BH 172

MASTER PLAN: Promenade | ELEVATION: Elev A - Front Gable | COMMUNITY: Bel Haven | LOT NUMBER: 172 | ADDRESS: 7793 N. Bel Haven Lane, West Chester, Ohio 45069

PLANS POWERED BY HIGHARC

PROJECT SUMMARY	
BUILDING AREA	
CONDITIONED AREA	
FIRST FLOOR SF	2282 SF
TOTAL CONDITIONED AREA :	2282 SF
TOTAL GARAGE AREA :	
	551 SF
FRONT PORCH AND PORTICO AREA :	183 SF
REAR PORCH AREA :	0 SF
PATIO AREA :	363 SF

GENERAL NOTES
ONLY LOCATION SPECIFIC OPTIONS ARE SHOWN ON THESE DRAWINGS. PLEASE REFER TO OPTION SUMMARY AND/OR PURCHASE ORDERS FOR A COMPLETE LISTING OF OPTIONS.
DESIGN CRITERIA:
NUMBER OF STORIES: 1
BUILDING WIDTH: 42'-4"
BUILDING DEPTH: 83'-0"
BUILDING HEIGHT: 21'-10 1/2"
GOVERNMENTAL CODES AND STANDARDS
HOME TO BE BUILT TO CONFORM TO ALL APPLICABLE LOCAL CODES, PRACTICES AND STANDARDS.
BUILDING CODE ANALYSIS / DESIGN CRITERIA
HOME TO BE BUILT TO 2019 RESIDENTIAL CODE OF OHIO STANDARDS

GRAPHIC SYMBOLS & LEGEND	
	FIRST FLOOR EL. 0'-0"
	ROOF SLOPE
	SD
	SD / CO

SHEET INDEX	
COVER	A-000
SCHEDULES	A-010
GENERAL NOTES	A-020
FOUNDATION PLAN	A-050
FIRST FLOOR PLAN	A-101
ROOF PLAN	A-120
FRONT / BACK ELEVATION	A-200
LEFT / RIGHT ELEVATION	A-201
DETAILS	A-401
DETAILS	A-402
DETAILS	A-403
DETAILS	A-404
DETAILS	A-405
PERSPECTIVE VIEWS	A-900
FIRST FLOOR ELECTRICAL PLAN	E-101
SHEAR WALL DETAILS	S-100
SHEAR WALL PLAN	S-101

Higharc, Inc. is not an architectural firm nor are the artistic representations contained herein intended to be construed as ready-to-use architectural plans, construction documents, drawings, renderings, or any other similar or related documents. All drawings are artist's representations only and solely intended to reflect design intent derived exclusively from the home building plans and associated information, data, and specifications provided by Epcon Foundation DG. Higharc, Inc. is not responsible, nor may it be held liable for any errors or omissions contained herein or resulting from its usage. Any usage of the representations should be reviewed by local professionals to ensure conformance with local and state codes and be field verified prior to the start of any construction.

ISSUE	DESCRIPTION	DATE
01	BUILDER SET	9/25/2025

PROJECT

PLAN: BH Promenade D3

ELEV: Elev A - Front Gable

LOT: 172

DRAWING TITLE

COVER

SHEET NUMBER

A-000



Bel Haven LLC
West Chester, OH

Higarcia, Inc. is not an architectural firm nor are the artistic representations contained herein intended to be construed as ready-to-use architectural plans, construction documents, drawings, renderings, or any other similar or related documents. All drawings are artist's representations only and solely intended to reflect design intent derived exclusively from the home building plans and associated information, data, and specifications provided by Epon Foundation DG. Higarcia, Inc. is not responsible, nor may it be held liable for any errors or omissions contained herein or resulting from its usage. Any usage of the representations should be reviewed by local professionals to ensure conformance with local and state codes and be field verified prior to the start of any construction.

A-050

© 2025 HIGHARC, INC.

NOTES:
THICKENED SLAB SHALL BE REINFORCED
WITH CONTINUOUS (2) #4 REBAR

1

FOUNDATION PLAN

A-050

1/8" = 1'-0" @ 11" x 17"



Epcon Foundation DG

Bel Haven LLC
West Chester, OH.

Higharc, Inc. is not an architectural firm nor are the artistic representations contained herein intended to be construed as ready-to-use architectural plans, construction documents, drawings, renderings, or any other similar or related documents. All drawings are artist's representations only and solely intended to reflect design intent derived exclusively from the home building plans and associated information, data, and specifications provided by Epcon Foundation DG. Higharc, Inc. is not responsible, nor may it be held liable for any errors or omissions contained herein or resulting from its usage. Any usage of the representations should be reviewed by local professionals to ensure conformance with local and state codes and be field verified prior to the start of any construction.


ISSUE	DESCRIPTION	DATE
01	BUILDER SET	9/16/2025


PROJECT
PLAN: BH Promenade D3
ELEV: Elev A - Front Gable
LOT: 164

DRAWING TITLE
FIRST FLOOR
PLAN



SHEET NUMBER
A-101

© 2025 HIGHARC, INC

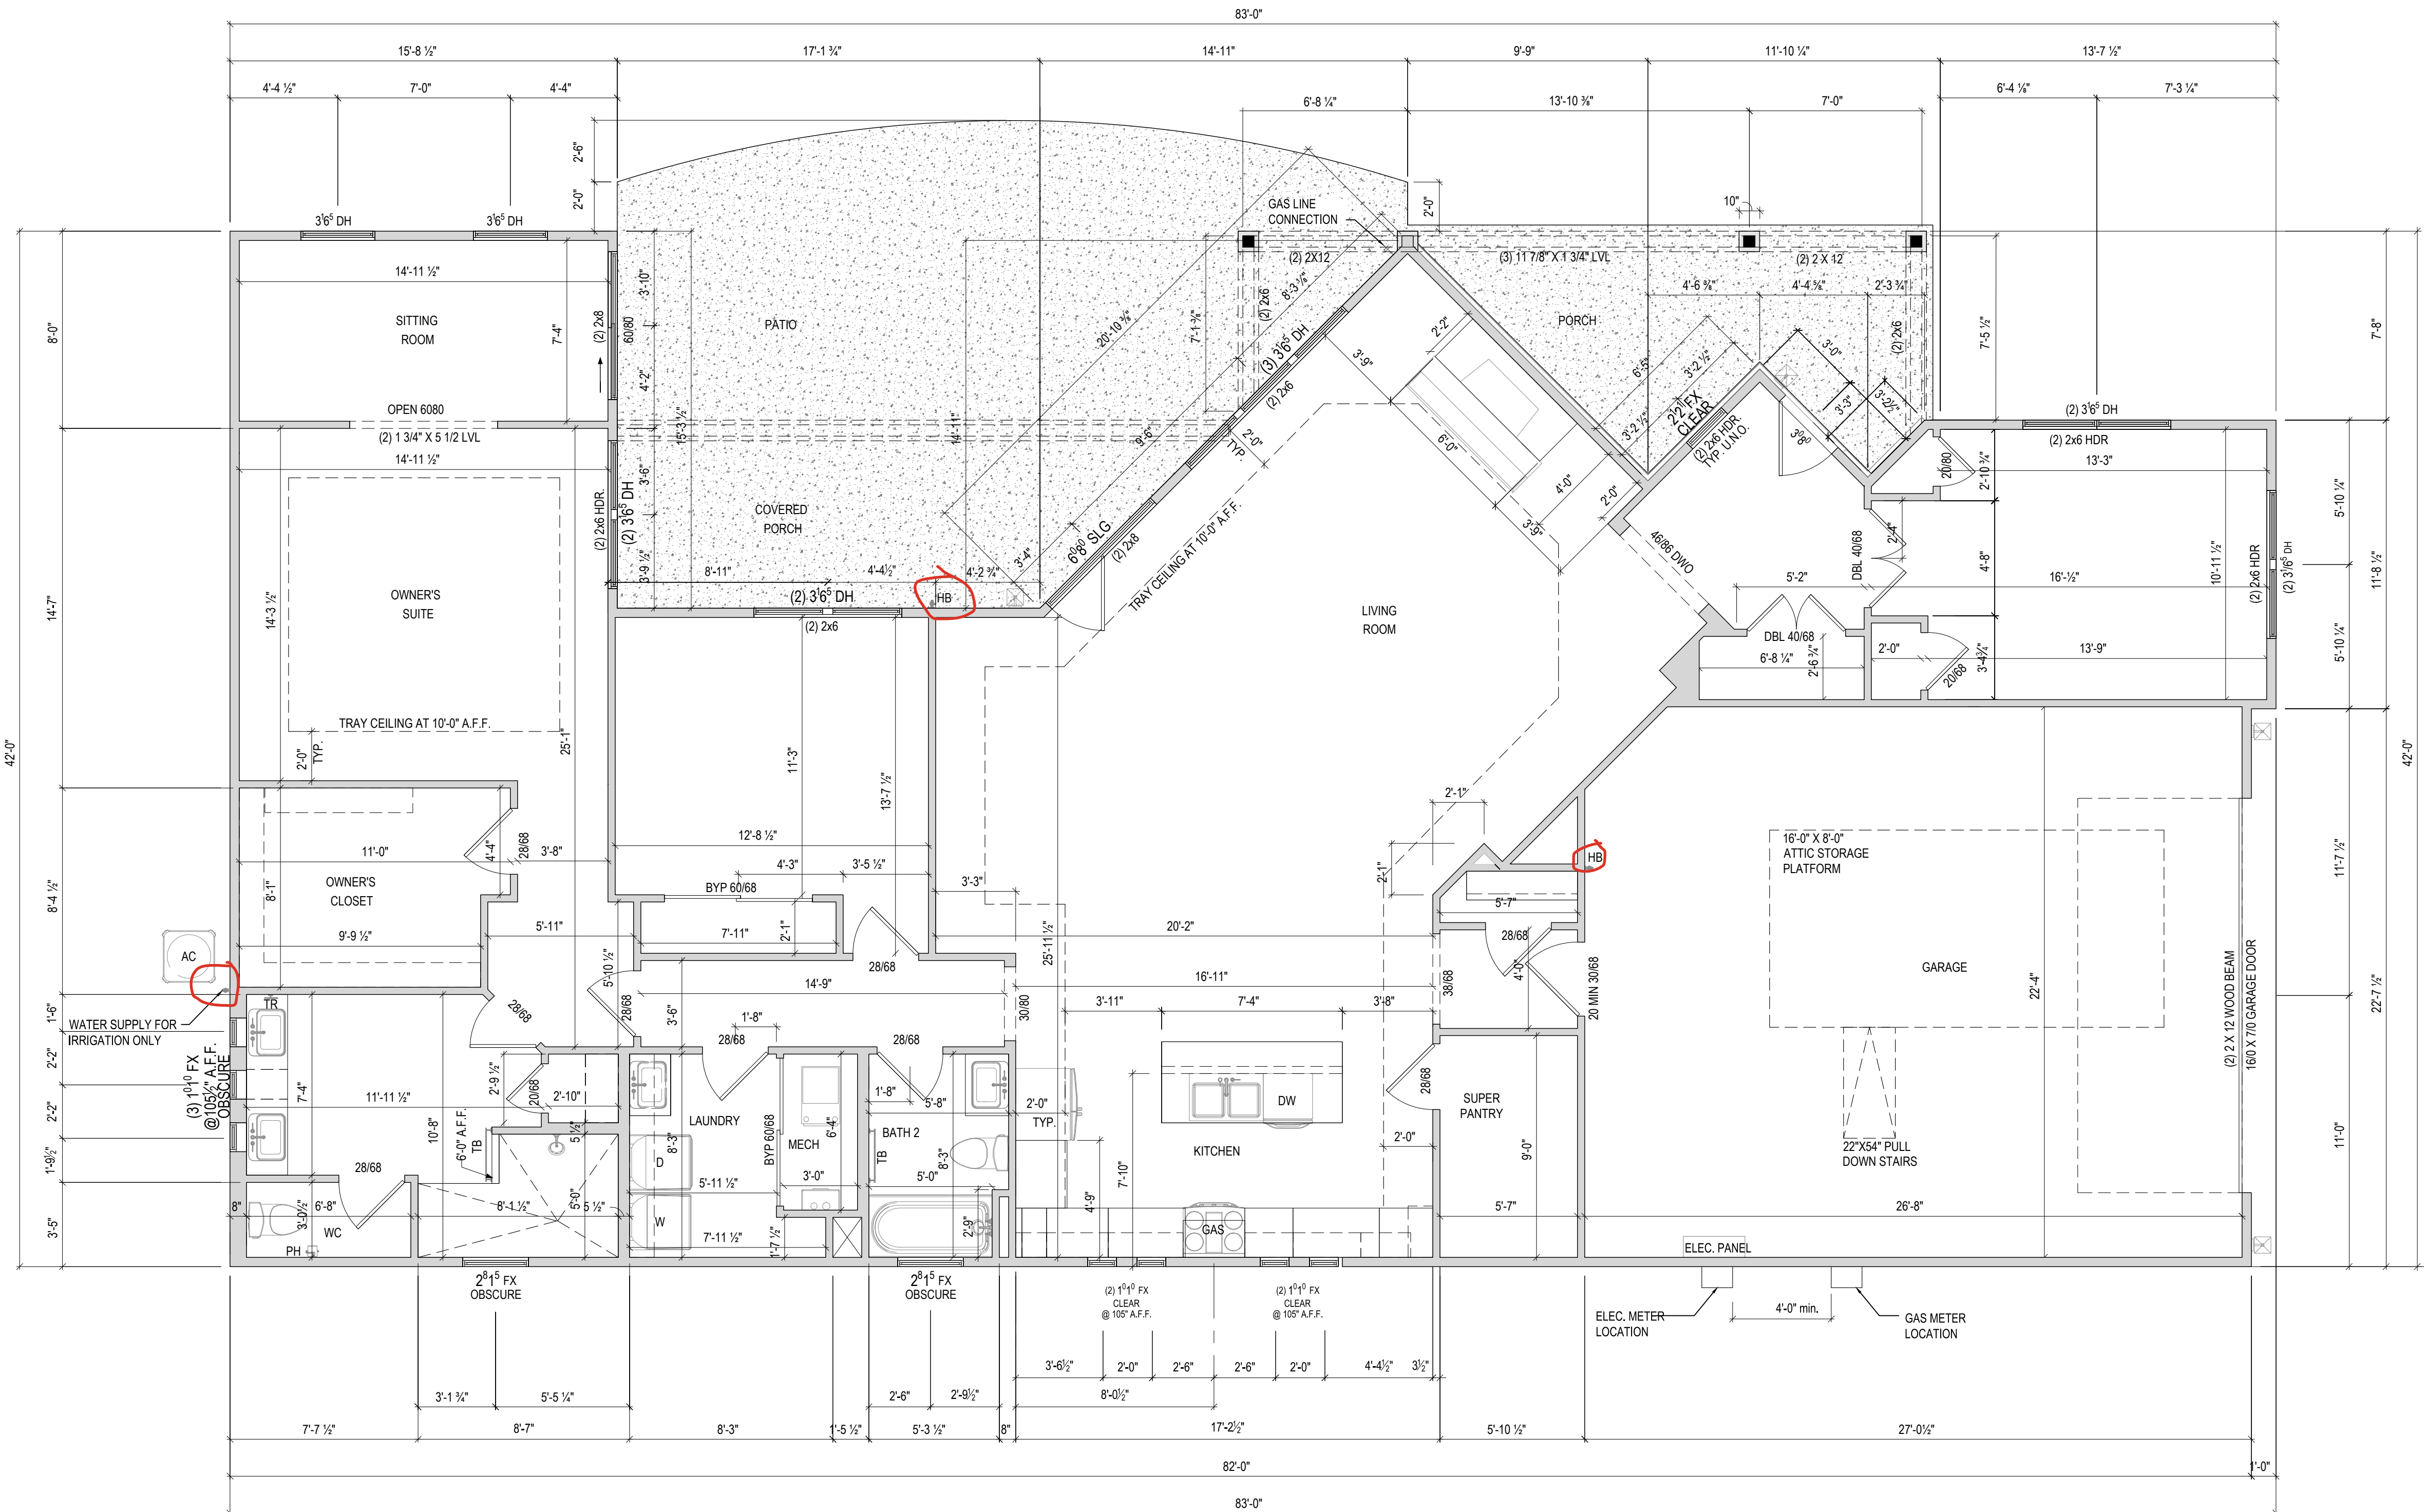


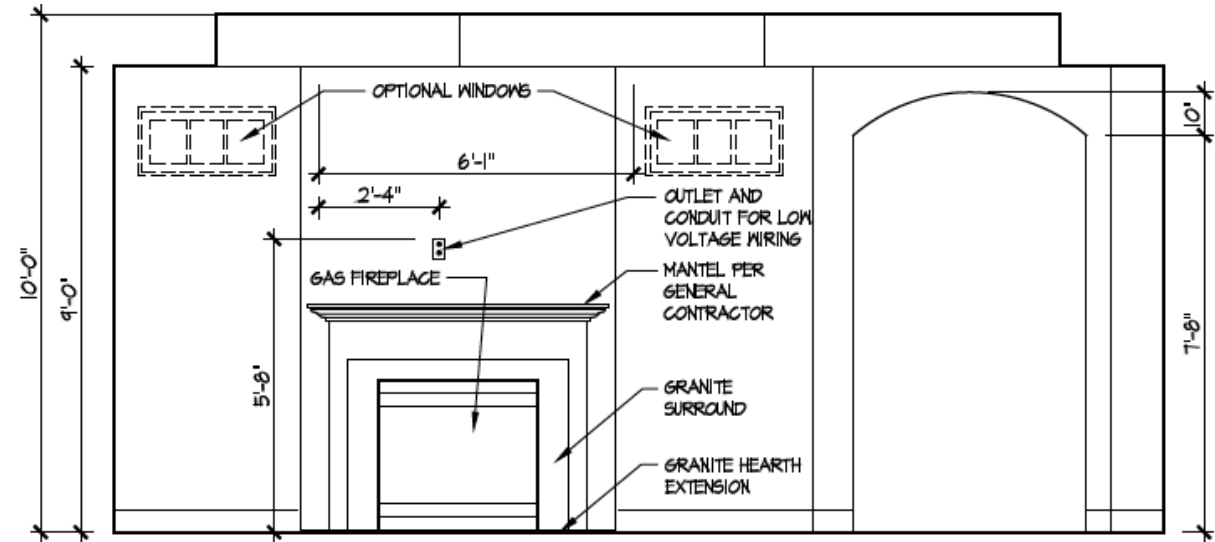


J Living Room Elevation
Scale: 3/8" = 1'-0"

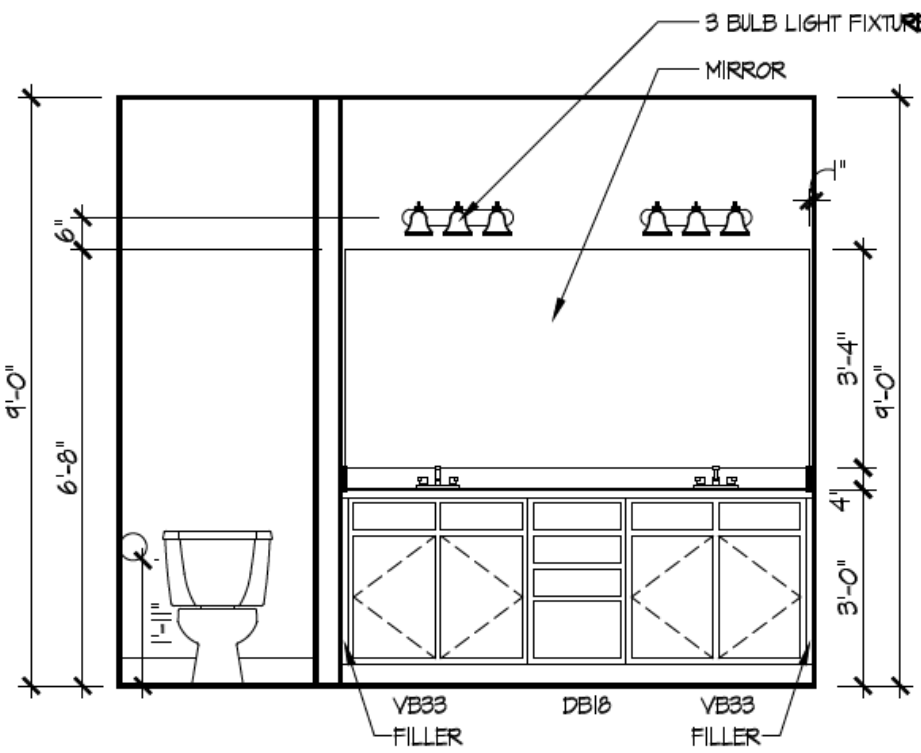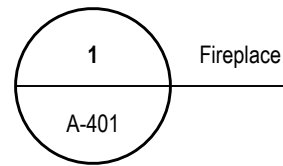


4 Master Bath Vanity
A-401

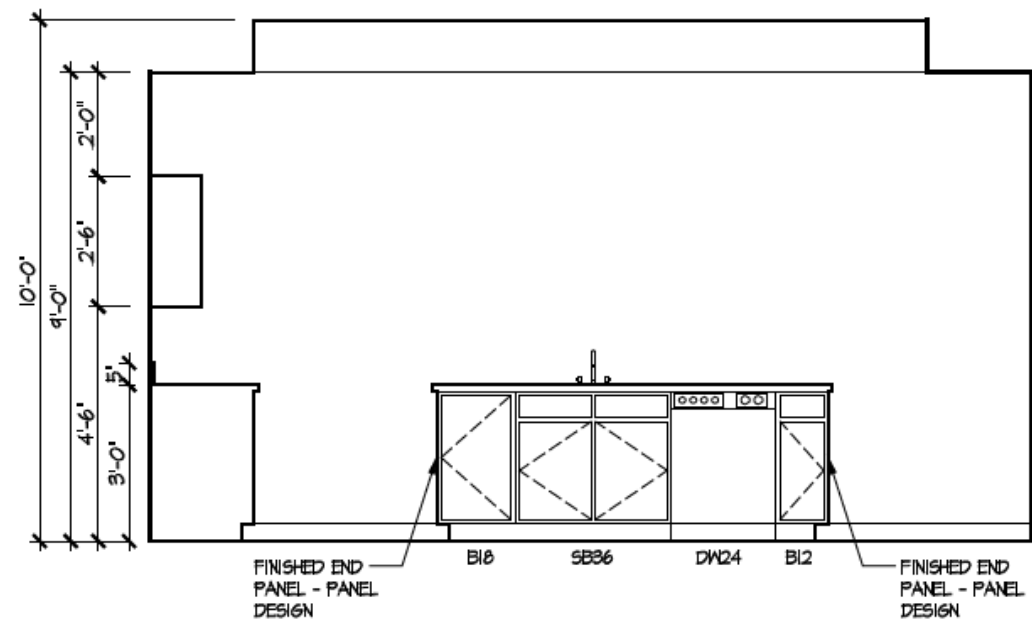



F Kitchen Elevation
Scale: 3/8" = 1'-0"

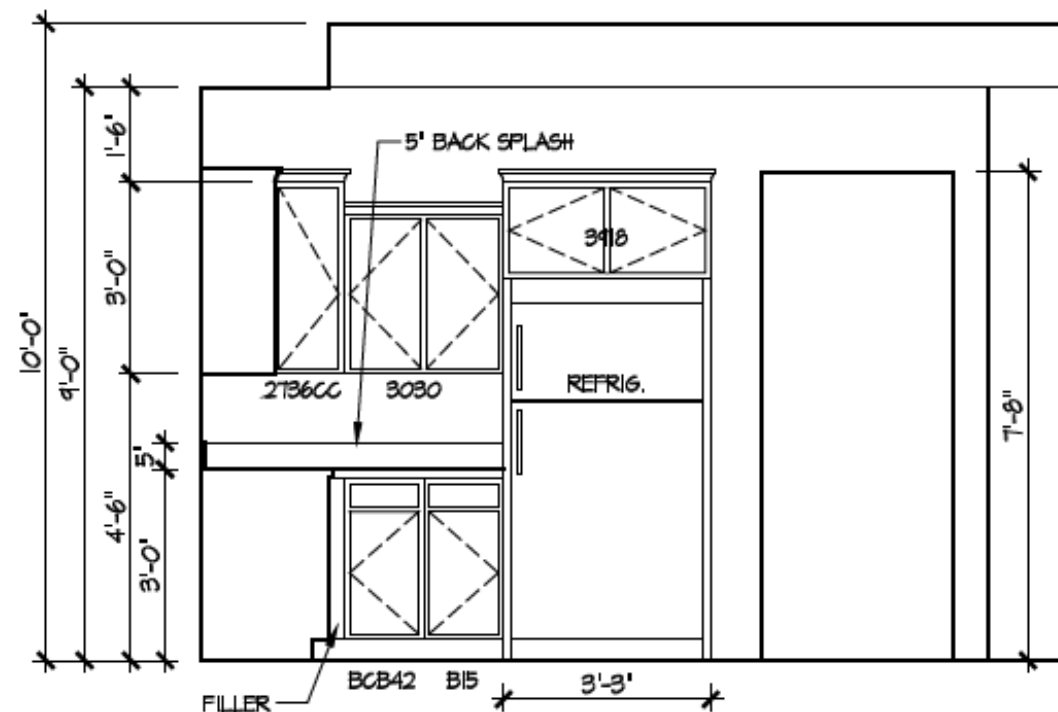

5 Kitchen Slagged Layout
A-401

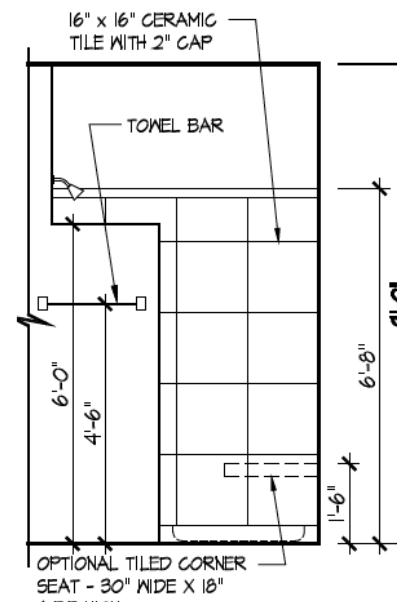

A Master Bath Option
Scale: 3/8" = 1'-0"

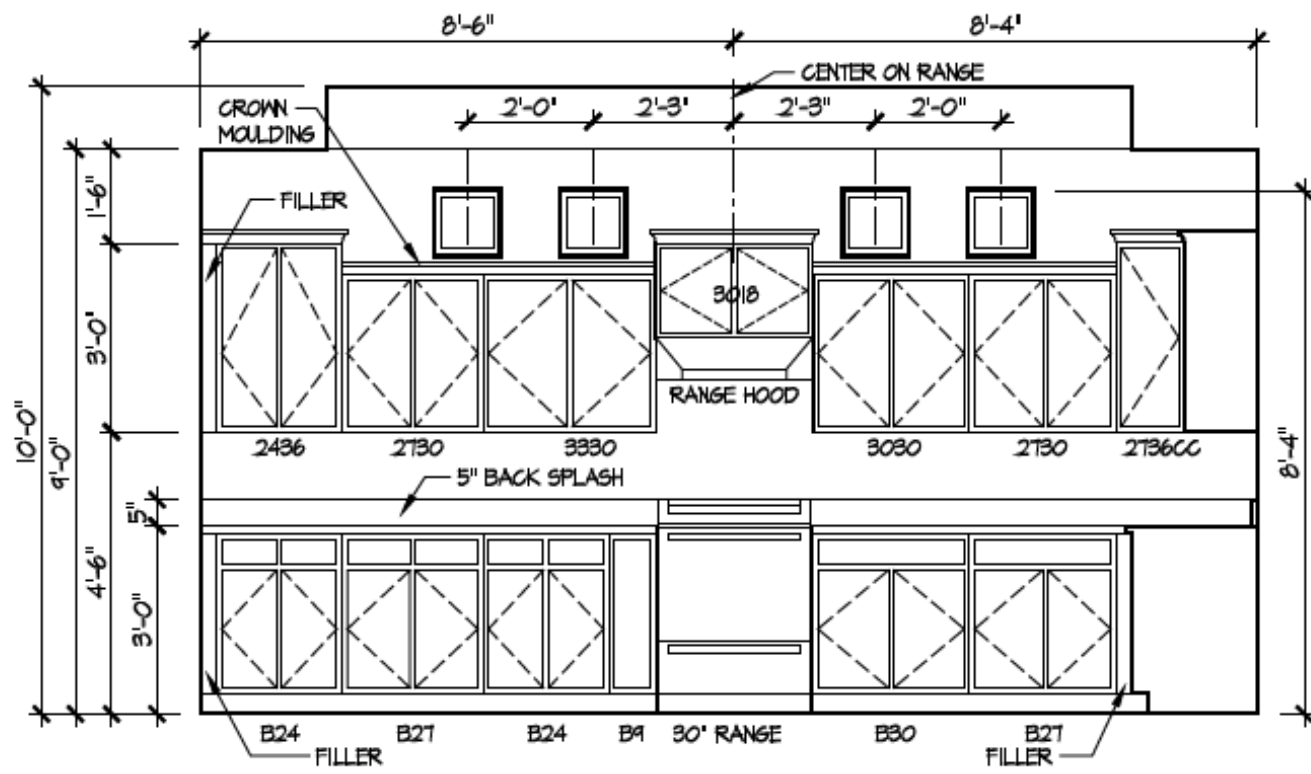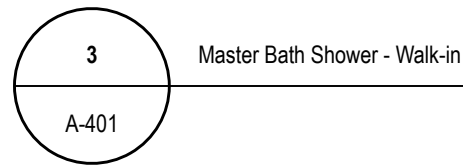

6 Kitchen Slagged Layout 2
A-401



Epcon Foundation DG

Bel Haven LLC
West Chester, OH.

Higharc, Inc. is not an architectural firm nor are the artistic representations contained herein intended to be construed as ready-to-use architectural plans, construction documents, drawings, renderings, or any other similar or related documents. All drawings are artists representations only and solely intended to reflect design intent derived exclusively from the home building plans and associated information, data, and specifications provided by Epcon Foundation DG. Higharc, Inc. is not responsible, nor may it be held liable for any errors or omissions contained herein or resulting from its usage. Any usage of the representations should be reviewed by local professionals to ensure conformance with local and state codes and be field verified prior to the start of any construction.

ISSUE	DESCRIPTION	DATE
01	BUILDER SET	9/25/2025

PROJECT
PLAN: BH Promenade D3
ELEV: Elev A - Front Gable
LOT: 172

DRAWING TITLE
DETAILS

SHEET NUMBER

A-401