



3  
A-6  
**PLUMBING PLAN**  
SCALE: 1/4" = 1'-0"  
SLAB FOUNDATION "PSA"

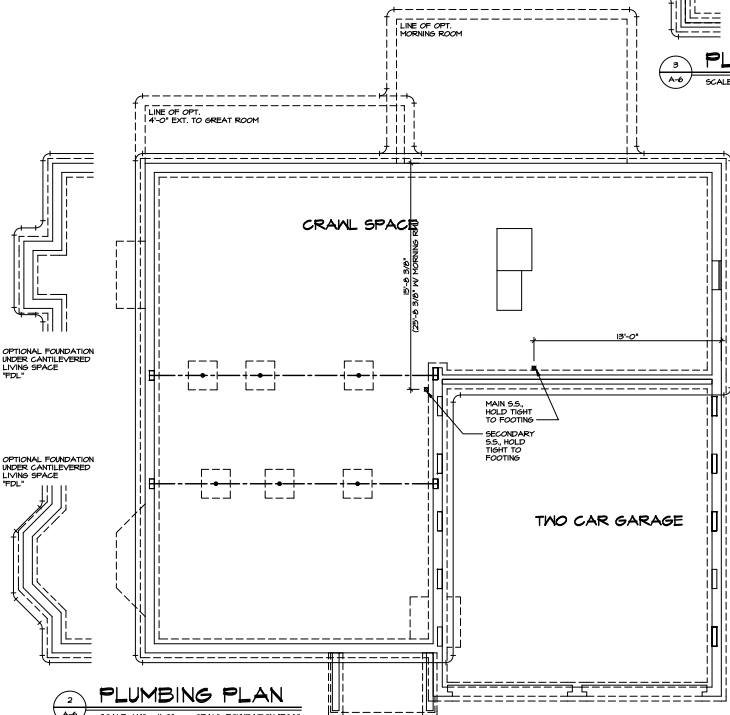







2  
A-6  
**PLUMBING PLAN**  
SCALE: 1/4" = 1'-0"  
CRAWL FOUNDATION "PCA"

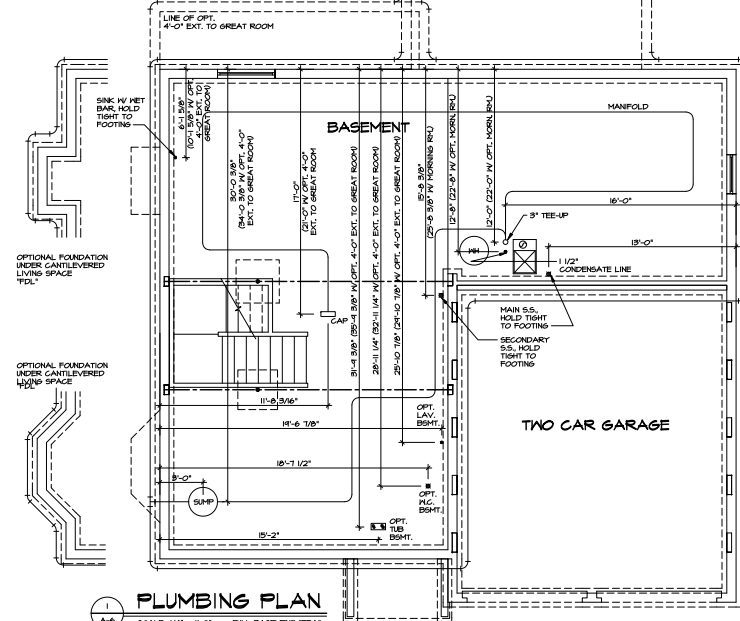

1  
A-6  
**PLUMBING PLAN**  
SCALE: 1/4" = 1'-0"  
FULL BASEMENT "FBA"

SHEET NO. <b>A-6</b>	MODEL <b>CHANTILLY PLACE</b>	SET NO. C/P/L/O <b>01</b>	DATE <b>7/28/11</b>	<b>REVISIONS</b> <table border="1"> <tr><th>REV. NO.</th><th>DATE</th><th>DESCRIPTION</th></tr> <tr><td>1</td><td>2/20/12</td><td>CRB - PROTOTYPE REVISIONS</td></tr> <tr><td>2</td><td>4/22/14</td><td>CRB - TIE CONNECTIONS</td></tr> <tr><td>3</td><td>5/14/14</td><td>CRB - SET LINE PROJECT</td></tr> </table>	REV. NO.	DATE	DESCRIPTION	1	2/20/12	CRB - PROTOTYPE REVISIONS	2	4/22/14	CRB - TIE CONNECTIONS	3	5/14/14	CRB - SET LINE PROJECT
	REV. NO.	DATE	DESCRIPTION													
	1	2/20/12	CRB - PROTOTYPE REVISIONS													
	2	4/22/14	CRB - TIE CONNECTIONS													
3	5/14/14	CRB - SET LINE PROJECT														
DRAWING TITLE <b>PLUMBING PLAN</b>	DESIGNED BY <b>CLS</b>	DATE <b>7/28/11</b>														
OPTION DESCRIPTION	DATE	OPTION														
<b>34</b>																

NVR, INC. 1000 W. WISCONSIN AVENUE, SUITE 4  
 FORT MILWAUKEE, WI 53152  
 WWW.NVR.COM  
 TEL: 414.224.2000  
 FAX: 414.224.2001

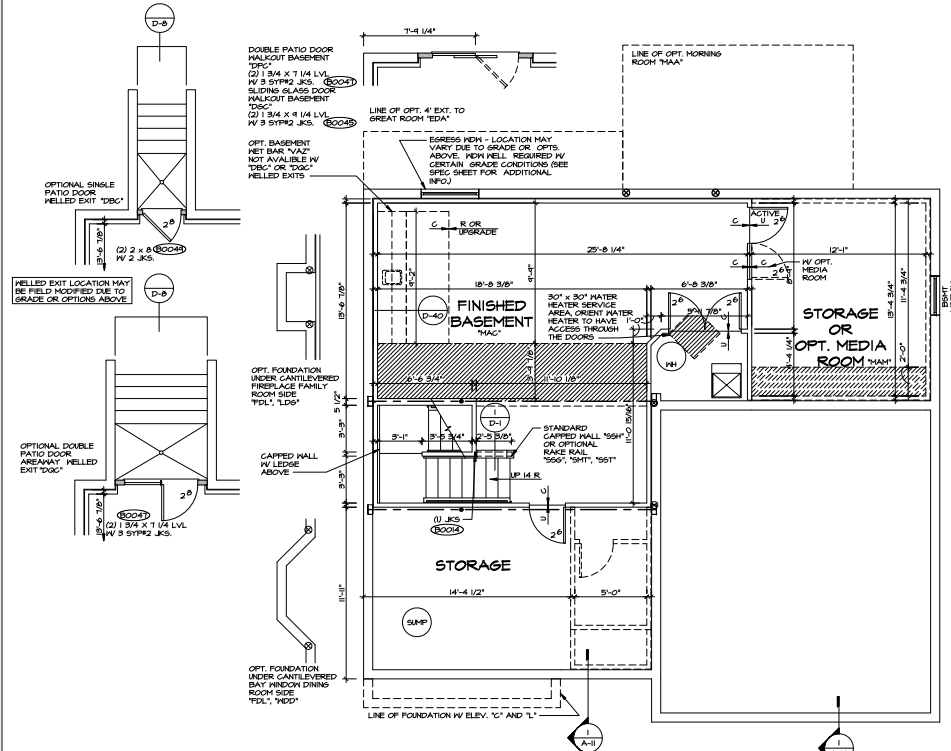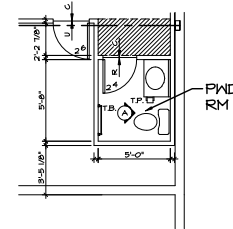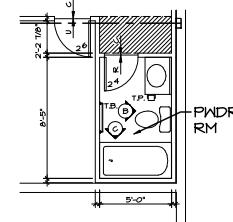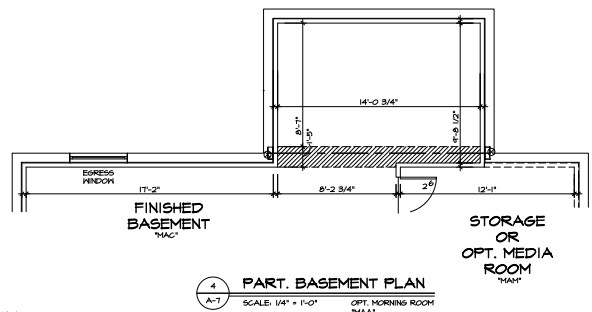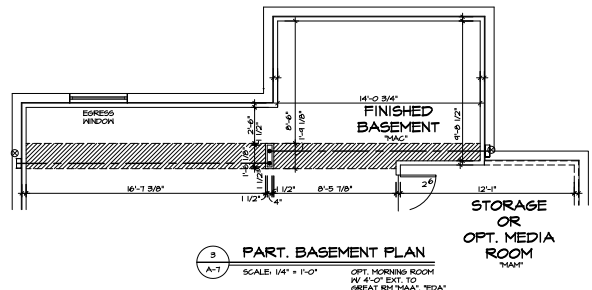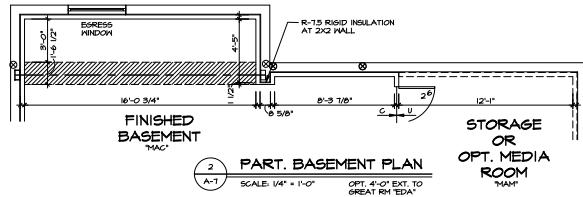

**STRUCTURAL NOTES:**

- ▬ BEARING WALL
- ▬ NON BEARING WALL
- X ENGINEERING PAGE NUMBER
- ⊙ INDICATES BEARINGS FROM POINT-LOAD ABOVE

1. ALL HEADERS ARE (2) 2x6 W/ 2x4 WALLS OR (3) 2x6 W/ 2x6 WALLS, UNLESS OTHERWISE NOTED.
2. ALL HEADERS TO HAVE (1) 2x4 OR 2x6 JACK EACH END, UNLESS OTHERWISE NOTED.
3. ALL EXTERIOR WALLS TO BE 4" AND ALL INTERIOR WALLS TO BE 3 1/2" (UNLESS OTHERWISE NOTED).
4. HATCHED AREAS INDICATE DROPPED CEILING.
5. SEE 'BRICKED HALL PANEL DETAIL SHEET' FOR SPECIAL HALL FRAMING LOCATIONS AND HEADER SIZES, IF APPLICABLE.

STRUCTURAL LEGEND	
▬	2x10 BLOCKING
▬	RIBBOARD BLOCKING
▬	2x6 BLOCKING (2x4 TYP.)
⊙	LAMINATED WOOD COLUMN
⊙	INDICATES BEARINGS FROM POINT-LOAD ABOVE
+	REINFORCEMENT ADDED AT POINT-LOADS FROM ABOVE OR PER ENGINEERING. QUANTITIES/GENS. VARIES PER DESIGN.


REV. NO.	DATE	REMARKS
1	2/2/22	CONTRACTOR REVISIONS
2	4/17/22	FIELD ADJUST
3	5/17/24	CONTRACTOR REVISIONS
4	5/24/24	CONTRACTOR REVISIONS
5	5/24/24	CONTRACTOR REVISIONS
6	5/24/24	CONTRACTOR REVISIONS



SET NO. C-100  
 DRAWING TITLE: BASEMENT FLOOR PLAN  
 DRAWN BY: CSD  
 DATE: 6/1/21  
 CHECKED BY: JEA  
 DATE: 6/1/21

SHEET NO. A-7  
 MODEL: CHANTILLY PLACE  
 DRAWING TITLE: BASEMENT FLOOR PLAN  
 OPTION DESCRIPTION: FULL BASEMENT FOUNDATION REAR MASONRY WALL  
 35

ALL RIGHTS RESERVED. NO PART OF THIS DRAWING IS TO BE REPRODUCED OR TRANSMITTED IN ANY FORM OR BY ANY MEANS, ELECTRONIC OR MECHANICAL, WITHOUT PERMISSION IN WRITING FROM NVR, INC.

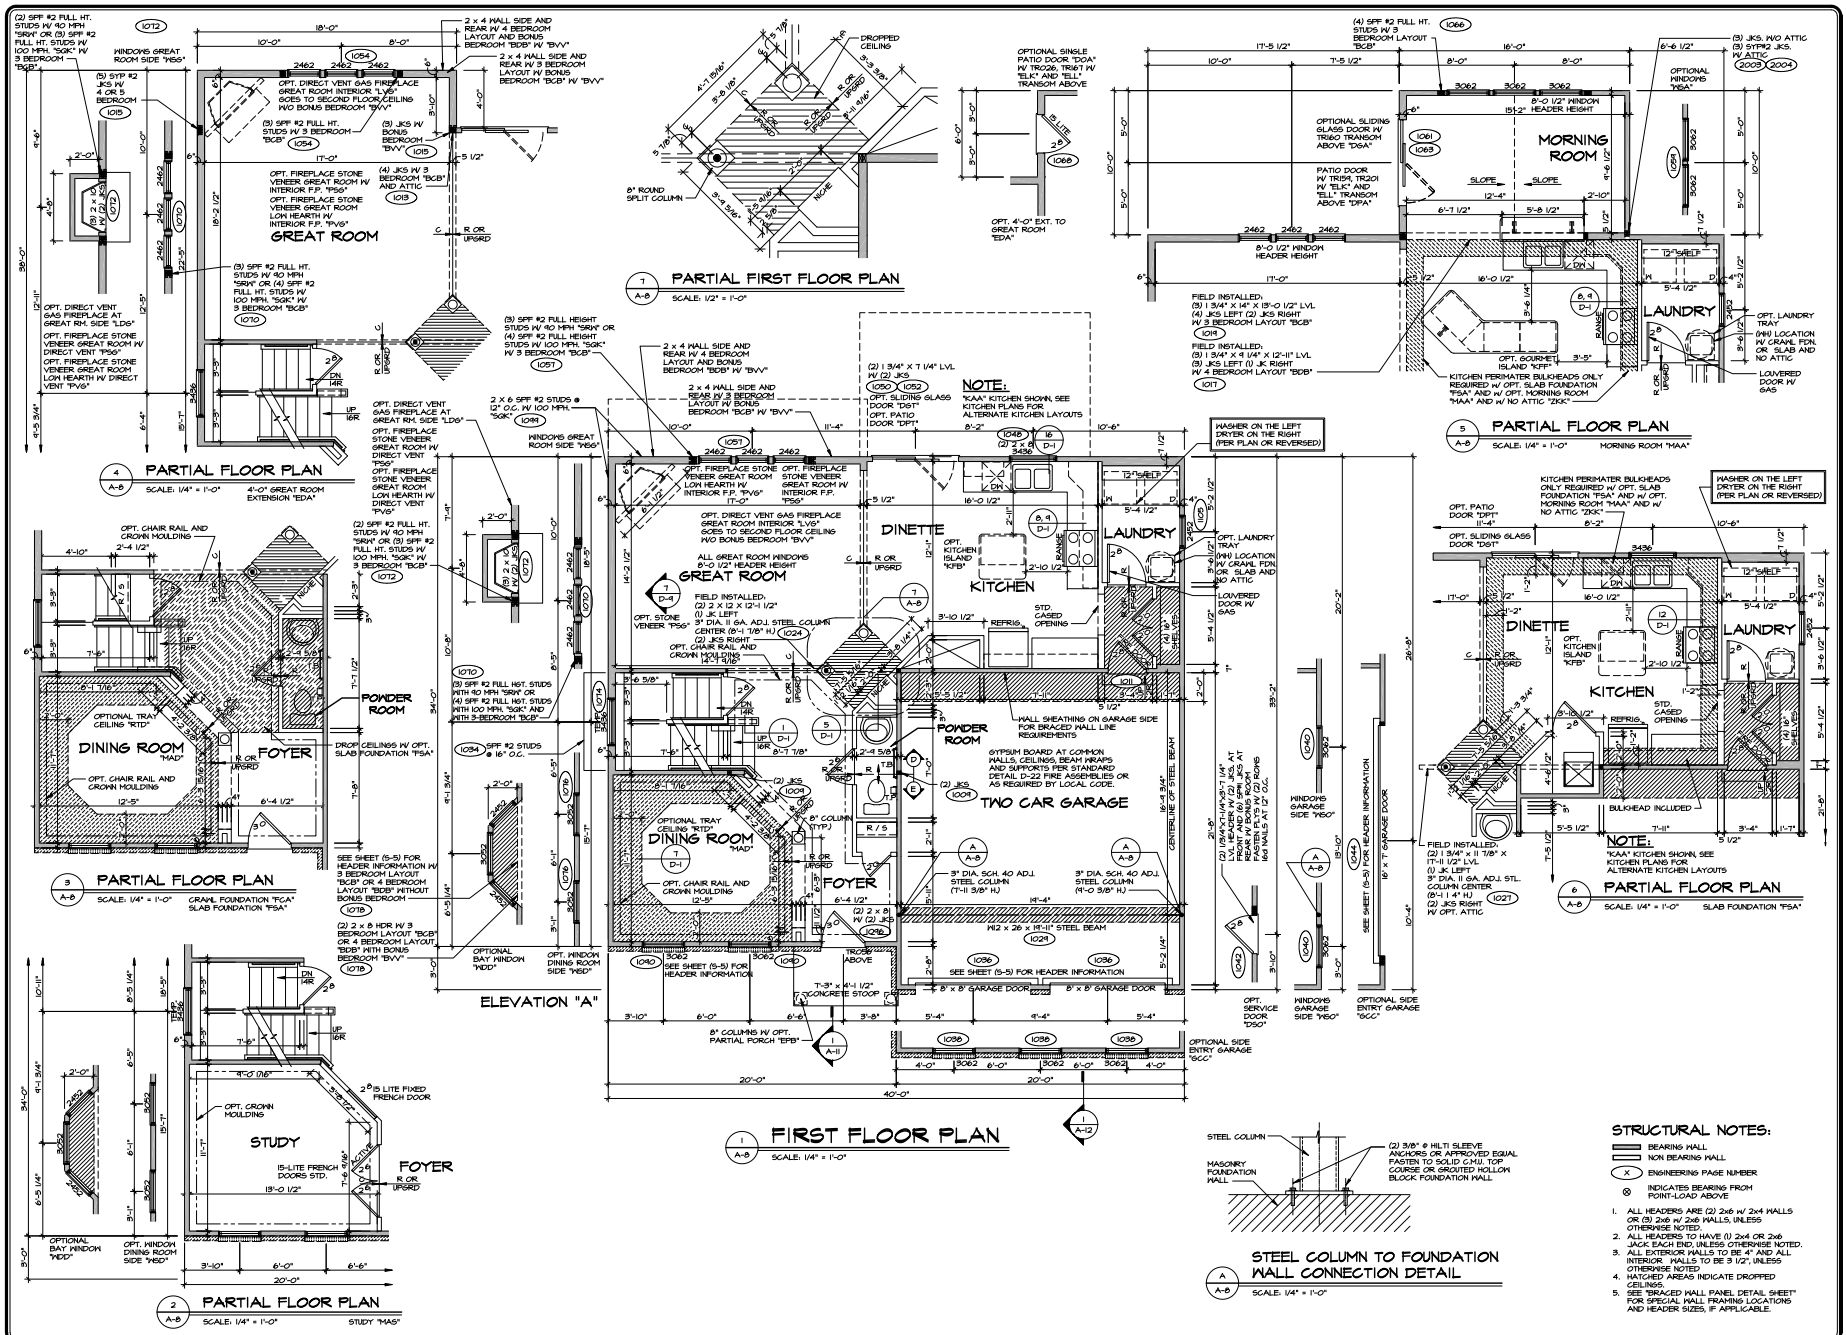

REV.	NO.	DATE	DESCRIPTION
1	01	6/14/11	ISSUE FOR PERMITS
2	02	6/14/11	REVISIONS TO PERMIT REQUIREMENTS
3	03	6/14/11	REVISIONS TO PERMIT REQUIREMENTS
4	04	6/14/11	REVISIONS TO PERMIT REQUIREMENTS
5	05	6/14/11	REVISIONS TO PERMIT REQUIREMENTS
6	06	6/14/11	REVISIONS TO PERMIT REQUIREMENTS
7	07	6/14/11	REVISIONS TO PERMIT REQUIREMENTS
8	08	6/14/11	REVISIONS TO PERMIT REQUIREMENTS
9	09	6/14/11	REVISIONS TO PERMIT REQUIREMENTS
10	10	6/14/11	REVISIONS TO PERMIT REQUIREMENTS


SET NO. C-1000  
 DRAWING TITLE: FIRST FLOOR PLAN  
 DRAWN BY: CSD  
 DATE: 6/14/11  
 CHECKED BY: JLD  
 DATE: 6/14/11  
 PROJECT NO.: 1026743-1

**NVR**  
 NATIONAL VERIFICATION REPORT  
 1100 N. 1st Street  
 Tallahassee, FL 32302  
 TEL: 904.438.1100  
 FAX: 904.438.1101  
 WWW.NVR.COM


SHEET NO. **A-8**  
 TOTAL SHEETS: 37

**STRUCTURAL NOTES:**


- BEARING WALL
  - NON BEARING WALL
  - ENGINEERING PAGE NUMBER
  - INDICATES BEARING FROM POINT-LOAD ABOVE
1. ALL HEADERS ARE (2) 2x6 W/ 2x4 WALLS OR (2) 2x6 W/ 2x6 WALLS UNLESS OTHERWISE NOTED.
  2. ALL HEADERS TO HAVE (1) 2x4 OR 2x6 JACK EACH END UNLESS OTHERWISE NOTED.
  3. ALL EXTERIOR WALLS TO BE 4" AND ALL INTERIOR WALLS TO BE 9 1/2", UNLESS OTHERWISE NOTED.
  4. HATCHED AREAS INDICATE DROPPED CEILING.
  5. SEE BRACED HALL PANEL DETAIL SHEET FOR SPECIAL HALL FRAMING LOCATIONS AND HEADER SIZES, IF APPLICABLE.

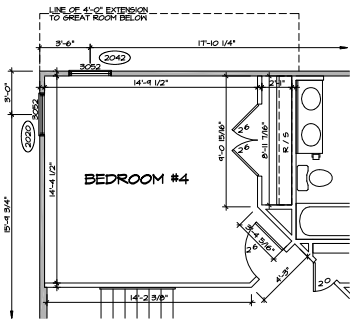


**6 PARTIAL FLOOR PLAN**  
SCALE: 1/4" = 1'-0" BONUS BEDROOM "BV"

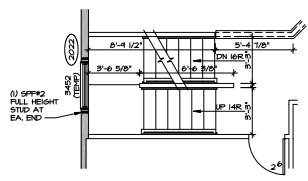


**5 PARTIAL FLOOR PLAN**  
SCALE: 1/4" = 1'-0" W/ FINISHED ATTIC "MAP" OR ATTIC BEDROOM "BTP"

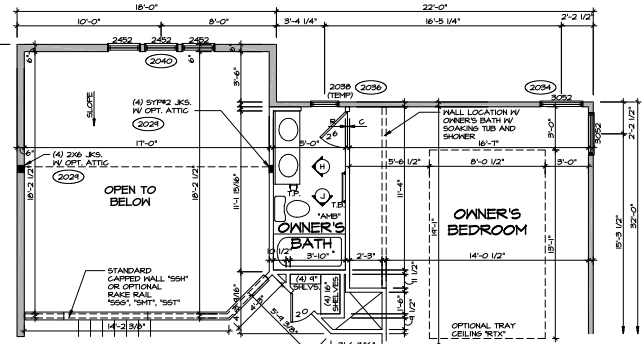


**1 PARTIAL FLOOR PLAN**  
SCALE: 1/4" = 1'-0" 4'-0" EXT. TO GREAT ROOM "EDA"

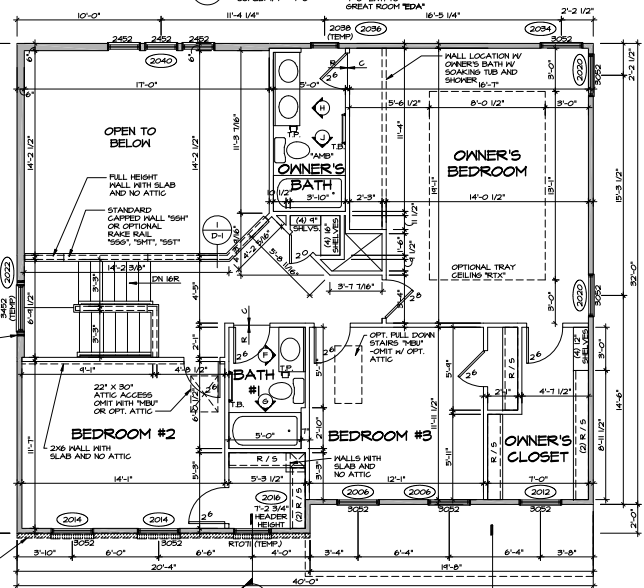


**1 SECOND FLOOR PLAN**  
SCALE: 1/4" = 1'-0"

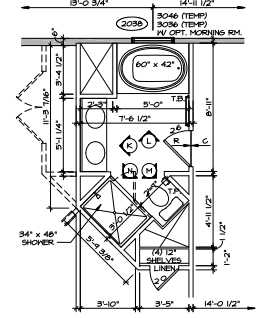


**2 PARTIAL FLOOR PLAN**  
SCALE: 1/4" = 1'-0" OWNER'S BATH W/ SOAKING TUB AND SHOWER "AMB"

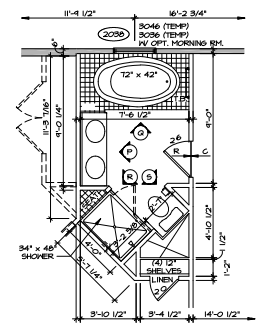


**4 PARTIAL FLOOR PLAN**  
SCALE: 1/4" = 1'-0" OWNER'S BATH W/ SOAKING TUB AND SHOWER "AMB"

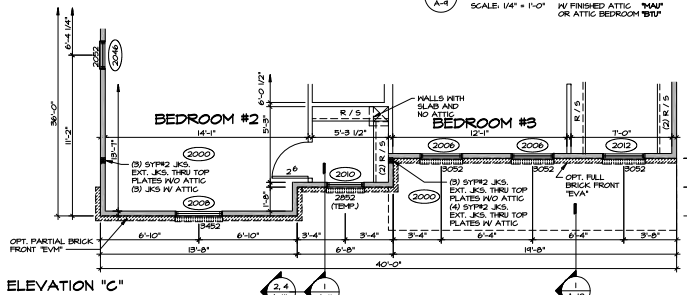

**ELEVATION "C"**

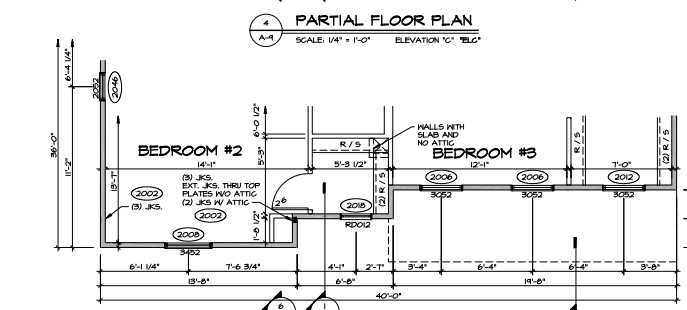

**ELEVATION "L"**

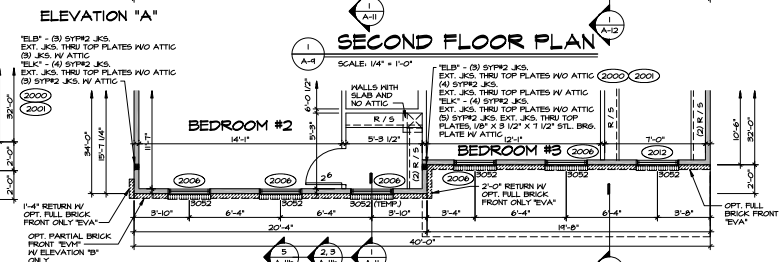

**ELEVATIONS "B" AND "K"**



**2 PARTIAL FLOOR PLAN**  
SCALE: 1/4" = 1'-0" ELEVATION "B" "ELB" ELEVATION "K" "ELK"

REV.	NO.	DATE	DESCRIPTION
1	1	10/24/24	ISSUED FOR PERMIT
2	2	11/15/24	REVISIONS TO PERMIT
3	3	12/10/24	REVISIONS TO PERMIT
4	4	1/10/25	REVISIONS TO PERMIT
5	5	2/10/25	REVISIONS TO PERMIT
6	6	3/10/25	REVISIONS TO PERMIT
7	7	4/10/25	REVISIONS TO PERMIT
8	8	5/10/25	REVISIONS TO PERMIT
9	9	6/10/25	REVISIONS TO PERMIT
10	10	7/10/25	REVISIONS TO PERMIT
11	11	8/10/25	REVISIONS TO PERMIT
12	12	9/10/25	REVISIONS TO PERMIT

SET NO.	CP-100
VERSION	01
DRAWN BY	CSB
DATE	6/1/21
OFFICE	ECB
PROJECT	THREE BEDROOM LAYOUT
SHEET NO.	A-9
TOTAL SHEETS	41







