
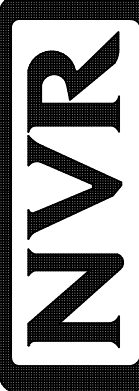


PLUMBING PLAN
 SCALE: 1/4" = 1'-0"


SHEET NO. A-5	MODEL AVIANO	SET NO. A/A00	REMARKS
	DRAWING TITLE PLUMBING PLAN	VERSION 01	
26	OPTION DESCRIPTION	DRAWN BY	REV. NO. DATE
		DATE:	
 NVR, Inc. Architectural Services Architects 5285 Westpark Drive, Suite 100 Frederick, MD 21703		NVR, Inc., owner, expressly reserves its copyright in these plans. These plans are not to be reproduced, changed, copied, or otherwise used in any way without the prior written consent of NVR, Inc.	
C:\NVR\Solves\AVIANO_AIA00_01\DCY-CH-S38\113437A\Sheets\Lot_Specific\26_A-5_PLUMB_LS.dwg - 02/28/19 - 8:55 am			

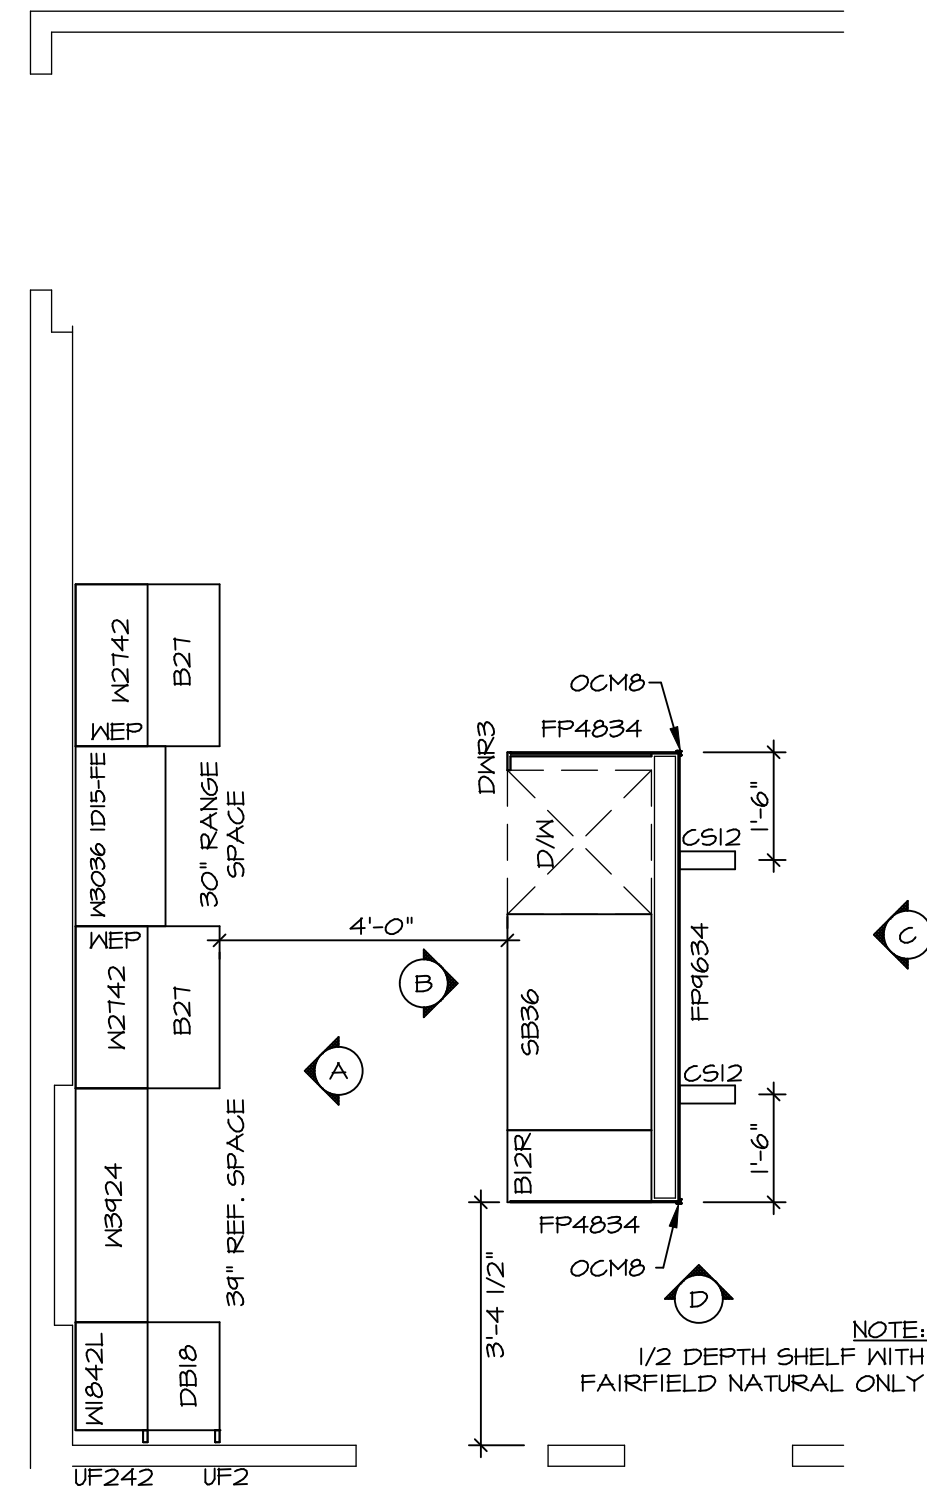

**KITCHEN CABINET
PLAN / KC-343I**

SCALE: 3/8" = 1'-0"


1
A-II

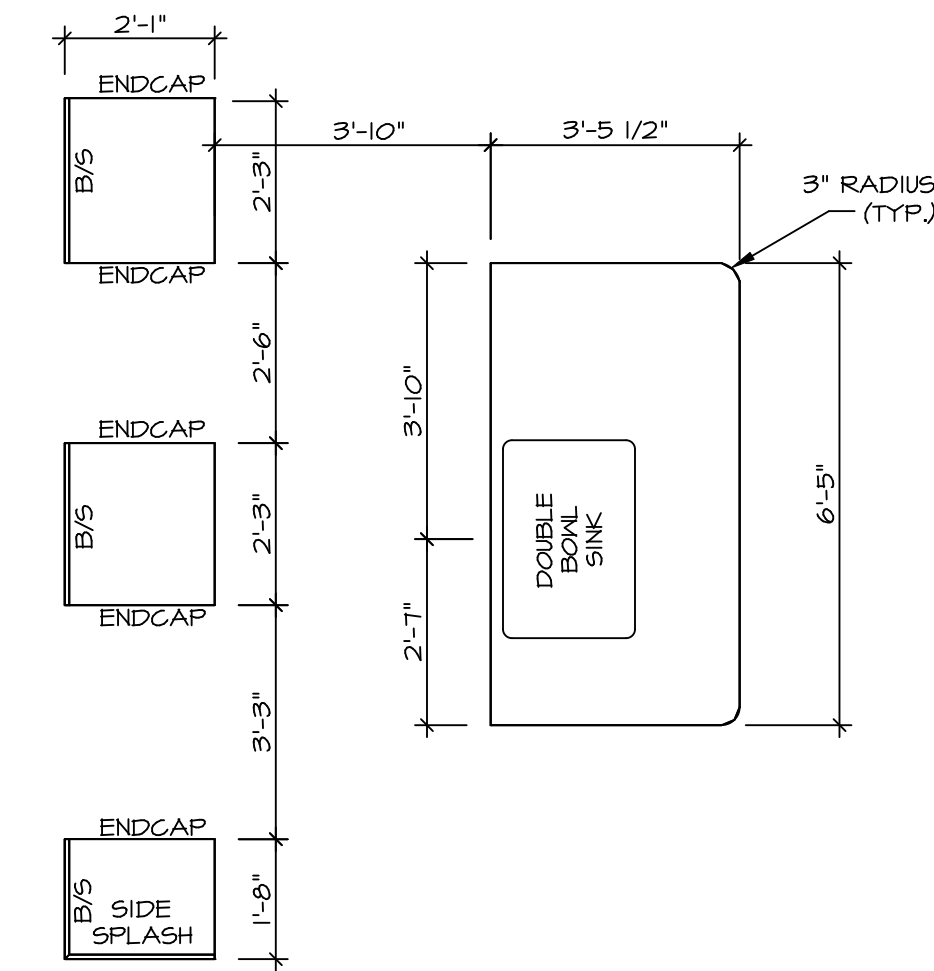

**KITCHEN COUNTERTOP
PLAN / KC-343I**

SCALE: 3/8" = 1'-0"


2
A-II

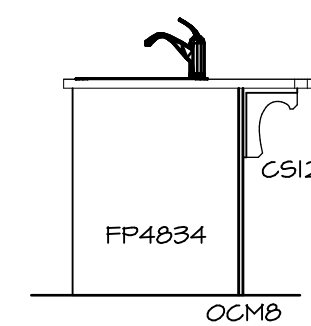

KITCHEN ELEVATION

SCALE: 3/8" = 1'-0"


D

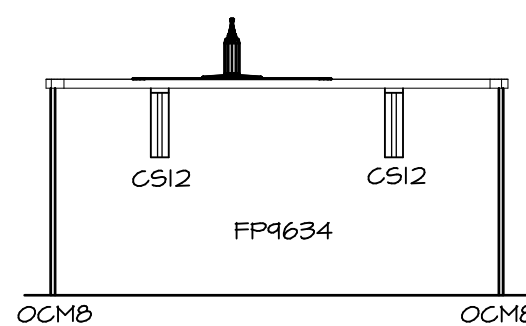

KITCHEN ELEVATION

SCALE: 3/8" = 1'-0"


C

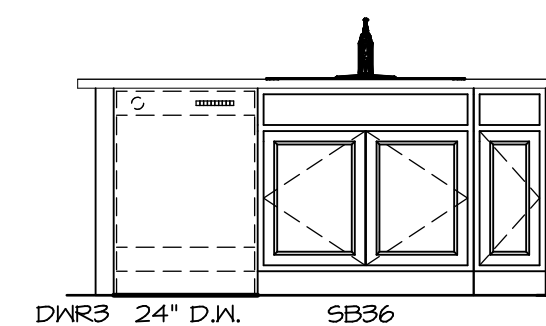

KITCHEN ELEVATION

SCALE: 3/8" = 1'-0"

B

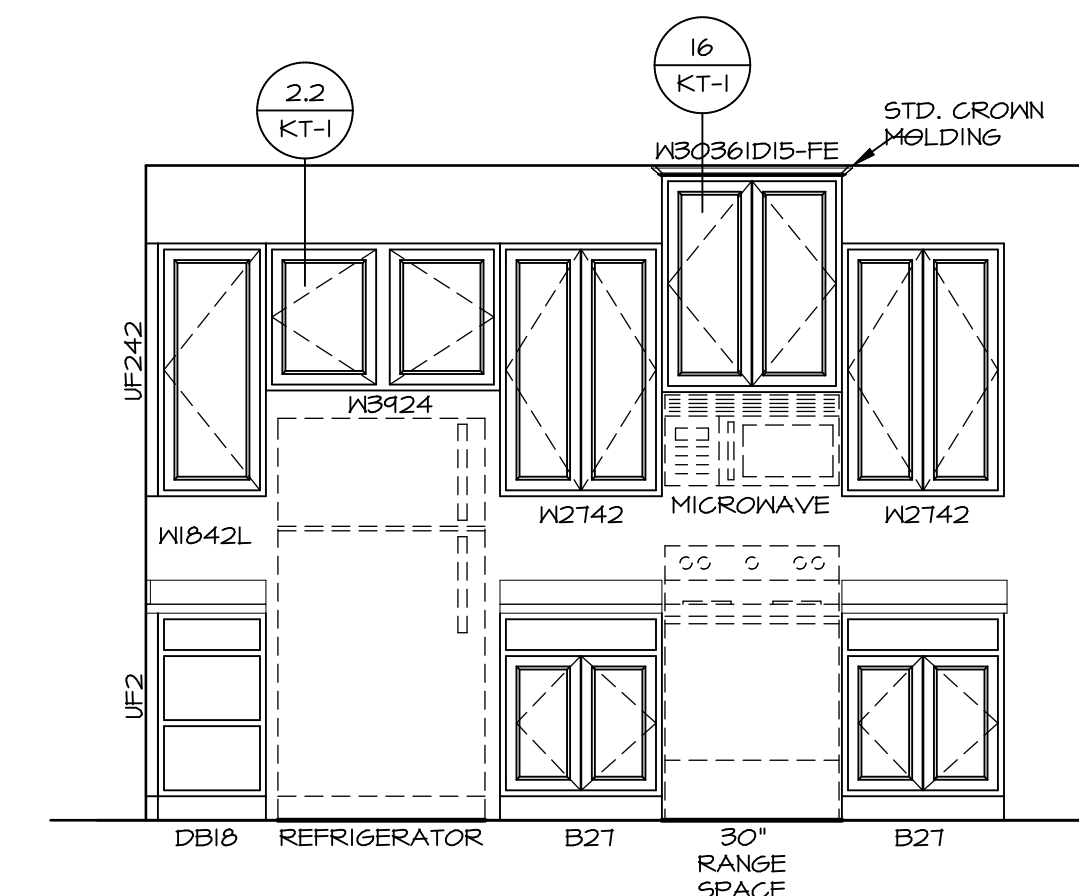

KITCHEN ELEVATION

SCALE: 3/8" = 1'-0"

A

3
A-II

KITCHEN ELEVATIONS

SCALE: 1/4" = 1'-0"

SHEET NO. A-11	MODEL AVIANO	SET NO. A/A00	OPTION 38	REMARKS
	DRAWING TITLE KITCHEN LAYOUT	VERSION 01		
OPTION DESCRIPTION		DRAWN BY RJC	<p>NVR, Inc., owner, expressly reserves its copyright in these plans. These plans are not to be reproduced, changed, copied in any way, or otherwise used without the written consent of NVR, Inc.</p> <p>NVR, Inc. Architectural Services Architects 5285 Westpark Drive, Suite 100 Frederick, MD 21703</p>	

