


**PLUMBING PLAN**  
SCALE: 1/4" = 1'-0"

SHEET NO. <b>A-5</b>	MODEL <b>GRAND BAHAMA</b>	SET NO. 6EH00
	DRAWING TITLE <b>PLUMBING PLAN</b>	VERSION 01
	OPTION DESCRIPTION	DRAWN BY
		DATE:
		OPTION

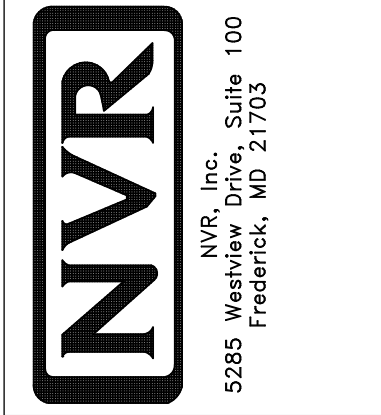

© NVR, Inc. expressly reserves the right to modify or amend these plans at any time without notice. These plans are not to be reproduced, changed or altered in any way without the written consent of NVR, Inc.

DIV-COMM-LOT-UNIT  
**DCY-S3-0169**

COMM-LOT  
5AMTYS MILL - LIFESTYLE - 0169


STREET ADDRESS  
5681 WOODCREEK DRIVE

CITY  
MIDDLETOWN

STATE  
OH

ZIP  
45042

APPT. NO. ----	STATE OH	ZIP 45042
-------------------	-------------	--------------

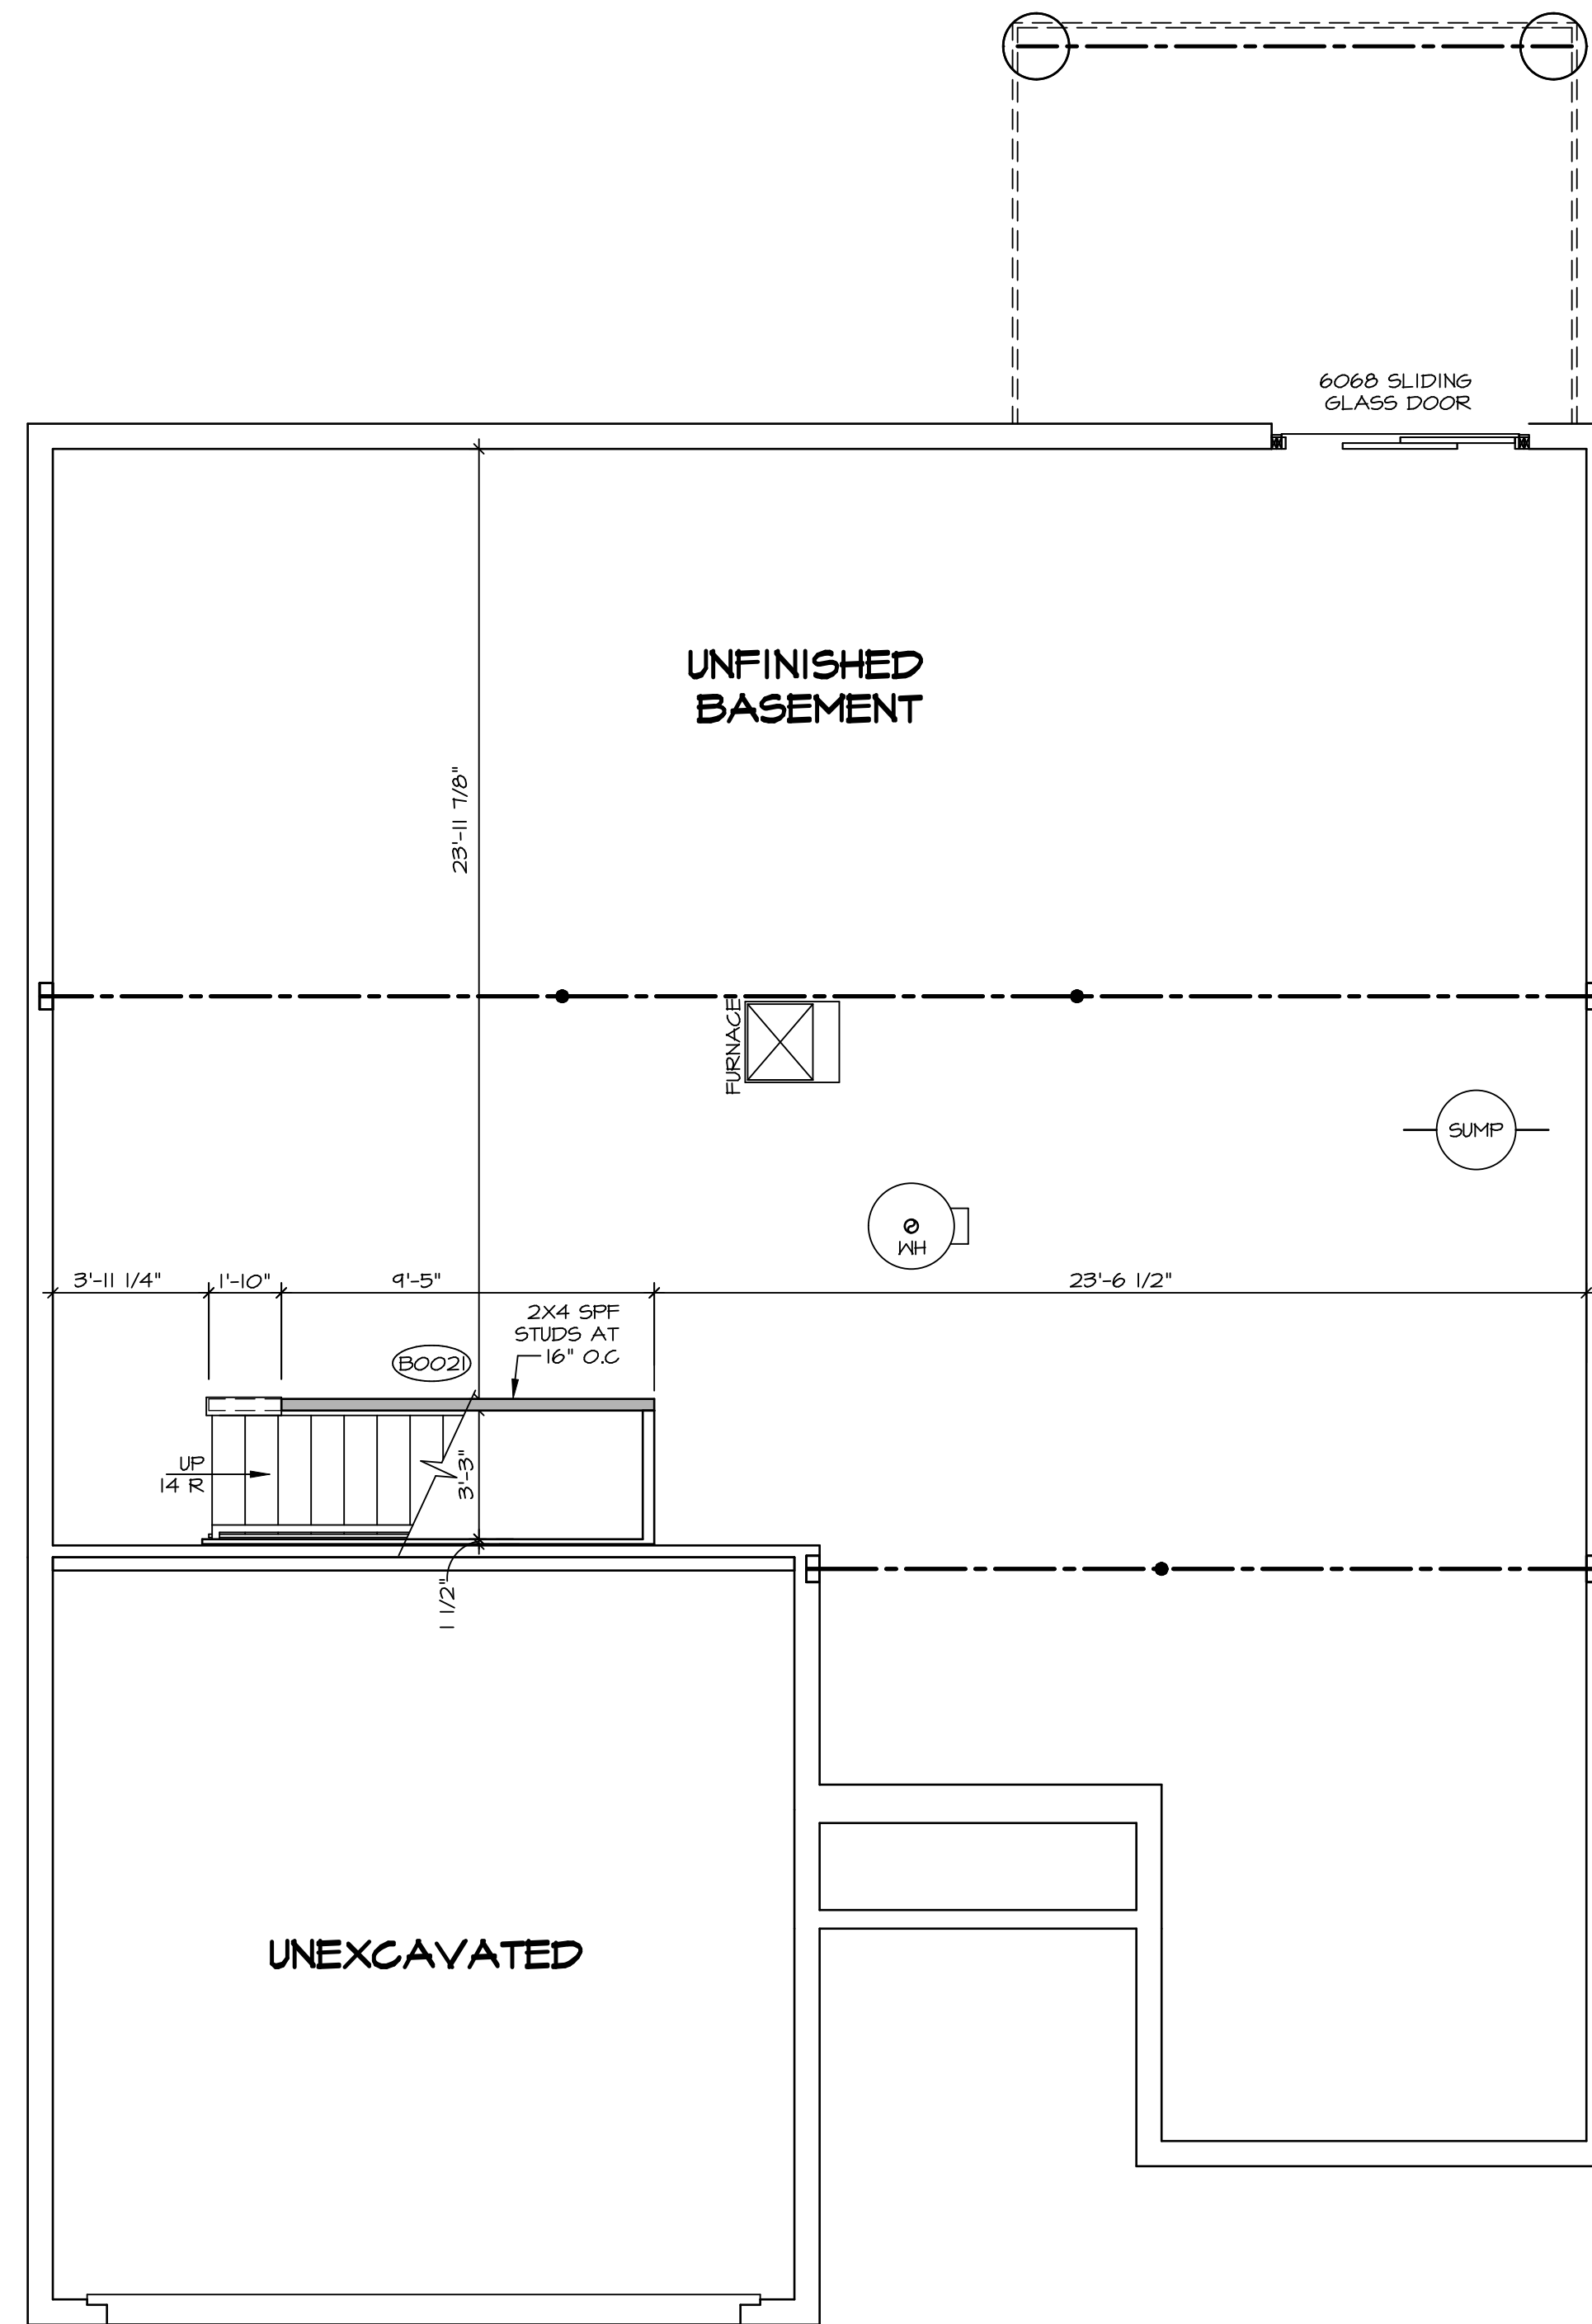

**LEGEND**

	BEARING WALL
	NON BEARING WALL
	INDICATES BEARING FROM POINT-LOAD ABOVE
	JACKS
	BEAM-HEADER
	PAD FOOTING
	STEEL COLUMN
	TRUSS TIE DOWN
	PORTAL FRAME
	JOIST/TRUSS
	LVL
	ENGINEERING PAGE NUMBER

SEE FC DETAILS FOR FRAMING CONNECTORS

- FLOOR PLAN NOTES**
- ALL HEADERS ARE (2) 2x6 w/ 2x4 WALLS OR (3) 2x6 w/ 2x6 WALLS, UNLESS OTHERWISE NOTED.
  - ALL HEADERS TO HAVE (1) 2x4 OR 2x6 JACK AND KING STUD EACH END, UNLESS OTHERWISE NOTED. MULTI-OPENING HEADERS TO HAVE (2) JACKS AT INTERMEDIATE BEARING, UNLESS OTHERWISE NOTED. NO ADDITIONAL FLOOR SYSTEM BLOCKING OR CONTINUOUS LOAD PATH JACKS ARE REQUIRED UNLESS OTHERWISE NOTED.
  - ALL EXTERIOR WALLS TO BE 4" w/ OSB OR 3 1/2" w/ LAMINATED FIBROUS STRUCTURAL SHEATHING, ALL INTERIOR WALLS TO BE 3 1/2", UNLESS OTHERWISE NOTED. HATCHED AREAS INDICATE DROPPED CEILINGS. ALL DROPPED CEILINGS ARE 12" UNLESS OTHERWISE NOTED.
  - SEE "BRACED WALL PANEL DETAIL SHEET" FOR SPECIAL WALL FRAMING LOCATIONS AND HEADER SIZES, IF APPLICABLE.
  - SEE STANDARD DETAIL CATEGORY "1T" SHEET(S) FOR INTERIOR TRIM DETAILS.
  - SEE ARCHITECTURAL DETAIL SHEET "AD" FOR HOUSE WRAPS AND SUPPORTS PER STANDARD DETAIL FA-1(b) FIRE ASSEMBLIES OR AS REQUIRED BY LOCAL CODE.
  - ALL HEADERS IN NON-BEARING WALLS SHALL BE A SINGLE FLAT 2x4 OR 2x6 ATTACHED TO CRIPPLES ABOVE, UNLESS OTHERWISE NOTED.
  - TANKED WATER HEATER SHOWN AS BASE CONDITION. OPTIONAL TANKLESS WATER HEATER IS AVAILABLE IN LIEU OF TANKED WATER HEATER.

**GYPSUM NOTES**

AT GARAGE:  
GYPSUM BOARD AT COMMON WALLS, CEILINGS, BEAM WRAPS AND SUPPORTS PER STANDARD DETAIL FA-1(b) FIRE ASSEMBLIES OR AS REQUIRED BY LOCAL CODE.

AT STAIRS:  
1/2" GYPSUM BOARD AT UNDERSIDE OF STAIRS AND WALLS IN CLOSET

**BASEMENT FLOOR PLAN**  
SCALE: 1/4" = 1'-0"

SHEET NO. <b>A-6</b>	MODEL <b>GRAND BAHAMA</b>	SET NO. <b>GBH00</b>	VERSION <b>01</b>
		DRAWN BY	DATE:
DRAWING TITLE <b>BASEMENT FLOOR PLAN</b>		OPTION	OPTION
OPTION DESCRIPTION		9	


DIV-COMM-LOT-UNIT <b>DCY-S3-0169</b>			
COMM-LOT <b>SAWYERS MILL - LIFESTYLE - 0169</b>			
STREET ADDRESS <b>5681 WOODCREEK DRIVE</b>		APT. NO. ----	ZIP <b>45042</b>
CITY <b>MIDDLETOWN</b>	STATE <b>OH</b>		

© NVR, Inc. expressly reserves the right to modify or amend these plans at any time without notice. These plans are not to be reproduced, changed or altered in any way without the written consent of NVR, Inc.

**NVR**  
NVR, Inc. Suite 100  
Frederick, MD 21703  
5285 Washington Blvd.

C:\NVR\Solves\GRAND\_BAHAMA\_GBH00\_01\DCY-S3-0169\249208\Sheets\Lot\_Specific\A A-6\_BSMT\_LS.dwg 03/17/21 - 2:53 am

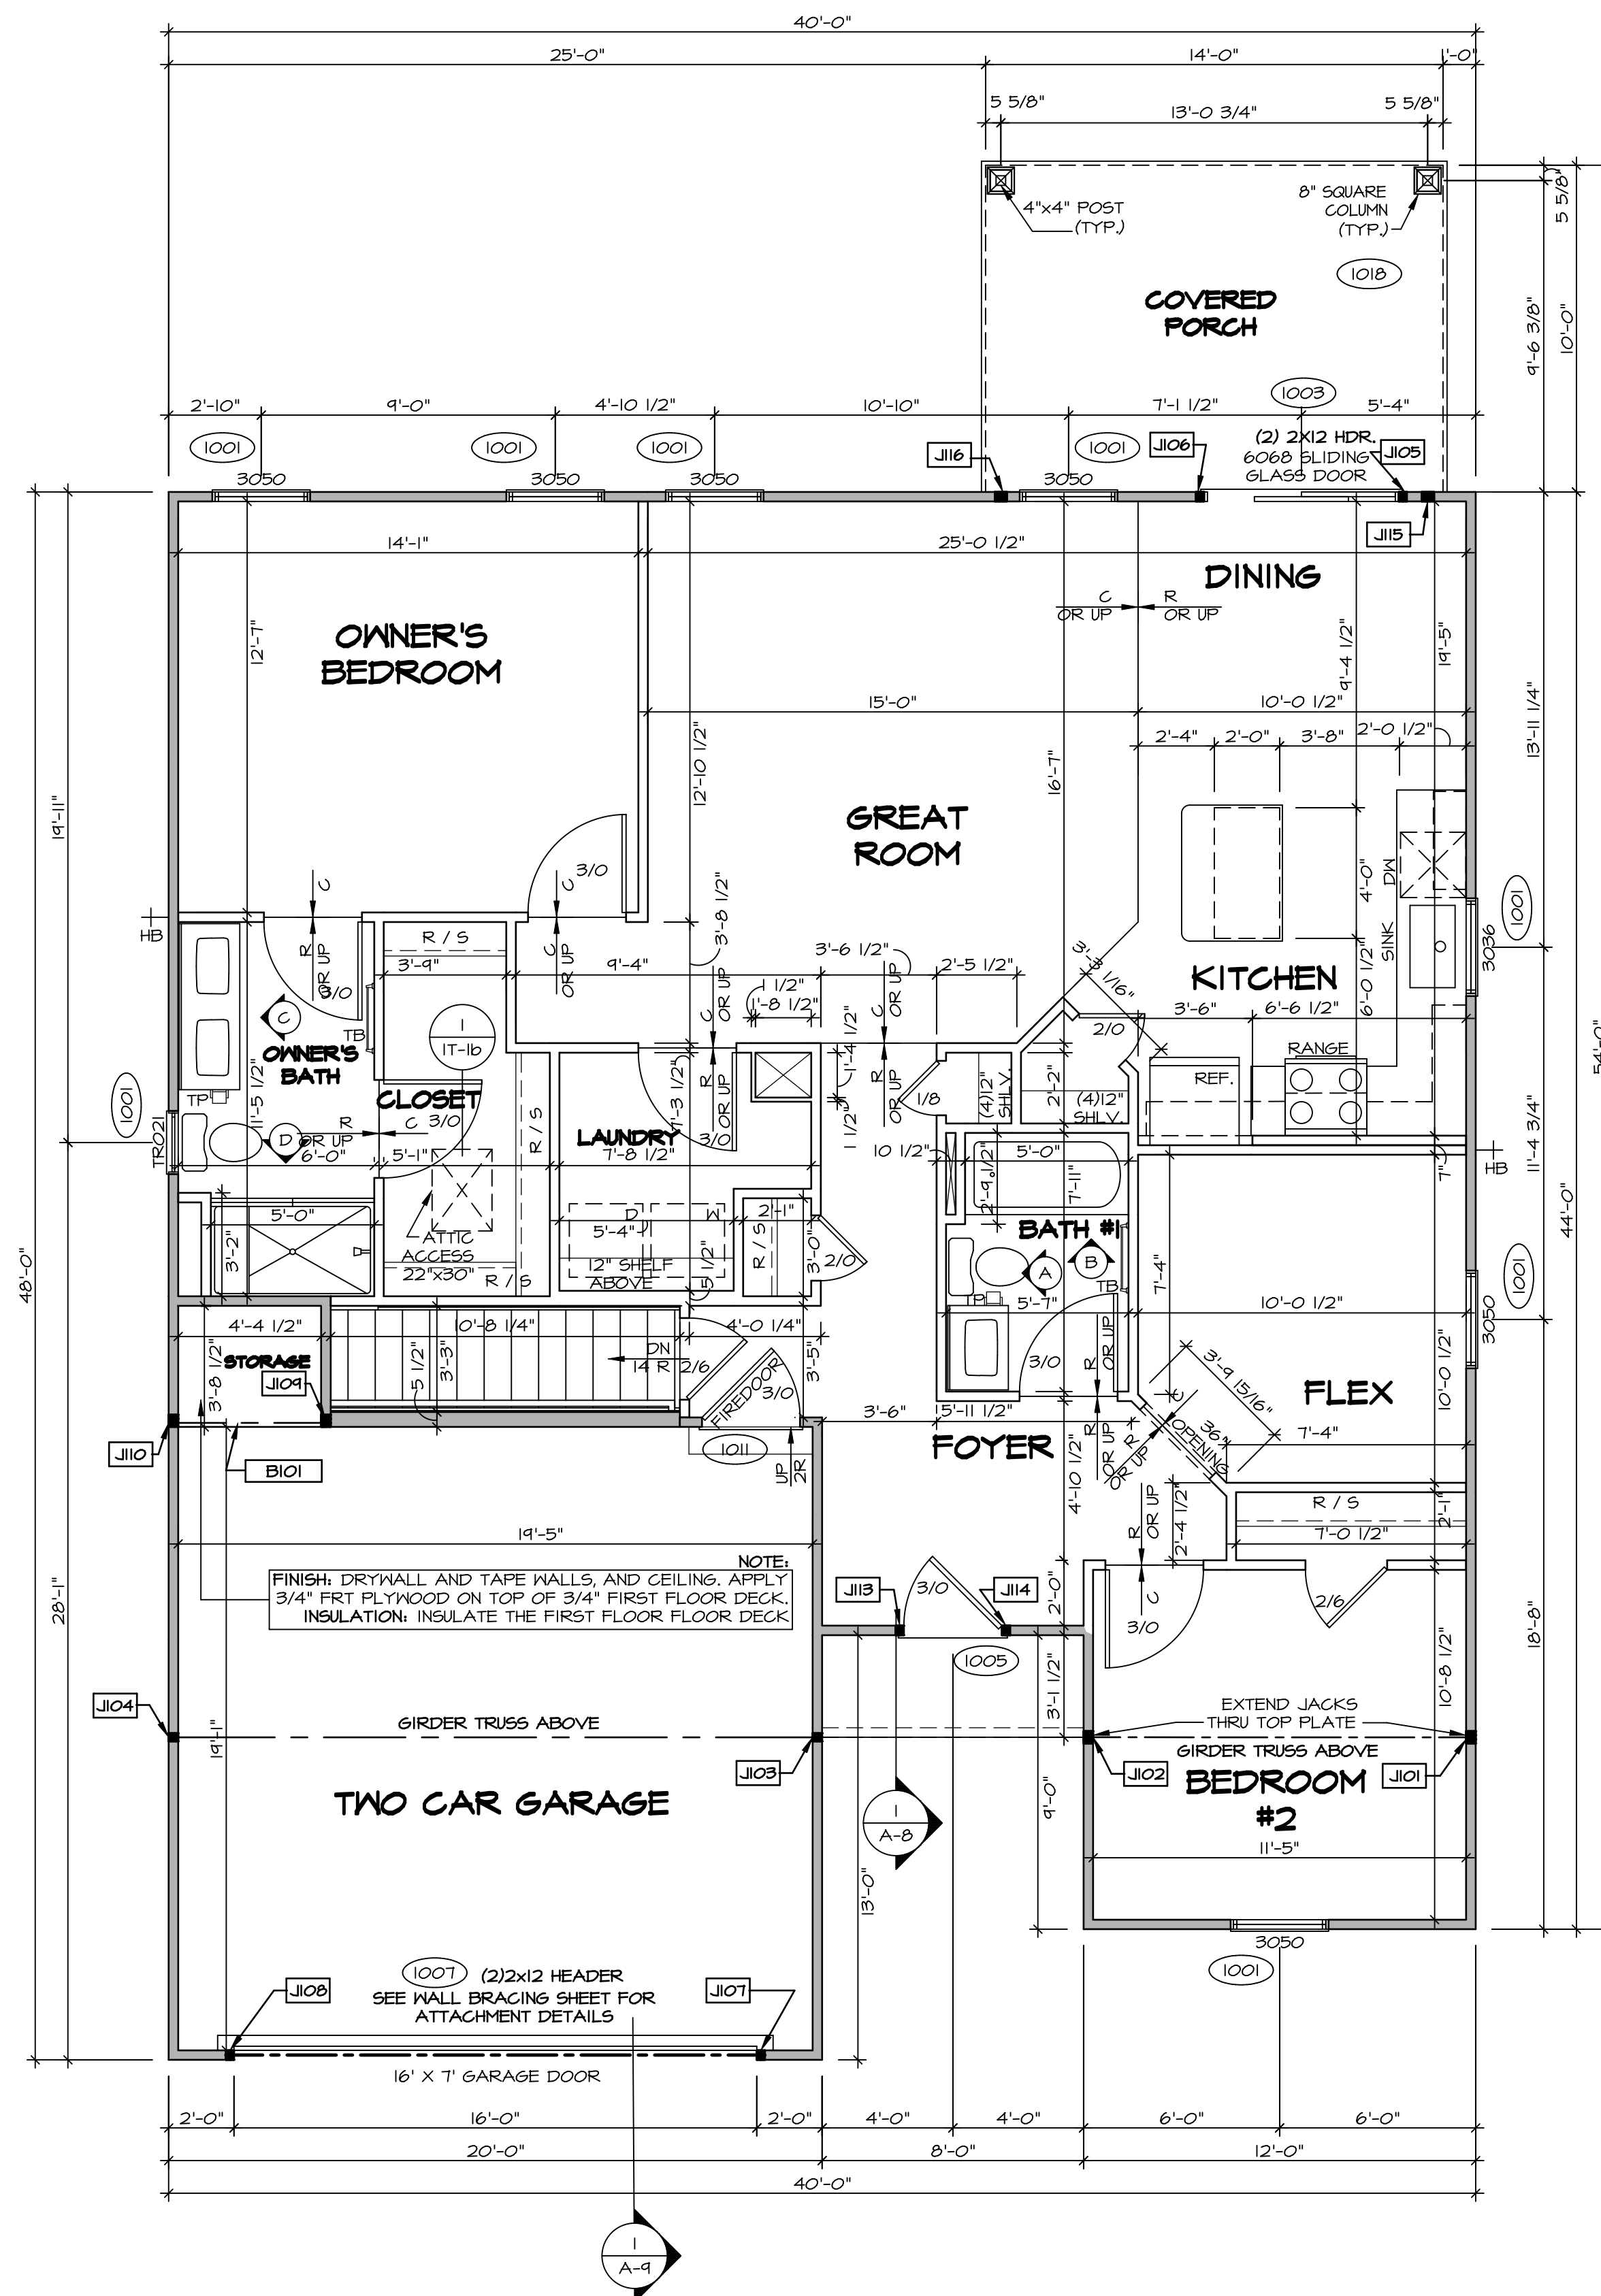

**FIRST FLOOR PLAN**  
SCALE: 1/4" = 1'-0"

FIRST FLOOR JACK SCHEDULE			
IDENTIFIER	DESCRIPTION	ENG. NUM.	REMARKS
J101	JACK - (3) 2X4 SP#H	1000	EXTEND THRU TOP PLATE
J102	JACK - (3) 2X4 SP#H	1000	EXTEND THRU TOP PLATE
J103	JACK - (2) 2X4 SP#F STUD GRADE	1000	
J104	JACK - (2) 2X4 SP#F STUD GRADE	1000	
J105	JACK - (2) 2X4 SP#F STUD GRADE	1003	
J106	JACK - (2) 2X4 SP#F STUD GRADE	1003	
J107	JACK - (2) 2X4 SP#F STUD GRADE	1007	
J108	JACK - (2) 2X4 SP#F STUD GRADE	1007	
J109	JACK - (3) 2X4 SP#F STUD GRADE	1013	
J110	JACK - (3) 2X4 SP#F STUD GRADE	1013	
J111	JACK - (2) 2X4 SP#F STUD GRADE	1005	
J112	JACK - (2) 2X4 SP#F STUD GRADE	1005	
J113	JACK - (2) 2X4 SP#F STUD GRADE	1005	
J114	JACK - (2) 2X4 SP#F STUD GRADE	1005	
J115	JACK - (3) 2X4 SP#F STUD GRADE	1018	
J116	JACK - (3) 2X4 SP#F STUD GRADE	1018	

**LVL PLY TO PLY FASTENING SCHEDULE:** (WHERE APPLICABLE BASED ON LVL USAGE)

1.A - (2) PLY UP TO AND INCLUDING 11 7/8" TALL; FASTEN PLYS W/ (2) ROWS 16D NAILS AT 12" O.C.  
 2.A - (2) PLY 14" TO AND 18" TALL (INCLUSIVE); FASTEN PLYS W/ (3) ROWS 16D NAILS AT 12" O.C.  
 3.A - (2) PLY 20" TALL AND OVER; FASTEN PLYS W/ (4) ROWS 16D NAILS AT 12" O.C.  
 4.A - (3) PLY UP TO AND INCLUDING 11 7/8" TALL; FASTEN PLYS W/ (2) ROWS 16D NAILS AT 12" O.C. FROM EACH SIDE  
 5.A - (3) PLY 14" TO AND 18" TALL (INCLUSIVE); FASTEN PLYS W/ (3) ROWS 16D NAILS AT 12" O.C. FROM EACH SIDE  
 6.A - (3) PLY 20" TALL AND OVER; FASTEN PLYS W/ (4) ROWS 16D NAILS AT 12" O.C. FROM EACH SIDE  
 7.A - (4) PLY (ALL SIZES); FASTEN PLYS W/ (2) ROWS 1/2" DIAMETER A307 BOLTS AT 24" O.C. SEE SHOP DRAWING FOR ADDITIONAL INFORMATION.

FIELD INSTALLED FIRST FLOOR BEAM/HEADER SCHEDULE				
IDENTIFIER	DESCRIPTION	LENGTH	ENG. NUM.	REMARKS
B101	INT HEADER - 2X10 - 2 PLY	4'-11 1/2"	1013	

**LEGEND**

- BEARING WALL
- NON BEARING WALL
- INDICATES BEARING FROM POINT-LOAD ABOVE JACKS
- BEAM/HEADER
- PAD FOOTING
- STEEL COLUMN
- TRUSS TIE DOWN
- PORTAL FRAME
- JOIST/TRUSS
- LVL
- ENGINEERING PAGE NUMBER

SEE FC DETAILS FOR FRAMING CONNECTORS

**FLOOR PLAN NOTES** RYAN

- ALL HEADERS ARE (2) 2x6 w/ 2x4 WALLS OR (3) 2x6 w/ 2x6 WALLS, UNLESS OTHERWISE NOTED.
- ALL HEADERS TO HAVE (1) 2x4 OR 2x6 JACK AND KING STUD EACH END, UNLESS OTHERWISE NOTED. MULTI-OPENING HEADERS TO HAVE (2) JACKS AT INTERMEDIATE BEARING, UNLESS OTHERWISE NOTED. NO ADDITIONAL FLOOR SYSTEM BLOCKING OR CONTINUOUS LOAD PATH JACKS ARE REQUIRED UNLESS OTHERWISE NOTED.
- ALL EXTERIOR WALLS TO BE 4" w/ OSB OR 3 1/2" w/ LAMINATED FIBROUS STRUCTURAL SHEATHING, ALL INTERIOR WALLS TO BE 3 1/2", UNLESS OTHERWISE NOTED.
- HATCHED AREAS INDICATE DROPPED CEILINGS. ALL DROPPED CEILINGS ARE 12" UNLESS OTHERWISE NOTED.
- SEE "BRACED WALL PANEL DETAIL SHEET" FOR SPECIAL WALL FRAMING LOCATIONS AND HEADER SIZES, IF APPLICABLE.
- SEE STANDARD DETAIL CATEGORY "IT" SHEET(S) FOR INTERIOR TRIM DETAILS.
- SEE ARCHITECTURAL DETAIL SHEET "AD" FOR HOUSE SPECIFIC INTERIOR TRIM OPTION TABLE.
- ALL HEADERS IN NON-BEARING WALLS SHALL BE A SINGLE FLAT 2X4 OR 2X6 ATTACHED TO GRIPPLERS ABOVE, UNLESS OTHERWISE NOTED.
- TANKED WATER HEATER SHOWN AS BASE CONDITION. OPTIONAL TANKLESS WATER HEATER IS AVAILABLE IN LIEU OF TANKED WATER HEATER.

**GYPSUM NOTES**

AT GARAGE:  
GYPSUM BOARD AT COMMON WALLS, CEILINGS, BEAM WRAPS AND SUPPORTS PER STANDARD DETAIL FA-1(b) FIRE ASSEMBLIES OR AS REQUIRED BY LOCAL CODE.

AT STAIRS:  
1/2" GYPSUM BOARD AT UNDERSIDE OF STAIRS AND WALLS IN CLOSET

DIV-COMM-LOT-UNIT  
**DCY-S3-0169**

COMM-LOT  
SANTYERS MILL - LIFESTYLE - 0169

STREET ADDRESS  
5691 WOODCREEK DRIVE

CITY  
MIDDLETOWN

STATE  
OH

ZIP  
45042

APT. NO.  
----

STREET ADDRESS  
5691 WOODCREEK DRIVE

CITY  
MIDDLETOWN

STATE  
OH

ZIP  
45042

© NVR, Inc. expressly reserves the right to modify these plans without notice. These plans are not to be reproduced, changed or altered in any way without the written consent of NVR, Inc.

**NVR**  
NVR, Inc. Suite 100  
5285 Washington Blvd.  
Frederick, MD 21703

SET NO. GBH00  
VERSION 01  
DRAWN BY  
DATE:  
OPTION


MODEL  
**GRAND BAHAMA**  
DRAWING TITLE  
FIRST FLOOR PLAN

SHEET NO.  
**A-7**


OPTION DESCRIPTION  
10

C:\NVR\Solves\GRAND\_BAHAMA\_GBH00\_01\DCY-S3-0169\_2429208\Sheets\01\_A-7\_Plan\_L.S.dwg 03/17/21 - 2:54 pm


- NOTES:**
- CABINET LAYOUT (S) ARE BASED ON FINISHED DIMENSIONS TO DRYWALL.
  - IF KITCHEN PLANS/ELEVATIONS CALL-OUT STANDARD MOLDING, REFER TO STANDARD DETAIL (KKT-1) FOR REPLACEMENT BASED ON CABINET STYLE.
  - ALL (UF3) FILLERS ARE TO BE "TRIM TO FIT" UNLESS OTHERWISE NOTED.
  - CABINET MUST BE SET SHIMMED, LEVELED AND PLUMB BY ADJOINING BASE CABINETS.
  - SET PRE-FINISHED SCRIBE MOLDING AT CABINET BULKHEADS AND AT ENDS (WHERE CABINETS MEET DRYWALL.) PRE-FINISHED SCRIBE MOLDING SHALL BE USED TO PAD OUT CABINET SIDES AT STILE FOR RETURN PIECES OF THE FACE-MOUNTED CABINET CROWN MOLDING.
  - HARDWARE INSTALL NOTE: KNOBS GO ON OPERABLE DOORS AND DRAWERS FOR ALL KITCHEN AND BATH AREAS. DRAWER FRONTS AND DOORS GET (I) KNOB/PULL, NO HARDWARE ON FALSE DRAWER FRONTS.

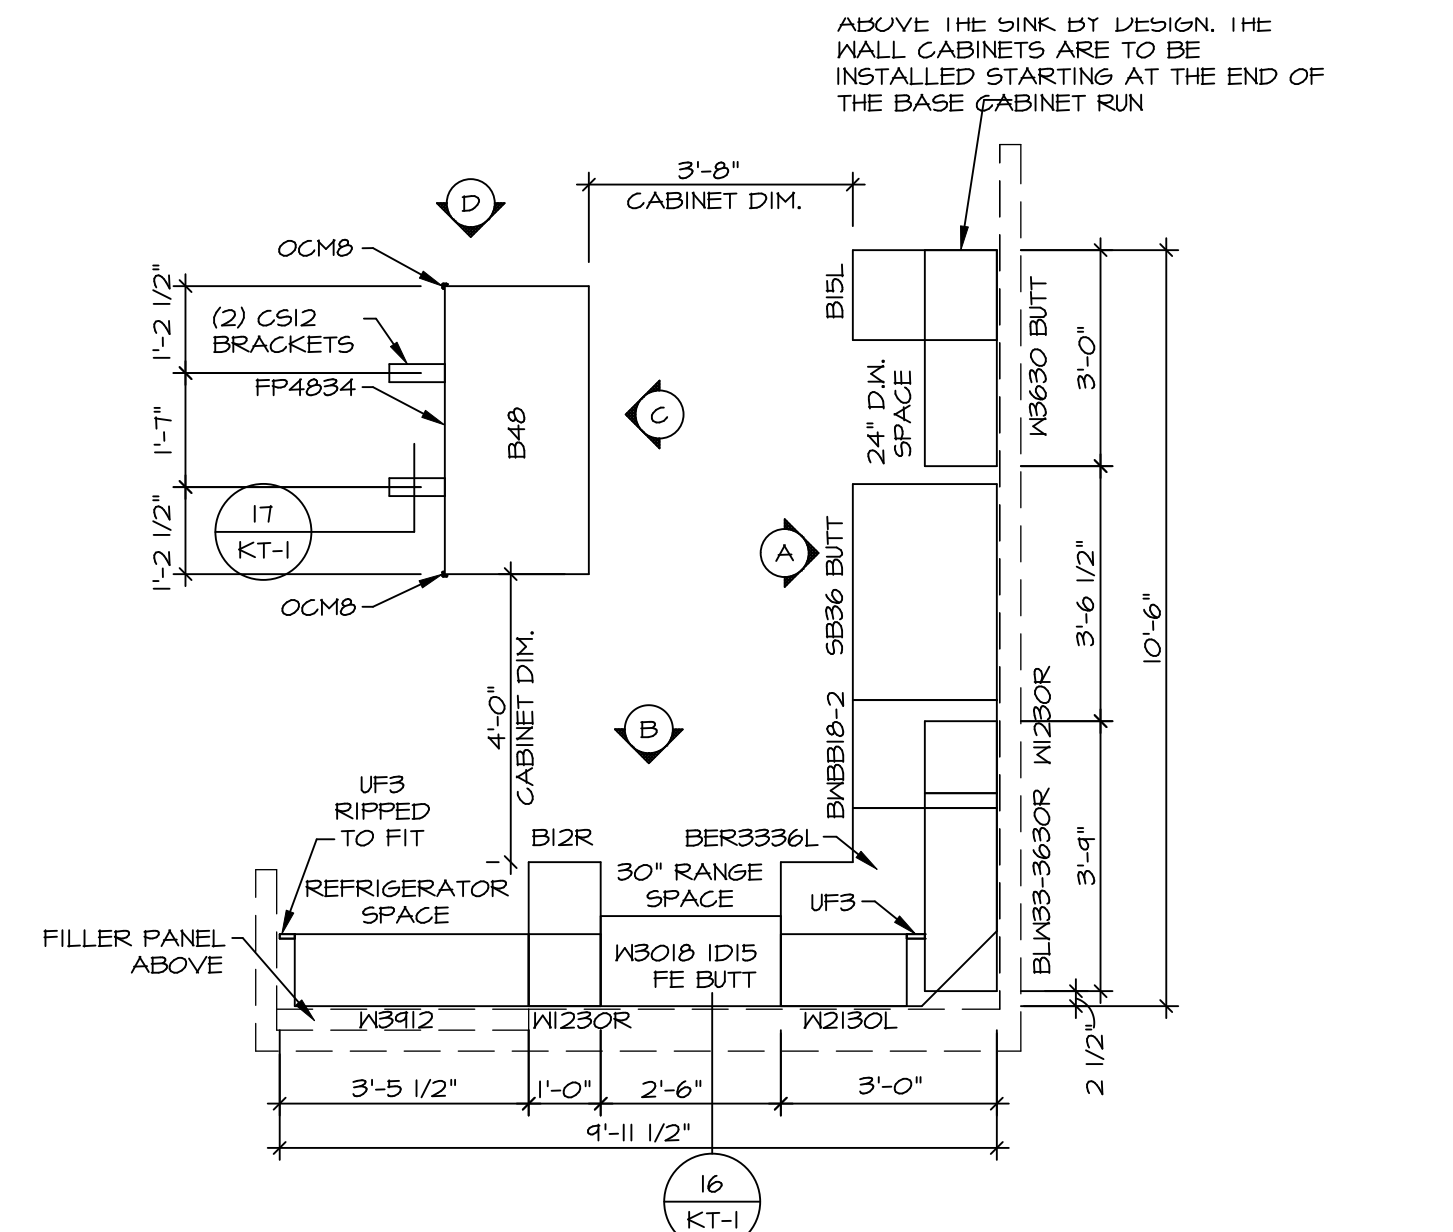


**KITCHEN CABINET PLAN / KC-3765**  
SCALE: 3/8" = 1'-0"  
A-II

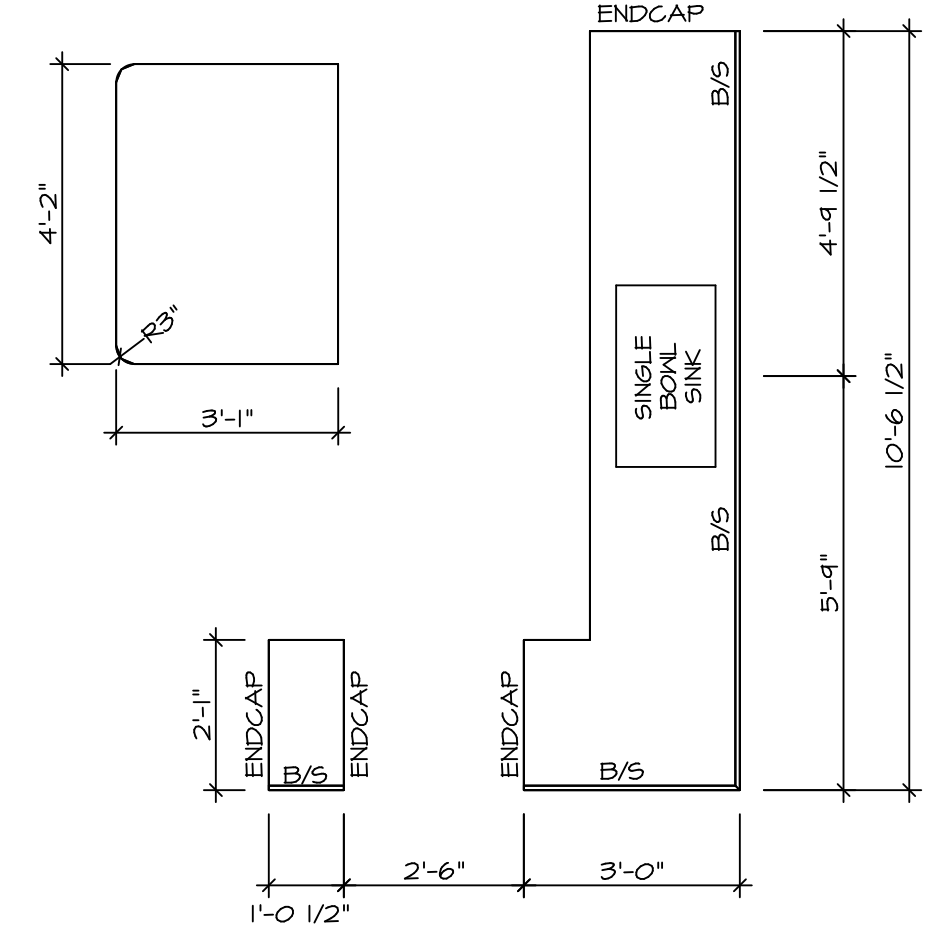


**KITCHEN COUNTERTOP PLAN KC-3765**  
SCALE: 3/8" = 1'-0"  
A-II

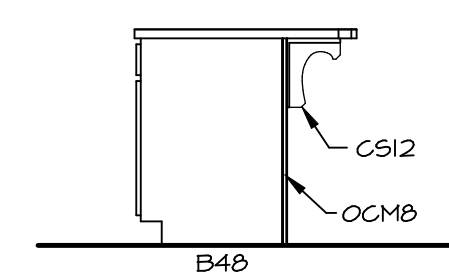


**KITCHEN ELEVATION**  
SCALE: 3/8" = 1'-0"  
A-II

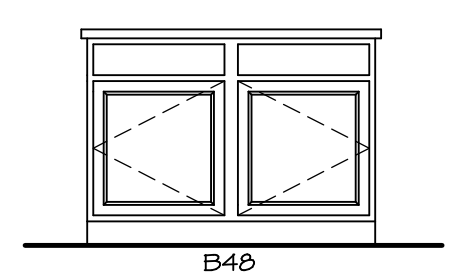

**KITCHEN ELEVATION**  
SCALE: 3/8" = 1'-0"  
A-II

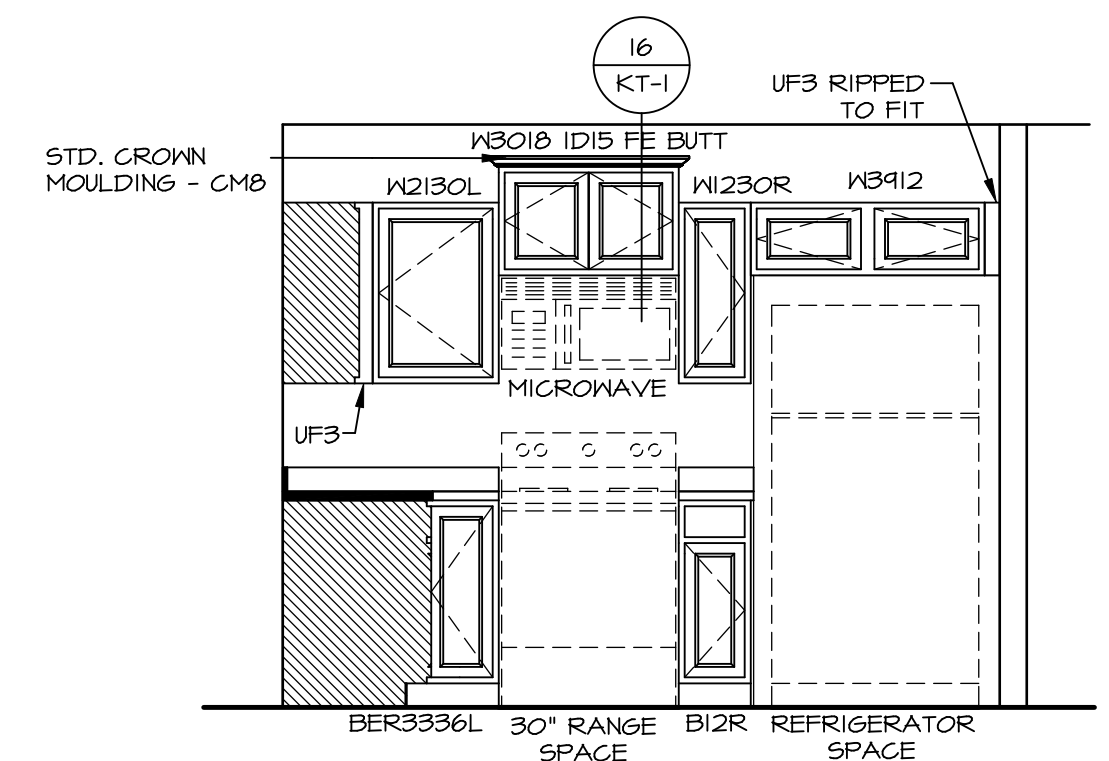


**KITCHEN ELEVATION**  
SCALE: 3/8" = 1'-0"  
A-II

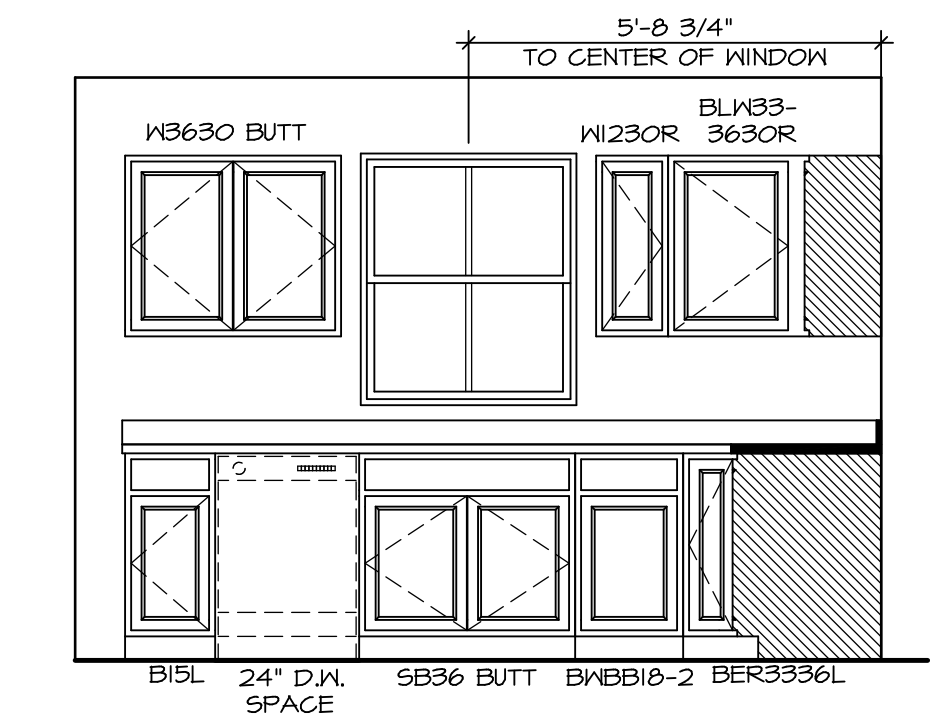


**KITCHEN ELEVATION**  
SCALE: 3/8" = 1'-0"  
A-II

BIV-COMM-LOT-UNIT  
**DCY-S3-0169**  
COMM-LOT  
SAWYERS MILL - LIFESTYLE - 0169  
STREET ADDRESS  
5681 WOODCREEK DRIVE  
CITY MIDDLETOWN STATE OH ZIP 45042


© NVR, Inc. expressly reserves the right to modify these plans at any time without notice. These plans are not to be reproduced, changed or altered in any way without the written consent of NVR, Inc.

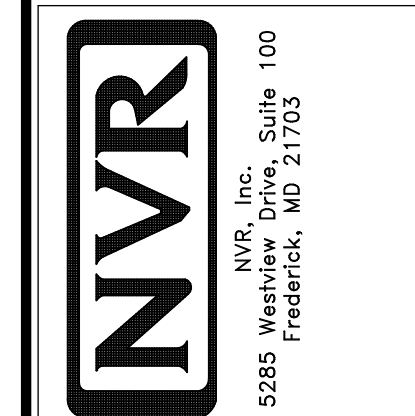


SHEET NO. <b>A-11</b>	MODEL <b>GRAND BAHAMA</b>	SET NO. 01
	DRAWING TITLE KITCHENS	VERSION 01
OPTION DESCRIPTION 14	DATE:	DRAWN BY:
	OPTION	DATE:

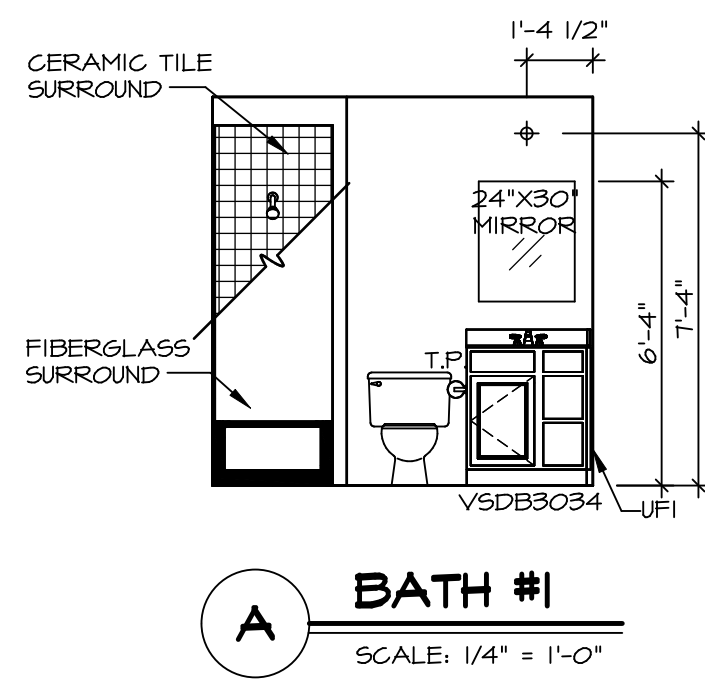


**A BATH #1**  
SCALE: 1/4" = 1'-0"

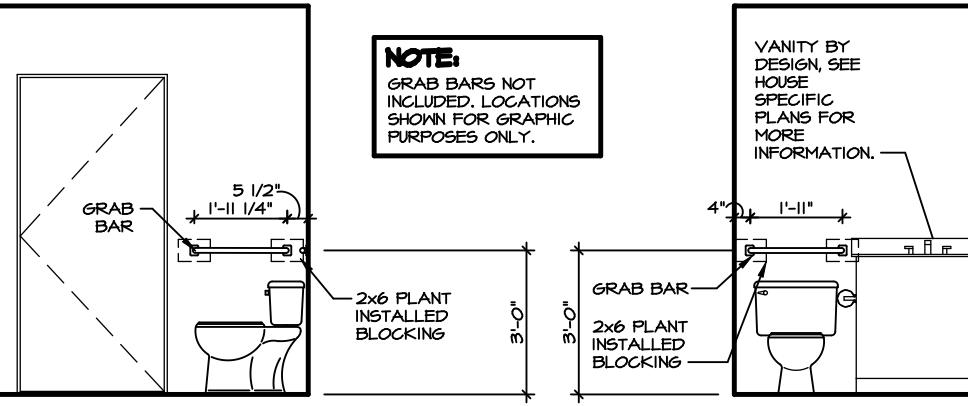


**1 OWNER'S BATH - BLOCKING DETAIL**  
SCALE: 3/8" = 1'-0"

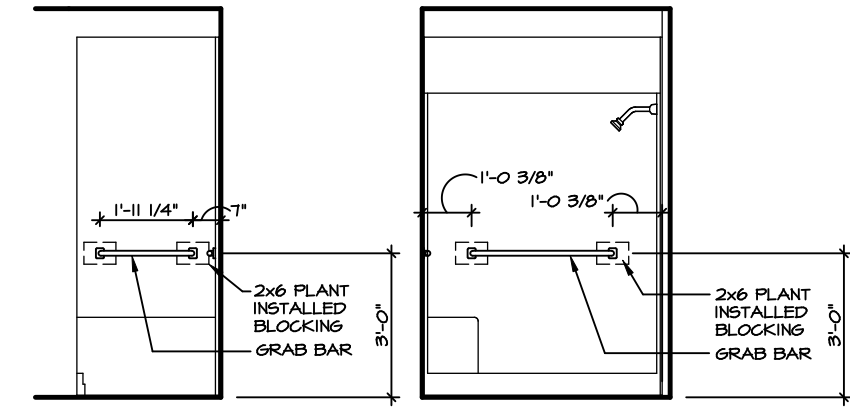


**2 OWNER'S BATH - BLOCKING DETAIL**  
SCALE: 3/8" = 1'-0"

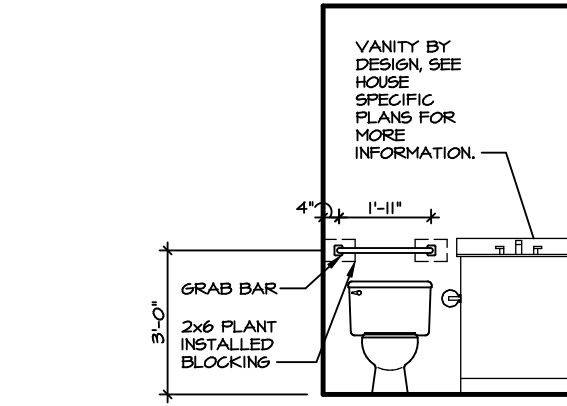


**3 BATH #1 - BLOCKING DETAIL**  
SCALE: 3/8" = 1'-0"

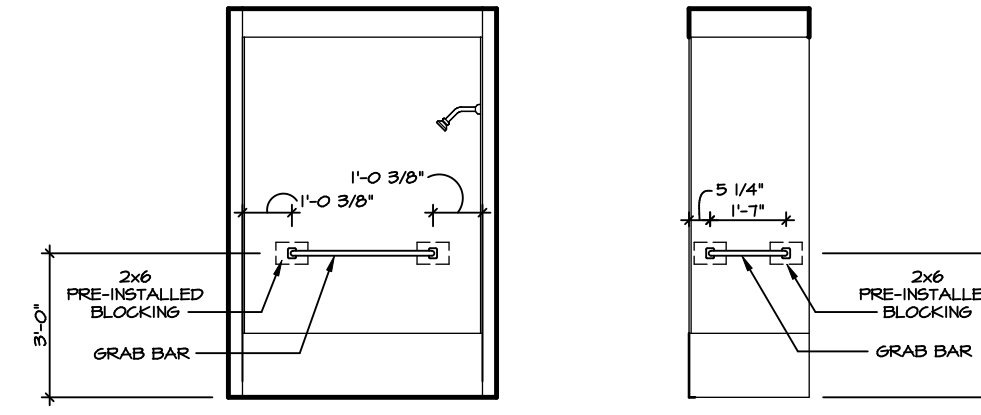


**4 BATH #1 - BLOCKING DETAIL**  
SCALE: 3/8" = 1'-0"

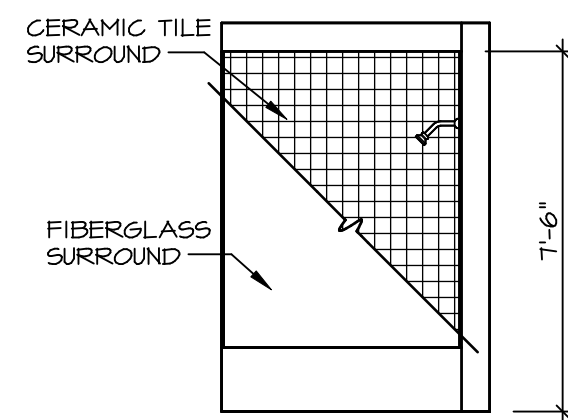

**B BATH #1**  
SCALE: 1/4" = 1'-0"

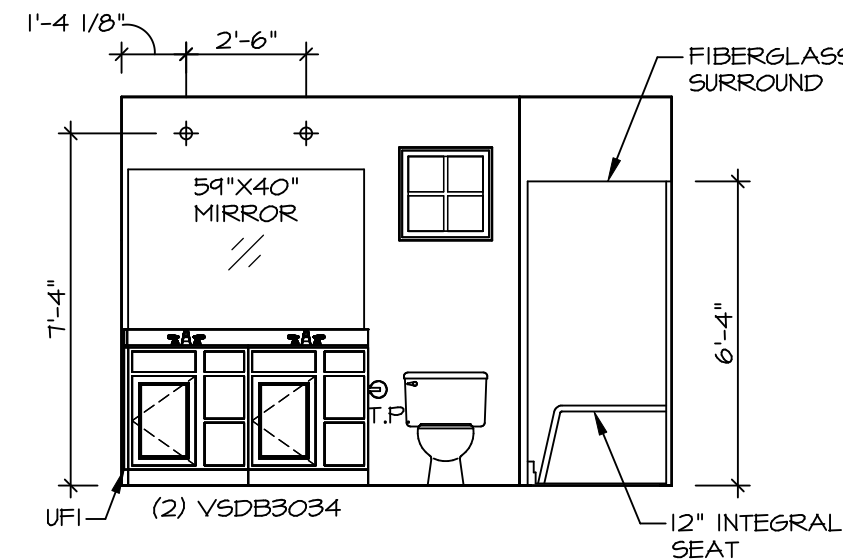

**C OWNER'S BATH**  
SCALE: 1/4" = 1'-0"

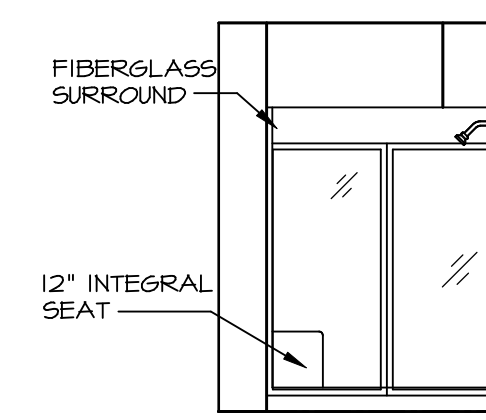


**D OWNER'S BATH**  
SCALE: 1/4" = 1'-0" OWNER'S BATHROOM TYPE A W/SHOWER 'AMA'

**NOTE:**  
GRAB BARS NOT INCLUDED. LOCATIONS SHOWN FOR GRAPHIC PURPOSES ONLY.

VANITY BY DESIGN. SEE HOUSE SPECIFIC PLANS FOR MORE INFORMATION.

VANITY BY DESIGN. SEE HOUSE SPECIFIC PLANS FOR MORE INFORMATION.

SHEET NO.	MODEL	SET NO.	VERSION
A-12	GRAND BAHAMA DRAWING TITLE BATH ELEVATIONS	01	01
OPTION DESCRIPTION	DATE:	DRAWN BY	OPTION
15			

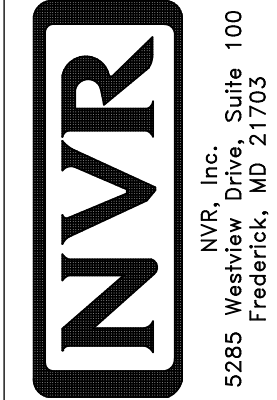

© NVR, Inc. NVR, Inc. Suite 100  
5285 Washburne Rd  
Frederick, MD 21703

DIV-COMM-LOT-UNIT  
**DCY-S3-0169**  
COMM-LOT  
SAWYERS MILL - LIFESTYLE - 0169  
STREET ADDRESS  
6681 WOODCREEK DRIVE  
CITY MIDDLETOWN STATE OH ZIP 45042

APPT. NO. ---  
A-12

- NOTES:**
- TEMPERED GLASS SHOWER ENCLOSURE WITH SWING DOOR OR OPTIONAL SLIDING DOOR BY DIVISION.
  - TUB ACCESS PANELS PROVIDED AS NEEDED, ALL MATERIALS BY DIVISION.
  - ALL BATH ELEVATIONS SHOWN PER PLAN.
  - ALL VSD24-42 DRAWERS TO BE SET ON RIGHT HAND.