



H:\Units in Progress\Nicole\CR2525 Units 1-2 Greenridge 2504-2502 Houston Rddg Thursday, June 19, 2025 11:48:21 AM

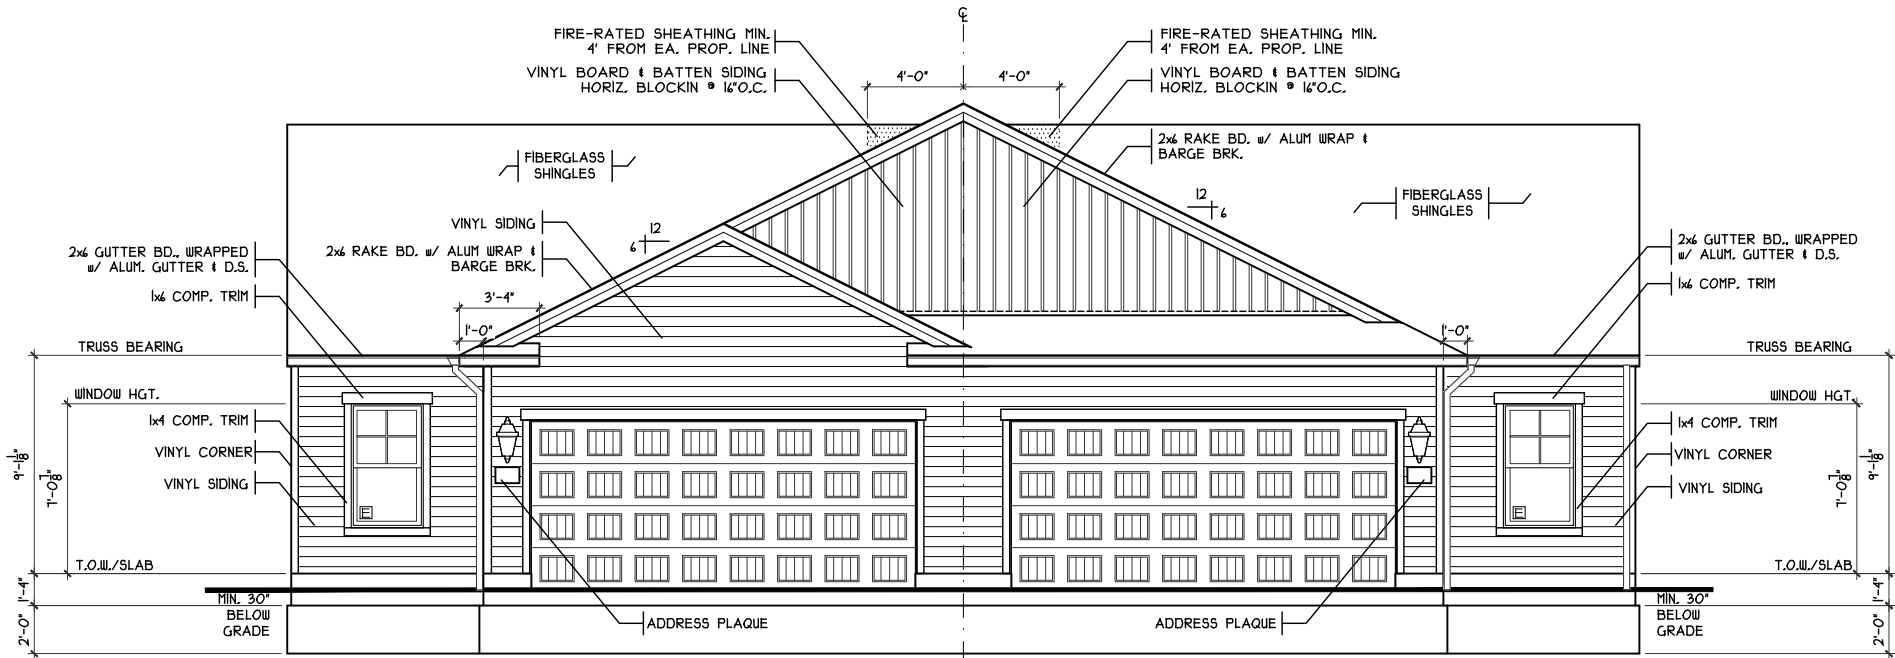

2504 2502

FRONT ELEVATIONS


SCALE: 1/8" = 1'-0"

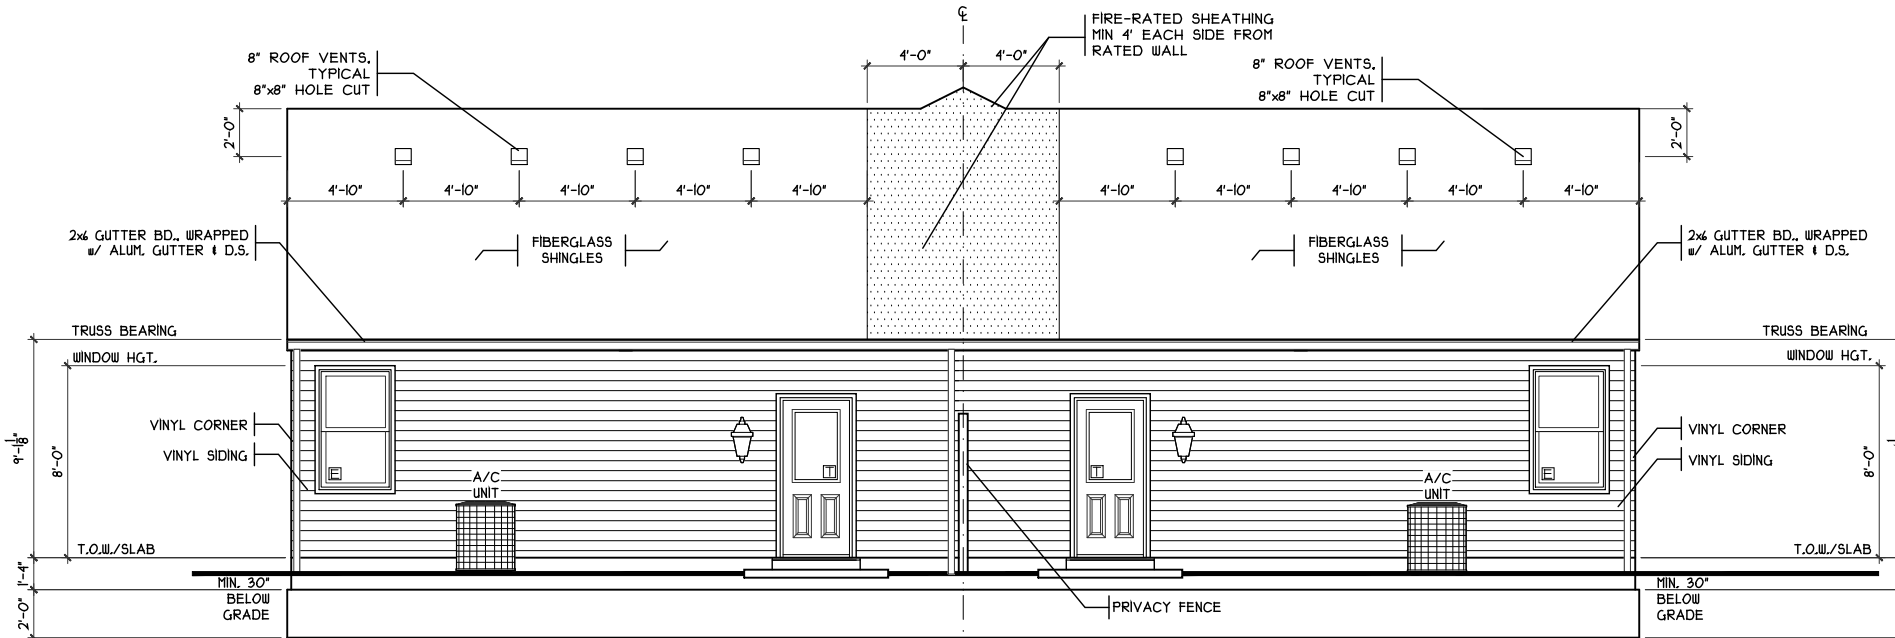

2502 2504

REAR ELEVATIONS

SCALE: 1/8" = 1'-0"

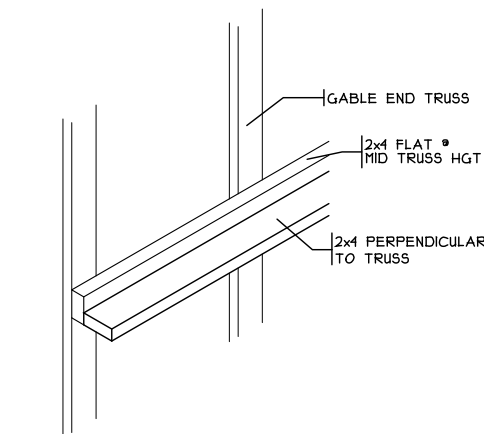

STIFFBACK DETAIL


SCALE: 3/8" = 1'-0"

SHEET INDEX	
SHT #	TITLE
A1	FRONT AND REAR ELEVATION
A1a	SIDE ELEVATIONS
A2	FOUNDATION PLAN/FOUNDATION DETAILS
A3	FLOOR PLAN
A4	BUILDING SECTION, TYP. WALL SECTION
A5	DETAILS
A6	SHAFT WALL DETAILS
G1	GENERAL NOTES
R1	ROOF PLAN, TRUSS PROFILES
E1	ELECTRICAL PLAN

PLAN INFO.	
2504 IS1105B2	
3 BDRMS	1105
3 BATH	1105
4 CAR GARAGE	1105
1ST FLR. CLG.	1105
SQUARE FOOTAGE	
TOTAL	1105
FIRST	1105
SECOND	---
THIRD	---
LOW. LEV. FIN.	---
LOWER (SLAB)	---
GAR. (SLAB)	345
PLAN INFO.	
2502 IS1105B2	
3 BDRMS	1105
3 BATH	1105
4 CAR GARAGE	1105
1ST FLR. CLG.	1105
SQUARE FOOTAGE	
TOTAL	1105
FIRST	1105
SECOND	---
THIRD	---
LOW. LEV. FIN.	---
LOWER (SLAB)	---
GAR. (SLAB)	345
KEY PLAN	
NOTE: PLANS PRINTED ON 24x36 SHEETS TO BE SCALABLE AT FULL SCALE. 1/4" = 1'-0" PLANS PRINTED ON 11x17 SHEETS TO BE SCALABLE AT HALF SCALE. 1/8" = 1'-0"	

CR125125.DWG

ISSUE	DATE

 

PROPOSED PROJECT:
VILLAGES OF GREENRIDGE
2504 AND 2502 HOUSTON RD CINCINNATI, OH
HAMILTON COUNTY

CRISTO HOMES
7594-A Tyers Place Blvd.
West Chester, OH 45669
513.755.0570 www.cristohomes.com

SDA
SABO DESIGN ASSOCIATES
550 Wards Corner Road
Suite 201
Loveland, Ohio 45140
(513) 683-1236
sabodesignassociates.com


PROJECT NO. CR125125	DRAWN BY NLS
DATE 6/19/25	CHECKED BY
SCALE AS NOTED	APPROVED BY
SHEET NO. A1	



NOTE: ALL EXTERIOR DIMENSIONS ARE TO FACE OF FOUNDATION- MASONRY VENEER TO OVERHANG FOUNDATION AS REQ'D. TO ACCOMMODATE 1" AIRSPACE AT SHEATHING. MAXIMUM OVERHANG TO BE 3/4".

A2

H:\Units in Progress\Nicole\CR2525 Units 1-2 Greenridge 2504-2502 Houston Rd\NCRI 2525 Units 1-2 Greenridge 2504-2502 Houston Rd.dwg Thursday, June 19, 2025 11:48:21 AM

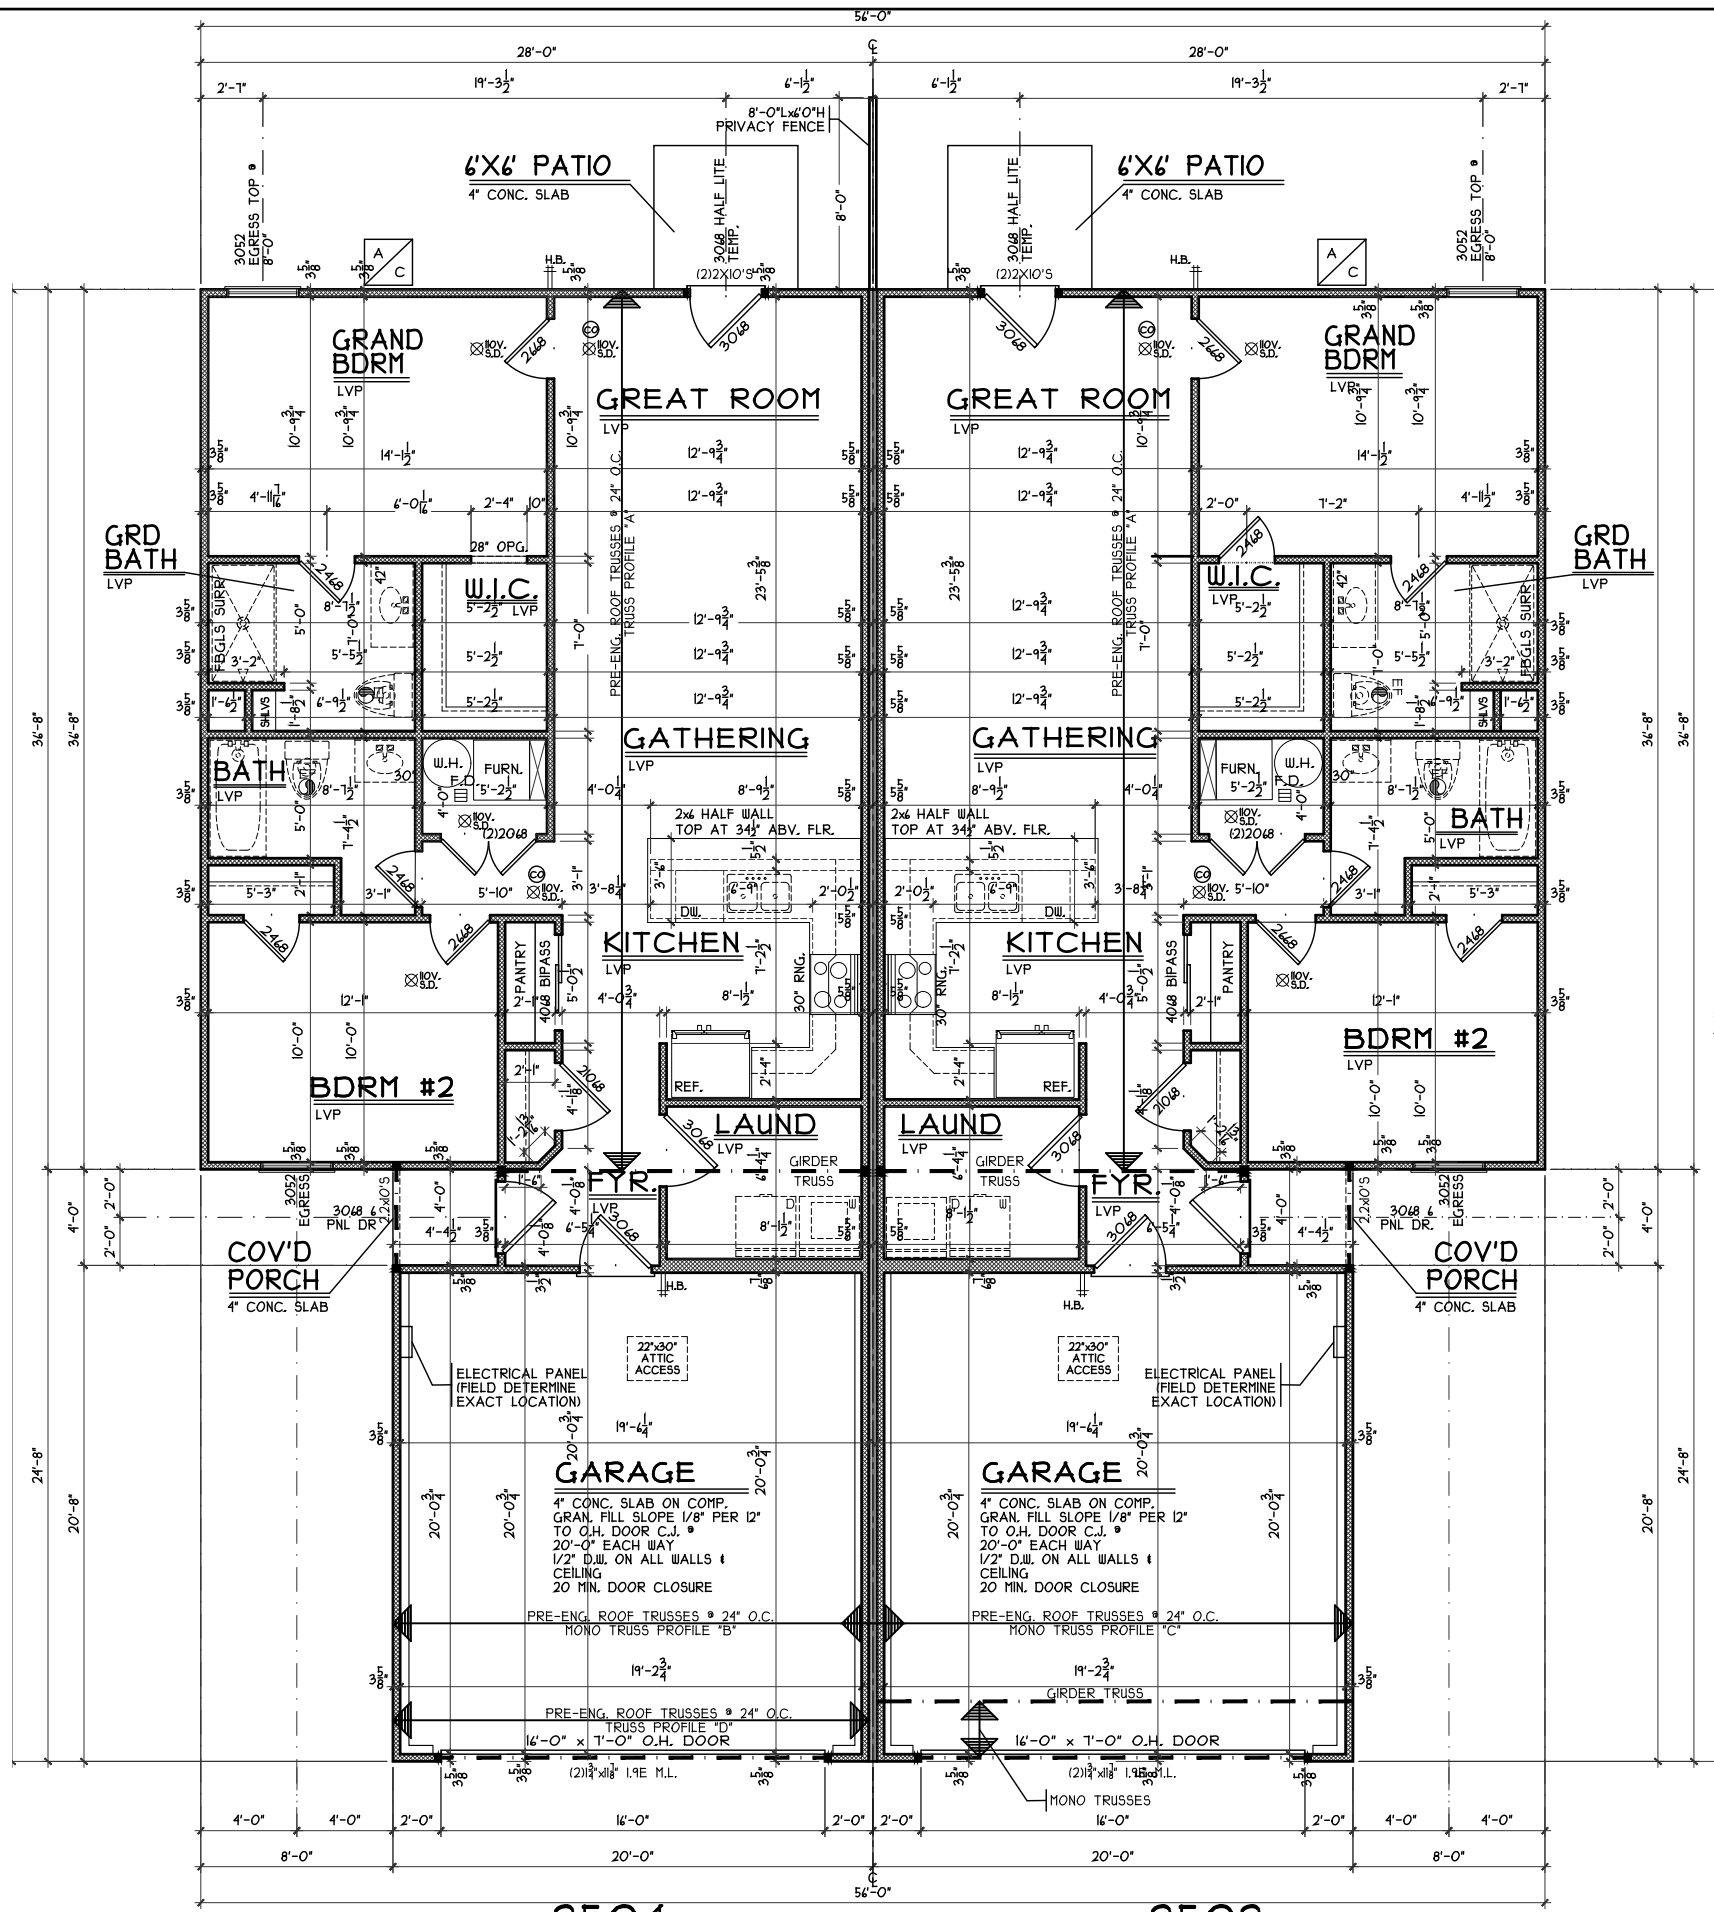

2504

2502

FLOOR PLAN

SCALE: 1/8" = 1'-0"

NOTE: ALL EXTERIOR DIMENSIONS ARE TO FACE OF FOUNDATION- MASONRY VENEER TO OVERHANG FOUNDATION AS REQ'D. TO ACCOMMODATE 1' AIRSPACE AT SHEATHING. MAXIMUM OVERHANG TO BE 3/4".

CR2525.DWG

ISSUE	DATE

PROPOSED PROJECT:
VILLAS OF GREENRIDGE
2504 AND 2502 HOUSTON RD CINCINNATI, OH
HAMILTON COUNTY

CRISTO HOMES
7594-A Tylers Place Blvd.
West Chester, OH 45669
513.755.0570 www.cristohomes.com

SDA
SABO DESIGN ASSOCIATES
550 Wards Corner Road
Suite 201
Loveland, Ohio 45140
(513) 683-1236
sabodesignassociates.com

PROJECT NO. CR2525	DRAWN BY NLS
DATE 6/19/25	CHECKED BY
SCALE AS NOTED	APPROVED BY
SHEET NO.	

A3