




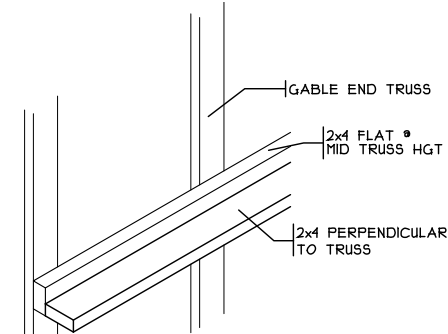


STIFF BACK DETAIL
SCALE: 3/8" = 1'-0"

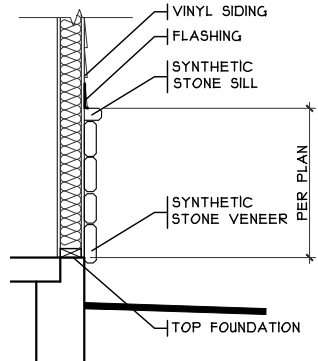

STONE BASE DETAIL
SCALE: 1/8" = 1'-0"

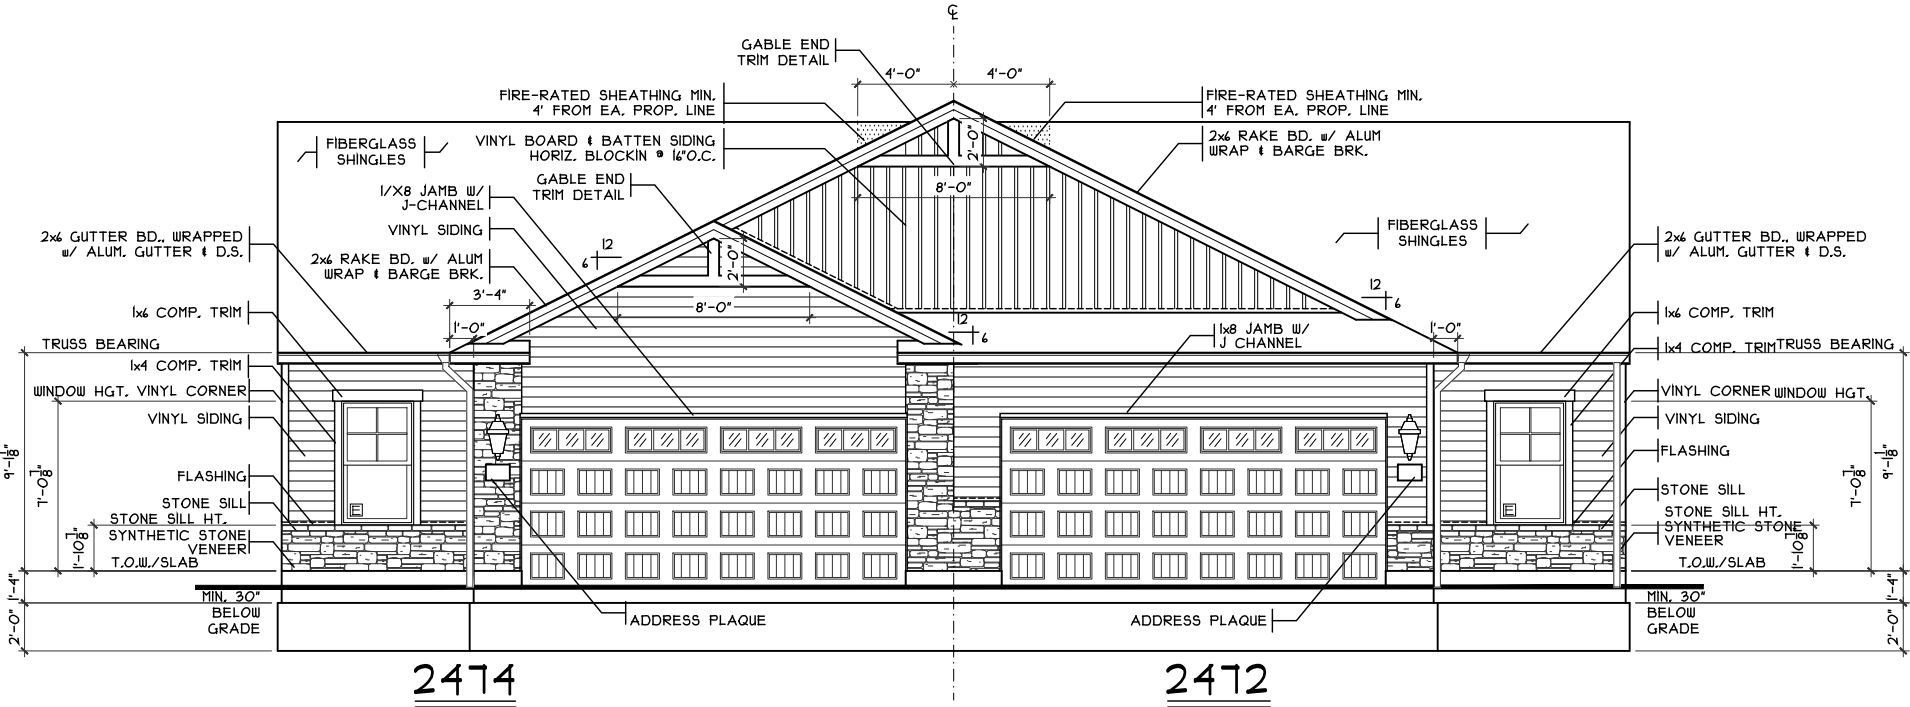

FRONT ELEVATIONS
SCALE: 1/8" = 1'-0"

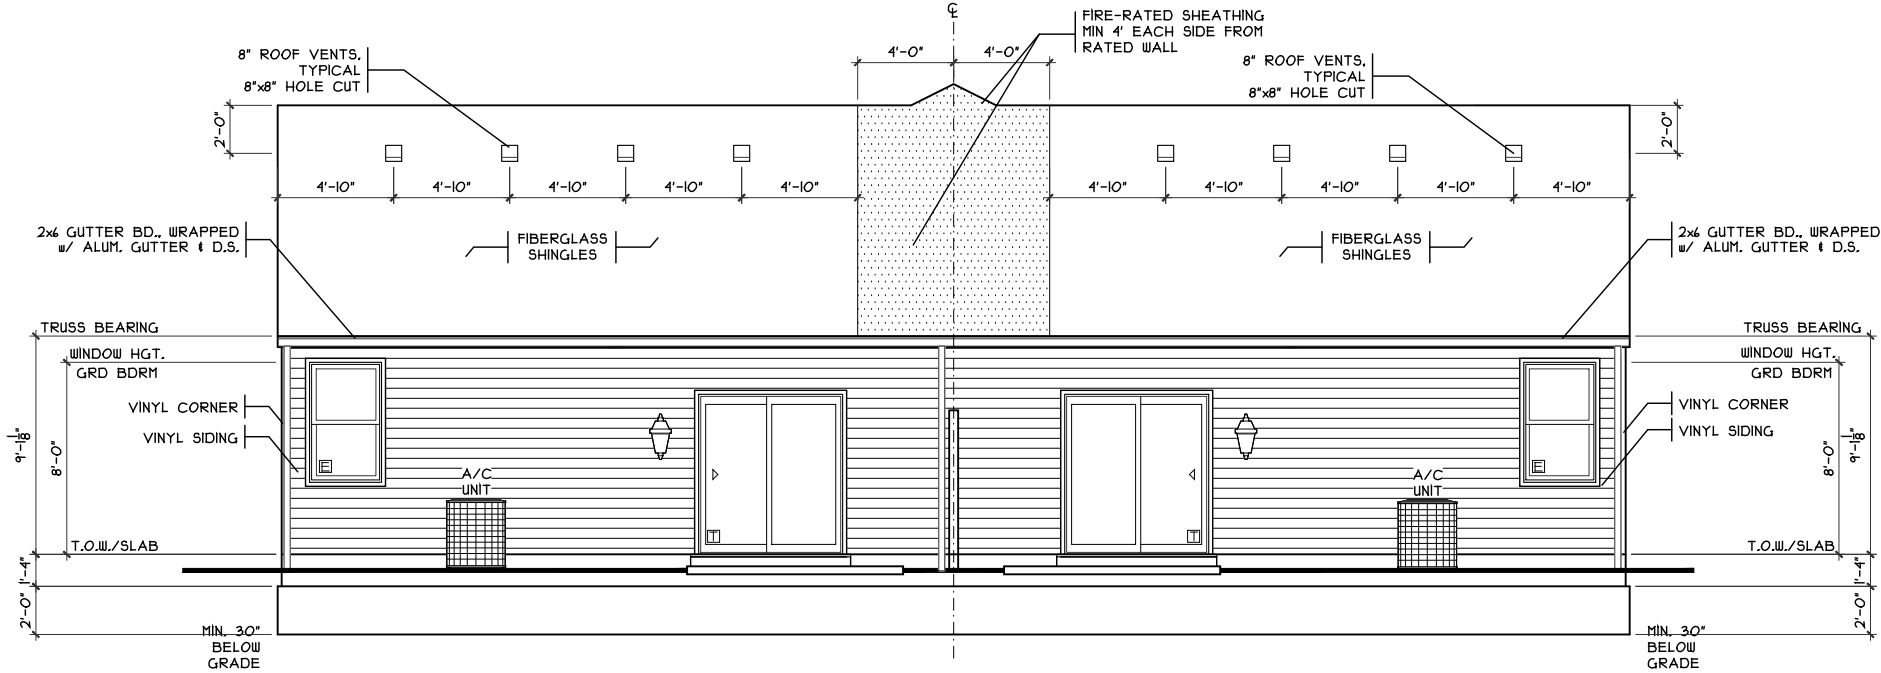


REAR ELEVATIONS
SCALE: 1/8" = 1'-0"

SHEET INDEX	
SHT#	DESCRIPTION
A1	Front & Rear Elevations
A1a	Left & Right Elevations
A2	Foundation Plan
A3	First Floor Plan
A4	Sections /Wall Sections
A5	Roof Plan
A6	Details / Framing Details
G1	General Notes
E1	Electrical Plan

NOTE:
PLANS PRINTED ON 24x36 SHEETS TO
BE SCALABLE AT FULL SCALE. 1/4" =
1'-0"
PLANS PRINTED ON 11x17 SHEETS TO BE
SCALABLE AT HALF SCALE. 1/8" = 1'-0"

PLAN INFO. 2414 RIO194B2	
3 BDRMS 4 BATH 2 CAR GARAGE 1ST FLR. CLG.	
SQUARE FOOTAGE	
1ST SLAB	1094
GAR. (SLAB)	1064
	365

PLAN INFO. 2412 RIO194B2	
3 BDRMS 4 BATH 2 CAR GARAGE 1ST FLR. CLG.	
SQUARE FOOTAGE	
1ST SLAB	1094
GAR. (SLAB)	1064
	365

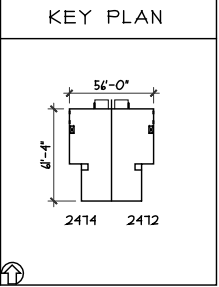

Front & Rear Elevations

Plan: Maple Villa
Date : 7.23.2024
Drawn: JRK
Scale : As Noted
Revised: 4.17.2025
Sheet : 1 of 8



Proposed Residence:
Market Homes
2472 & 2474 Houston Road
Villas of Greenridge 11&12


Maple Villas A - Vinyl

Issue Dates


Cristo Homes reserves all property rights in these plans. These plans are not to be reproduced, changed, or copied in any manner. They are not to be given to a third party, either in full or in part, without first receiving written permission from Cristo Homes. In the event these plans are used by a third party, Cristo Homes shall be held harmless.

Review


A1

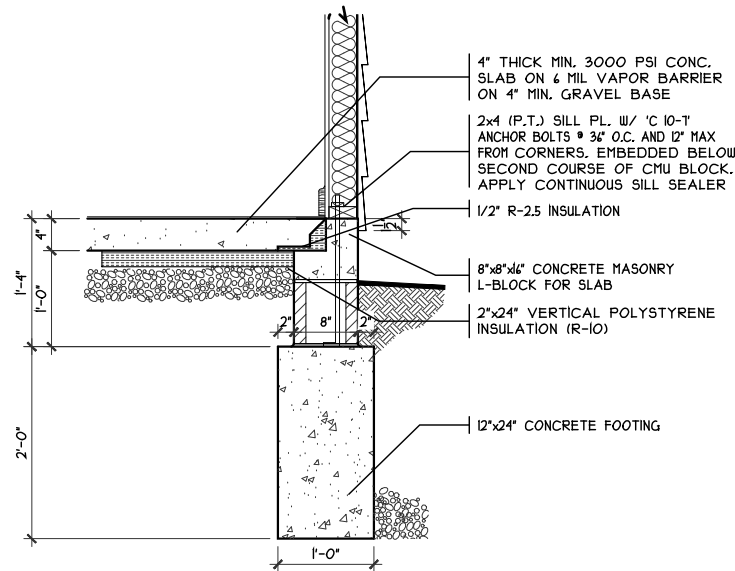

FDN. DETAIL W/ SIDING
SCALE: 1/2" = 1'-0"

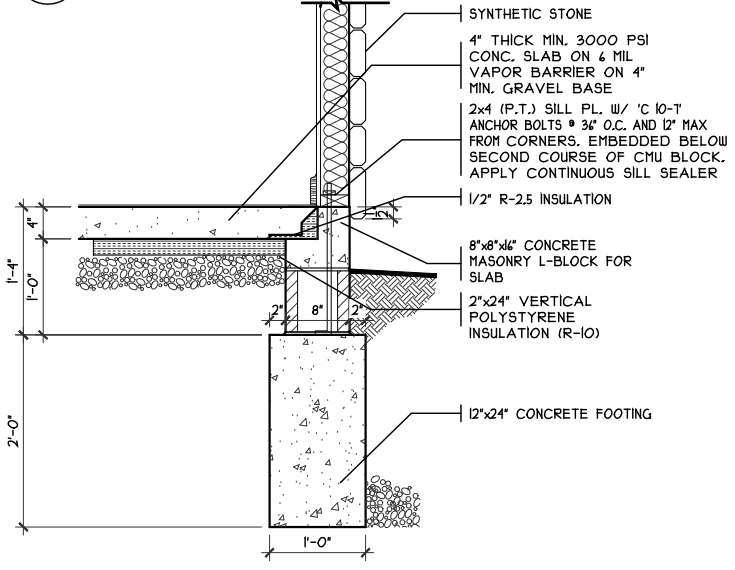


2 FDN. DETAIL W/ STONE
A2b SCALE: 1/2" = 1'-0"

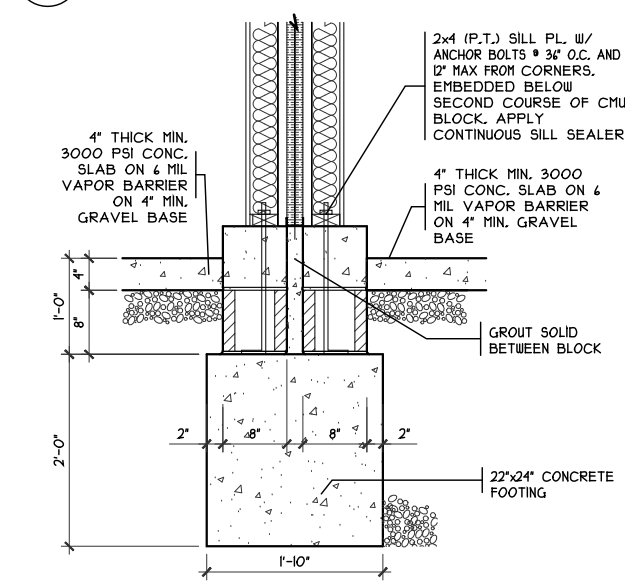


3
A2

FND. DETAIL THRU
GARAGE WALLS

SCALE: 1/2" = 1'-0"

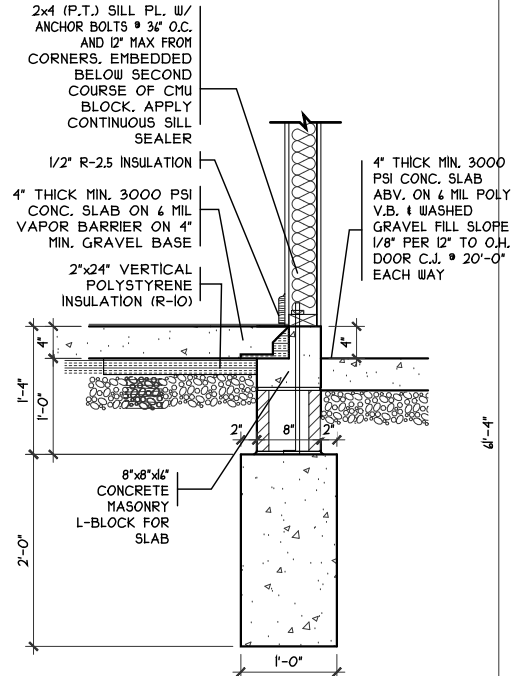


SCALE: 1/2" = 1'-0"

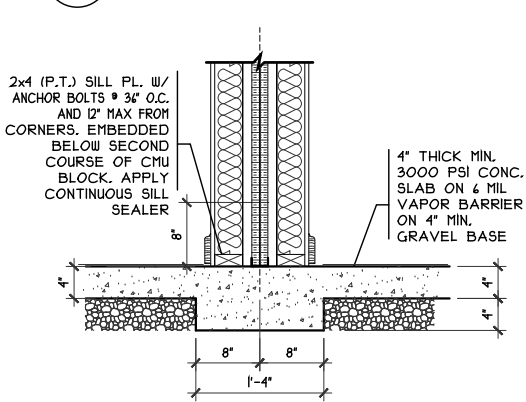

THICKENED SLAB
@ SHAFT WALL

5
A2

SCALE: 3/8" = 1'-0"

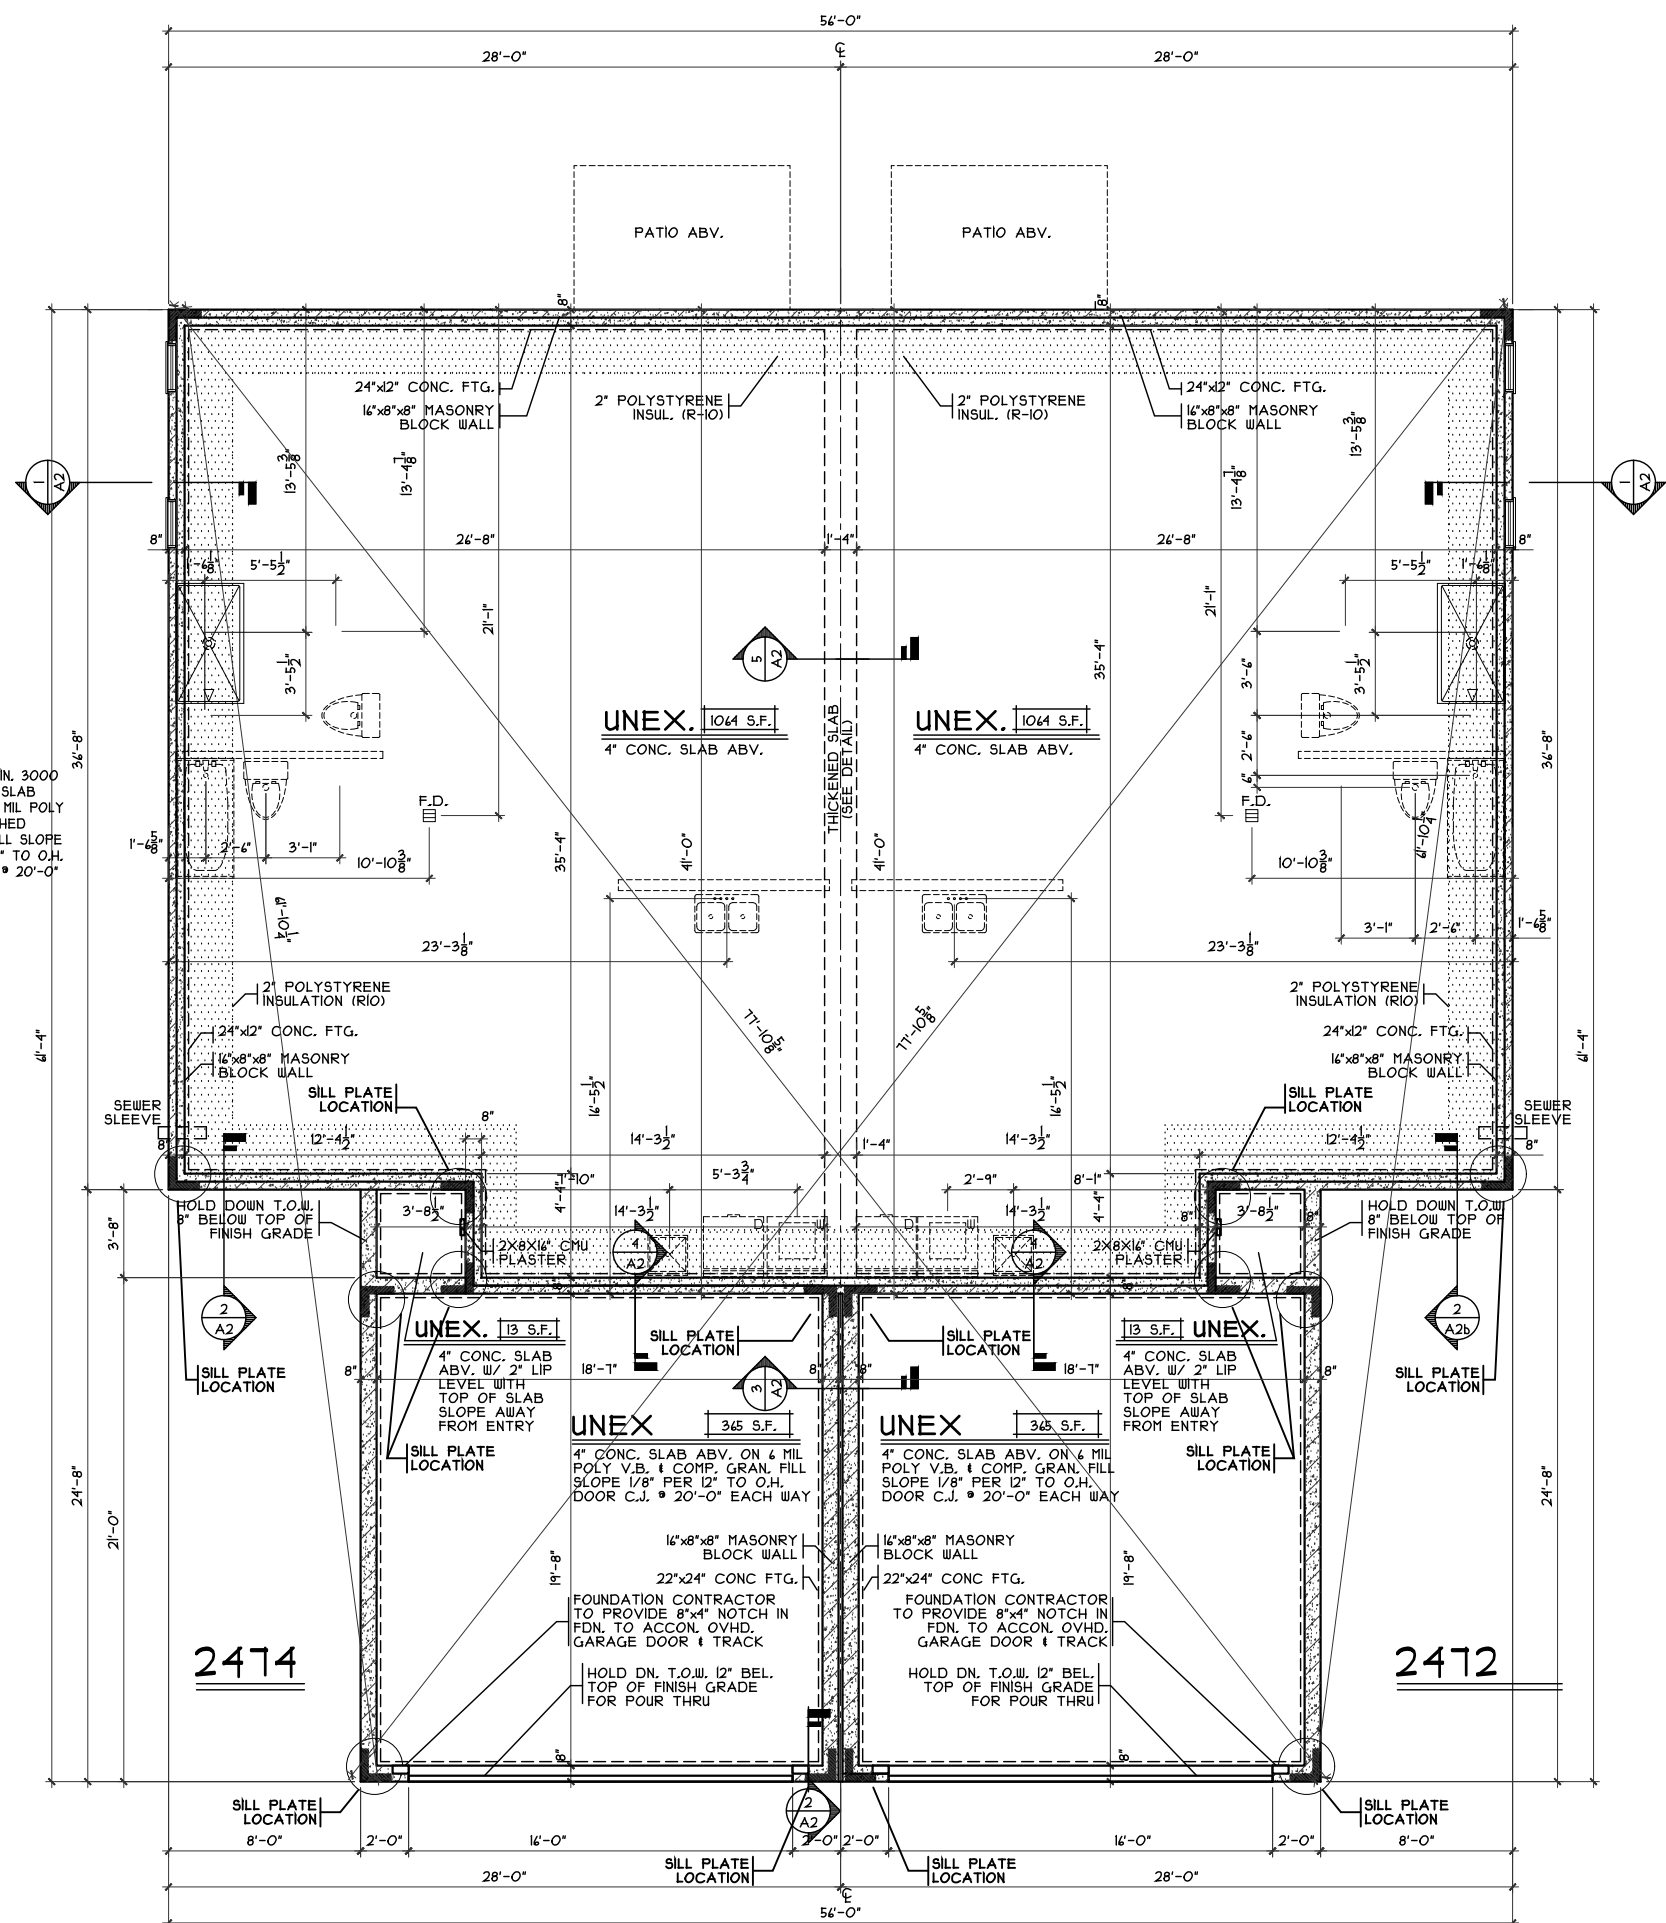

FOUNDATION PLAN

SCALE: 1/8" = 1'-0"

