

VG 782
9818 KNOLL CREEK CT
CENTERVILLE, OH 45458

2 Story Basement

Finished basement and bath

2 showers - master shower 2 valves

1 tub

WATER SOFTENER ROUGH-IN - HOSE BIB RAN SEPERATELY


2 hose bibs - valves required

AA valve on kitchen sink

ice maker

WATER HEATER ELECTRIC 50 GALLON & Mixing Valve

Gas Furnace

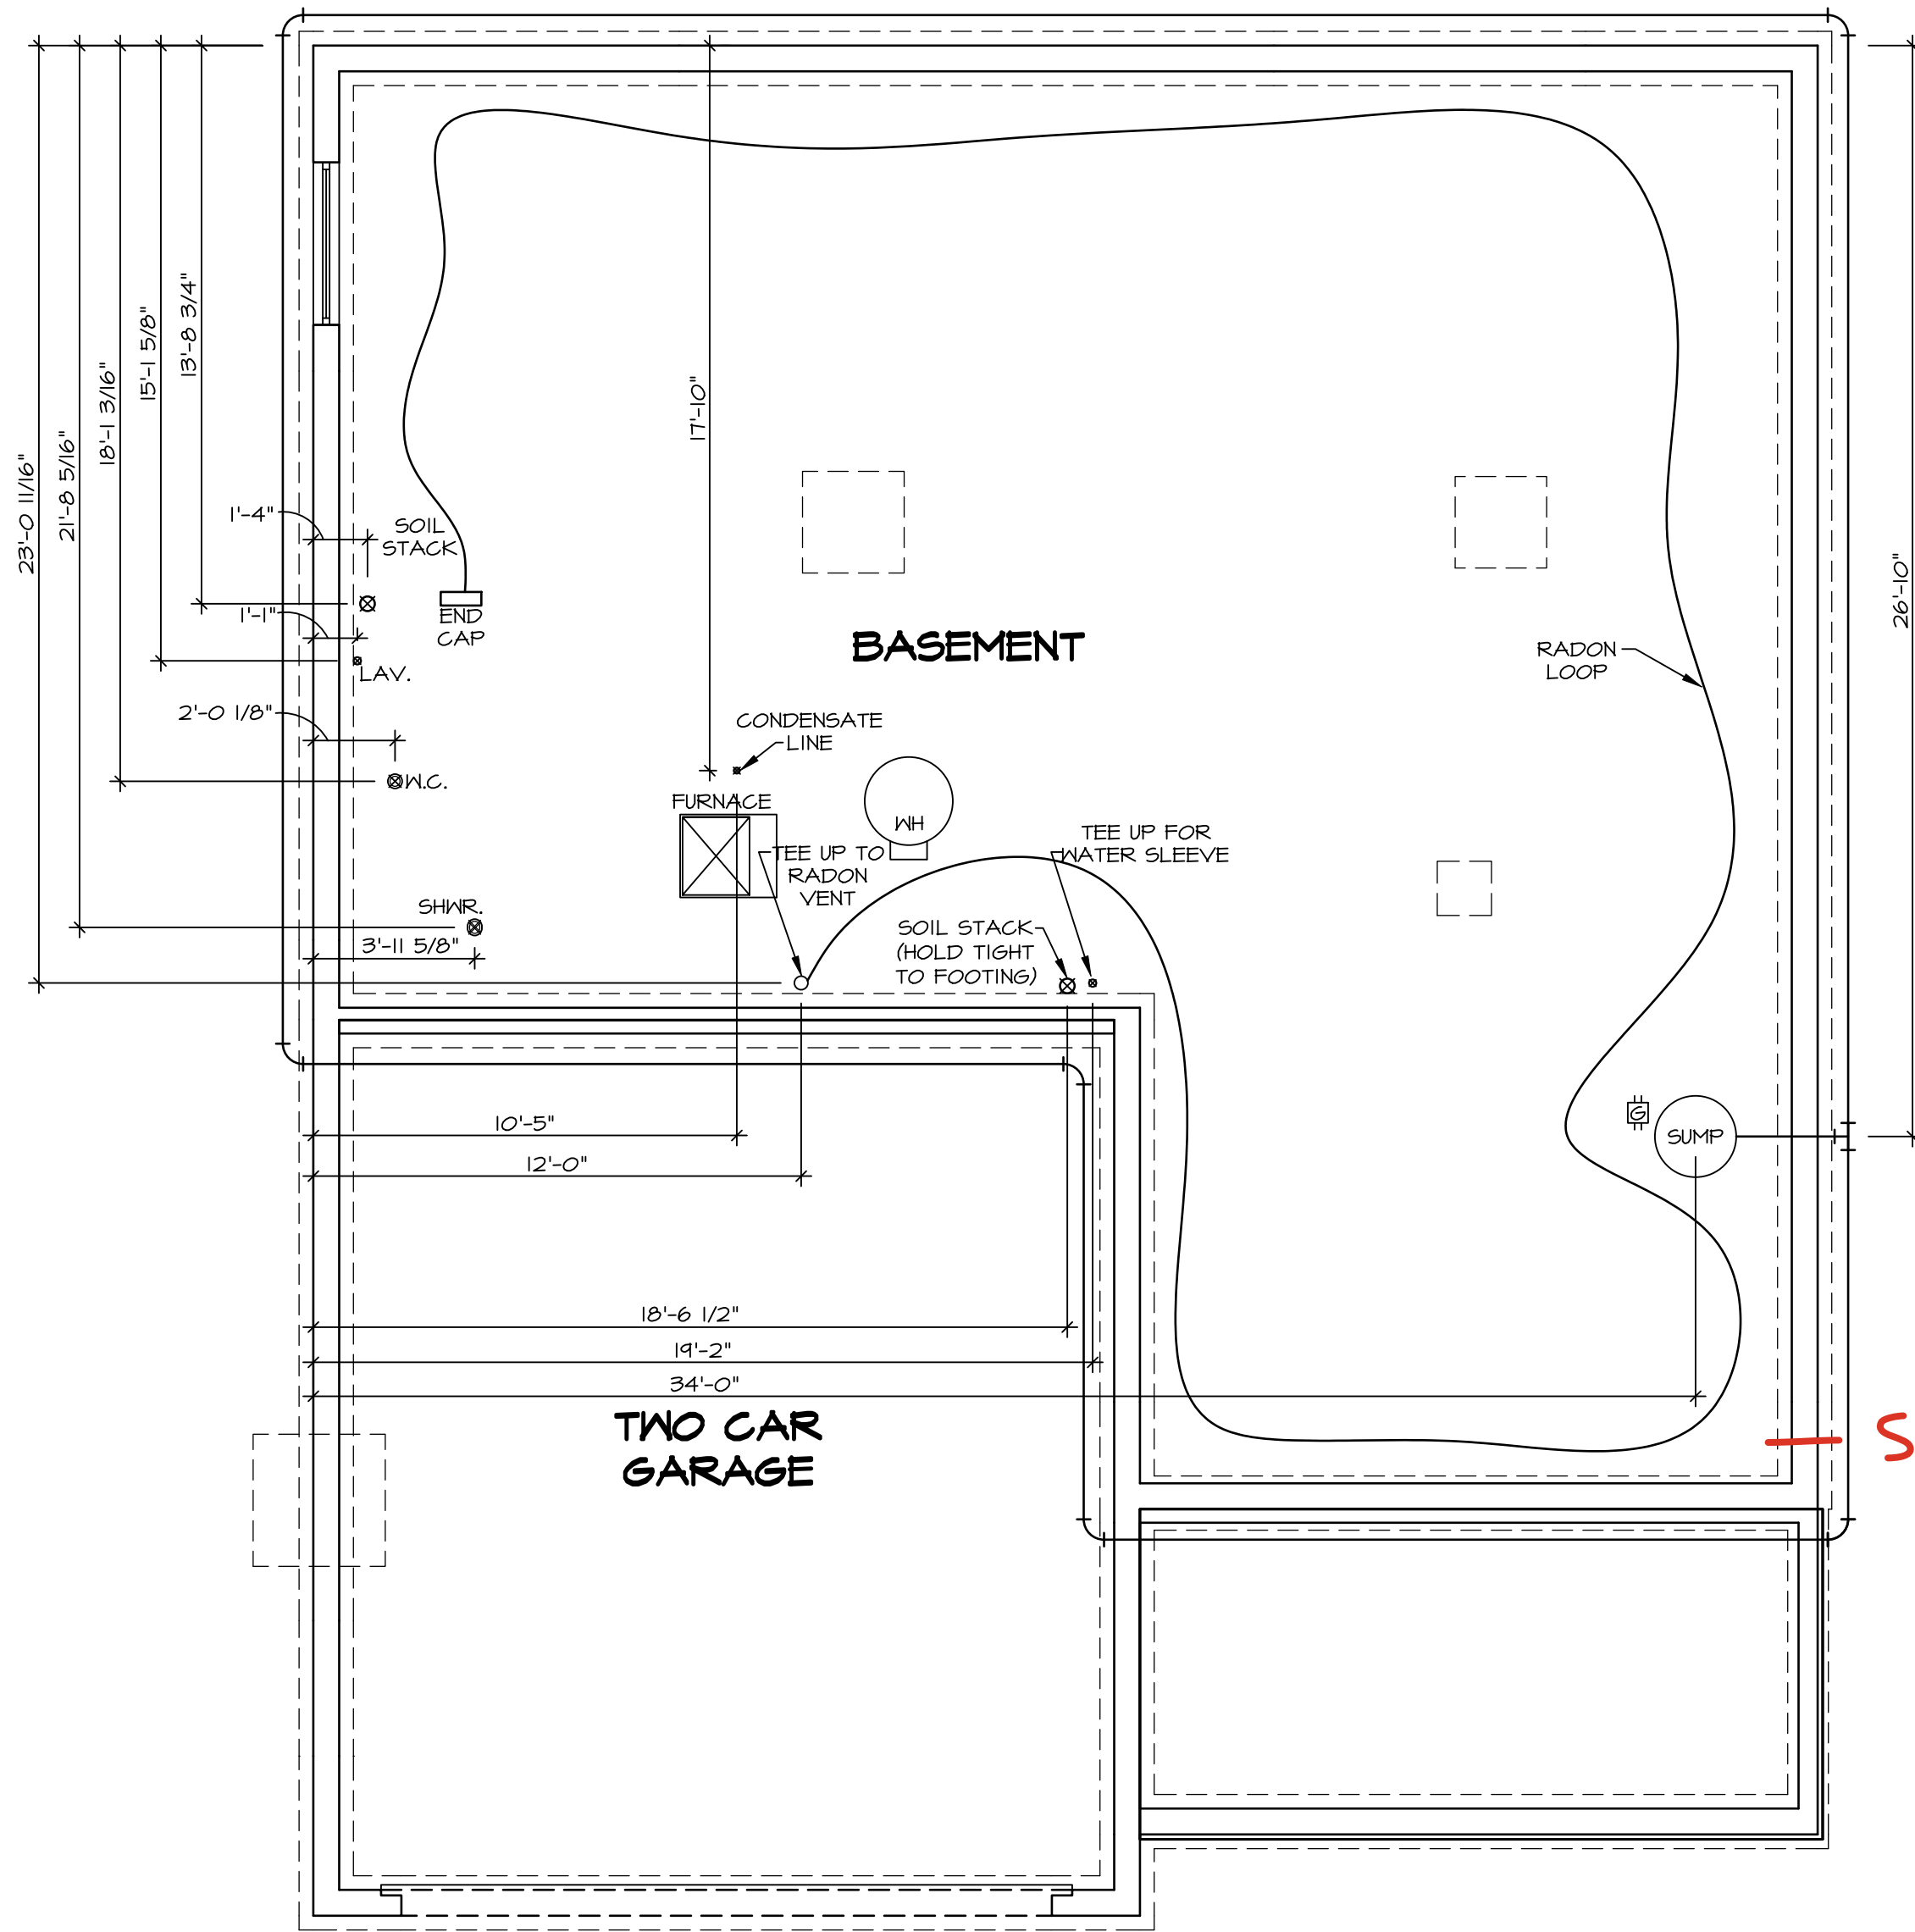

1
A-5
PLUMBING PLAN
SCALE: 1/4" = 1'-0"

- PLUMBING NOTES:**
- RADON REMEDIATION
RADON LOOP:
- (4") PERFORATED HDPE "LOOP"
 - MUST BE PLACED IN STONE BED SLIGHTLY HIGHER THAN ANY INTERIOR DRAINTILE
 - LOOP TO BE SEPARATE FROM ANY DRAINTILE ELEMENTS
 - TO BE CORRUGATED HDPE PIPE
 - SCREWS TO BE INSTALLED THROUGH LOOP AT TEE UP INTO STACK
- STACK REQUIREMENTS:
- 3" PVC STACK (4" IF BASEMENT IS GREATER THAN 2200 SQFT.)
 - NO PART OF STACK IS TO BE HORIZONTAL (45° ELBOWS PERMITTED AS REQUIRED)
 - PIPE TO BE PHYSICALLY LABELED IN THE FIELD AS "RADON VENT" OR OTHER JURISDICTIONALLY REQUIRED LANGUAGE (ON EVERY LEVEL OF HOUSE)
 - ROOF TERMINATION TO BE IN TOP 1/3 OF ROOF
 - SCREEN OR VENT CAP INSTALLED TO KEEP PESTS OUT OF RADON VENT AT ROOF TERMINATION.

SHEET NO.	MODEL	SET NO.	CLMOO
A-5	COLUMBIA	VERSION 01	
	DRAWING TITLE	RELEASE NO.	----
	PLUMBING	DRAWN BY	JAB
	GROUNDWORKS	DATE:	
	OPTION DESCRIPTION	OPTION	
12			

NVR

NVR, Inc., Suite 100
5285 Westview Drive
Frederick, MD 21703

NVR, Inc., expressly reserves its copyright and other property rights in these plans. These plans are not to be reproduced, stored in a retrieval system, or copied in any form or manner whatsoever, nor are they to be used for any purpose without the first obtaining the expressed written consent of NVR, Inc.

DIV-COMM-LOT-UNIT	DCY-VG-0782
COMM-LOT	VL65 OF KINNDING CREEK MARR CO - 0782
STREET ADDRESS	4010 KNOLL CREEK CT
CITY	CENTERVILLE
STATE	OH
ZIP	45458

1. ALL HEADERS ARE (2) 2x6 w/ 2x4 WALLS AND (3) 2x6 w/ 2x6 WALLS, UNLESS OTHERWISE NOTED.

2. ALL HEADERS TO HAVE (1) 2x4 or 2x6 JACK AND KING STUDS AT EACH END, UNLESS OTHERWISE NOTED.

3. MULTI-OPENING HEADERS TO HAVE (2) JACKS AT INTERMEDIATE BEARING, UNLESS OTHERWISE NOTED. NO ADDITIONAL FLOOR SYSTEM BLOCKING OR CONTINUOUS LOADS THAT JACKS ARE REQUIRED UNLESS OTHERWISE NOTED.

4. ALL EXTERIOR WALLS TO BE 4" OR 6" AND ALL INTERIOR WALLS TO BE 3 1/2" UNLESS OTHERWISE NOTED. HAVE 2x4x8 INDOOR EXPOSED CEILINGS AND ALL DROPPED CEILINGS ARE 12" UNLESS OTHERWISE NOTED. SEE ARCHITECTURAL DETAIL 01T-118 FOR 3/4" FIRE STOP AT BUILDING PERIMETER.

5. SEE "BRACED WALL PANEL DETAIL SHEET" FOR SPECIAL WALL FRAMING LOCATIONS AND HEADER SIZES, IF APPLICABLE.

6. SEE "INTERIOR PART CATEGORY "IT" SHEET(S)" FOR INTERIOR TRIM DETAILS.

7. SEE DETAIL SHEET "AD" FOR HOUSE SPECIFIC INTERIOR TRIM OPTION TABLE.

8. ALL STUDS IN NON-BEARING WALLS SHALL BE A SINGLE FLAT 2x4 OR 2x6 ATTACHED TO CRIPPLES ABOVE, UNLESS OTHERWISE NOTED.

9. TANKED WATER HEATER SHALL BE IN BASE CONDITION. OPTIONAL TANKLESS WATER HEATER IS AVAILABLE IN LIEU OF TANKED WATER HEATER.

10. INTERIOR HEADER HEIGHT FOR 8" CEILINGS WILL BE 6'-11" & 9" CEILINGS WILL BE 7'-11" & 9" CEILINGS WILL BE 8'-3", UNLESS OTHERWISE NOTED.

11. BASEMENT FINISH DIMENSIONS ASSUME A 1/2" GAP BETWEEN FLOOR AND CONCRETE WALL.

12. ALL INTERIOR BEARING WALLS SHALL BE REINFORCED WITH STEEL REBAR AND CONCRETE TYPUSM APPLIED TO AT LEAST ONE SIDE OR HAVE MID-HEIGHT BLOCKING INSTALLED.

13. NOTING: ALL CONCRETE OVER CONCRETE TO BE HELD 1/2" SHORT OF FRAMING ABOVE.


AT GARAGE:
GYPSUM BOARD AT COMMON WALLS, CEILINGS, BEAM
WRAPS AND SUPPORTS PER STANDARD DETAIL FA-1(b)
FIRE ASSEMBLIES OR AS REQUIRED BY LOCAL CODE.

AT STAIRS:
1/2" GYPSUM BOARD AT UNDERSIDE OF STAIRS AND WALLS
IN CLOSET

	BEARING WALL
	NON BEARING WALL
	MASONRY WALL
	INDICATES BEARING FROM POINT-LOAD ABOVE
	JACKS
	BEAM/HEADER
/	FOOTING/THICKENED SLAB
	STEEL COLUMN
	TRUSS TIE DOWN
	PORTAL FRAME
	JOIST/TRUSS
	LVL
	ENGINEERING PAGE NUMBER
	WINDOW/DOOR TAG
	PRECAST LINTEL TAG

-SEE FA DETAILS FOR FIRE ASSEMBLIES
-SEE FC DETAILS FOR FRAMING CONNECTORS AND MATERIAL USAGE


BASEMENT JACK SCHEDULE				
IDENTIFIER	DESCRIPTION	OPTIONS	ENG. NUM.	REMARKS
J001	JACK - (2) 2X4 SPF STUD GRADE	FBA	B0031	

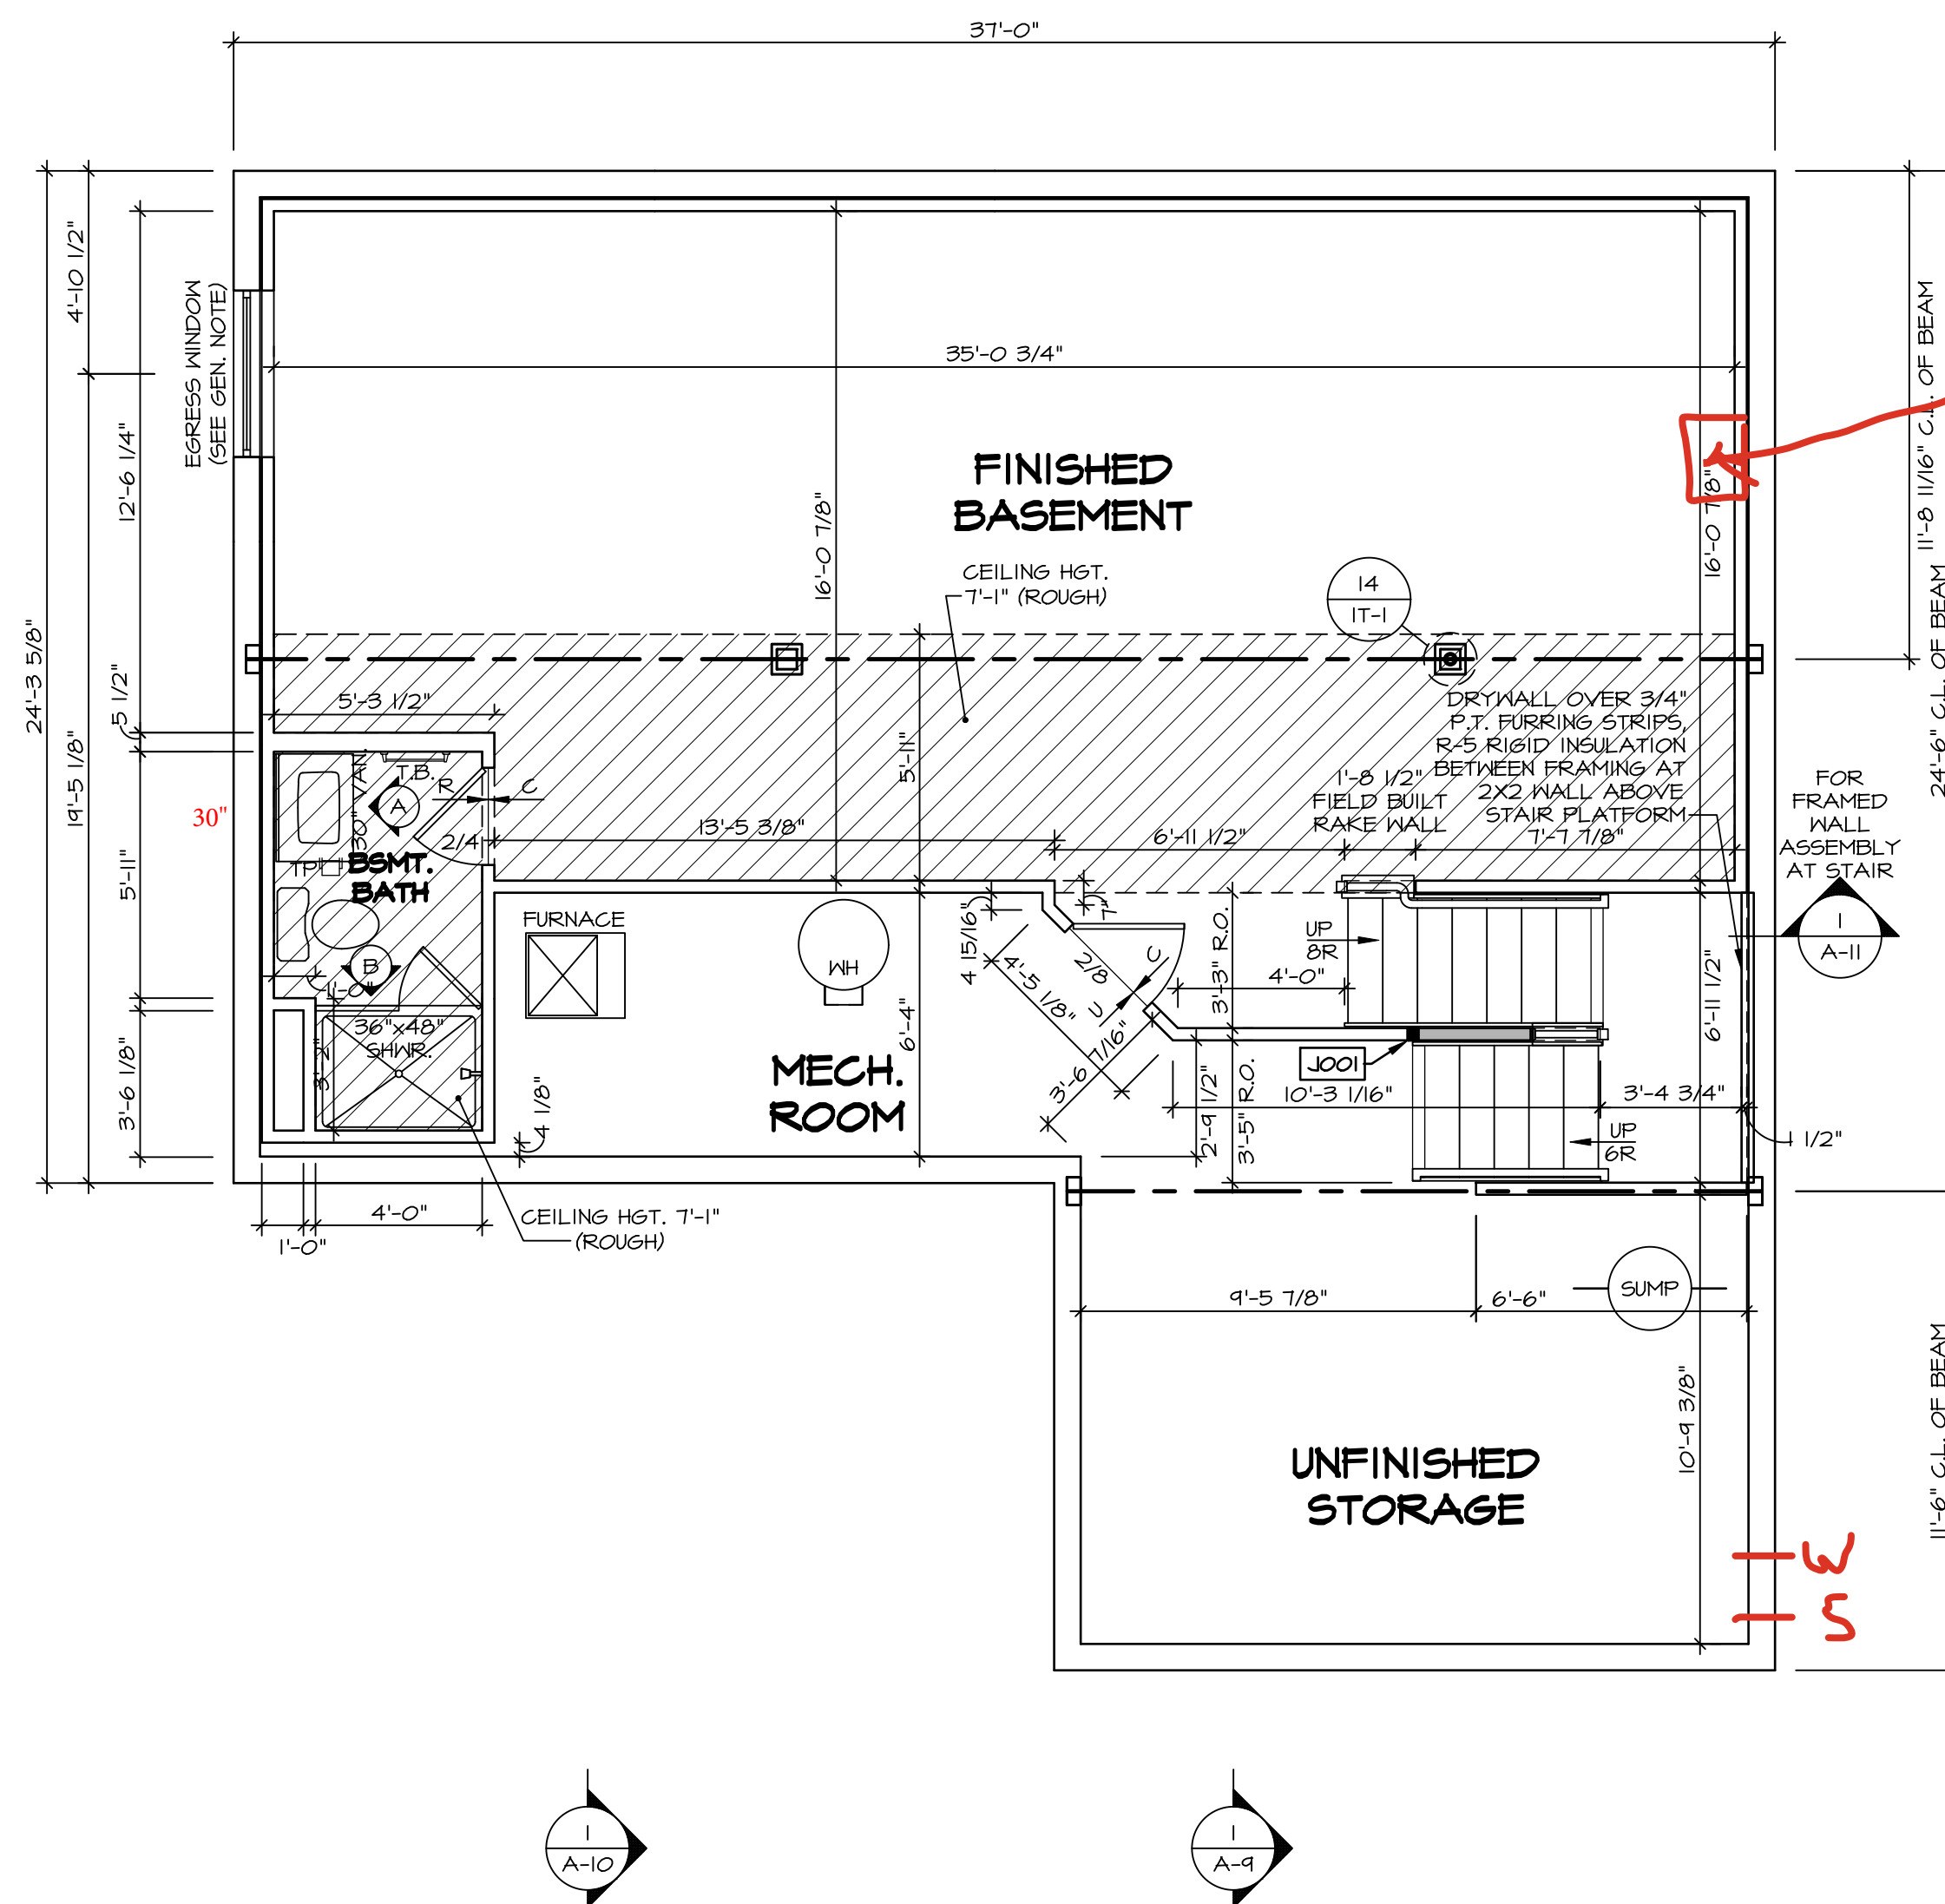

BASEMENT FLOOR PLAN

SHEET NO.	MODEL	SET NO. CLMOO
A-6	DRAWING TITLE	VERSION 01
	BASEMENT FLOOR PLAN	RELEASE NO. ----
		DRAWN BY CVB
		DATE:
	OPTION DESCRIPTION	OPTION
	BASEMENT FOUNDATION	FBA
13		

© NVR, Inc., expressly reserves its copyright and other property rights in these plans. These plans are not to be reproduced, changed, or copied in any form or manner whatsoever, nor are they to be assigned to any third party, without first obtaining the expressed written consent of NVR, Inc.

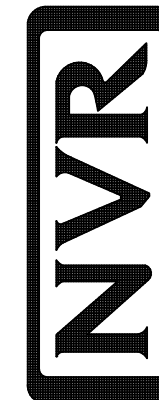

NVR, Inc.
5285 Westview Drive, Suite 100
Frederick MD 21703

LOT-UNIT
DCY-VG-0782

WINDING CREEK WARR CO - 0782

ADDRESS	A

WILL CREEK CI	STATE	ZIP
---------------	-------	-----

C:\NVR\Solves\COLUMBIA_CLM00_01\DCY-VG-0782\3336965\Sheets\Lot Specific\A-6 BSMT_LS.dwg 04/09/25 - 10:08 am

ALL WINDOWS HAVE 1'-0 1/2" HEADER HEIGHT UNLESS OTHERWISE NOTED

NOTE:
EXTERIOR WALLS DRAWN TO FRAMING WIDTH, EXTERIOR SHEATHING IS NOT INCLUDED IN WALL THICKNESS.

GYPSUM NOTES:

AT GARAGE:

GYPSUM BOARD AT COMMON WALLS, CEILINGS, BEAM WRAPS AND SUPPORTS PER STANDARD DETAIL FA-10(b) FIRE ASSEMBLIES OR AS REQUIRED BY LOCAL CODE.

AT STAIRS:

1/2" GYPSUM BOARD AT UNDERSIDE OF STAIRS AND WALLS IN CLOSET

LEGEND

- BEARING WALL
- NON BEARING WALL
- MASONRY WALL
- INDICATES BEARING FROM POINT-LOAD ABOVE
- JACKS
- BEAM/HEADER
- FOOTINGS/THICKENED SLAB
- STEEL COLUMN
- TRUSS TIE DOWN
- PORTAL FRAME
- JOIST/TRUSS
- LVL
- ENGINEERING PAGE NUMBER
- WINDOW/DOOR TAG
- PRECAST LINTEL TAG
- SEE FA DETAILS FOR FIRE ASSEMBLIES
- SEE FC DETAILS FOR FRAMING CONNECTORS AND MATERIAL USAGE

FLOOR PLAN NOTES:

- ALL HEADERS ARE (2) 2x6 w/ 2x4 WALLS OR (3) 2x6 w/ 2x6 WALLS, UNLESS OTHERWISE NOTED.
- ALL HEADERS TO HAVE (1) 2x4 OR 2x6 JACK AND KING STUD EACH END, UNLESS OTHERWISE NOTED.
- ALL EXTERIOR WALLS TO BE 4" OR 6" AND ALL INTERIOR WALLS TO BE 3 1/2", UNLESS OTHERWISE NOTED.
- HATCHED AREAS INDICATE DROPPED CEILINGS. ALL DROPPED CEILINGS ARE 12" UNLESS OTHERWISE NOTED. SEE ARCHITECTURAL DETAIL 8/11-B FOR 3/4" FIRE STOPPING AT BULKHEAD / CEILING PANELS.
- SEE "BRACED WALL PANEL DETAIL SHEET" FOR SPECIAL WALL FRAMING LOCATIONS AND HEADER SIZES, IF APPLICABLE.
- SEE STANDARD DETAIL CATEGORY "IT" SHEET(S) FOR INTERIOR TRIM DETAILS.
- SEE DETAIL SHEET "AD" FOR HOUSE SPECIFIC INTERIOR TRIM OPTION TABLE.
- ALL HEADERS IN NON-BEARING WALLS SHALL BE A SINGLE FLAT 2x4 OR 2x6 ATTACHED TO CRIPPLES ABOVE, UNLESS OTHERWISE NOTED.
- TANKED WATER HEATER SHOWN AS BASE CONDITION, OPTIONAL TANKLESS WATER HEATER IS AVAILABLE IN LIEU OF TANKED WATER HEATER.
- INTERIOR HEADER HEIGHT FOR 8' CEILING WILL BE 6'-11", 9' CEILING WILL BE 7'-11", 10' CEILING WILL BE 8'-3", UNLESS OTHERWISE NOTED.
- BASEMENT FINISH DIMENSIONS ASSUME A 1/2" GAP BETWEEN FRAME WALL AND CONCRETE WALL.
- ALL INTERIOR BEARING WALLS SHALL HAVE GYPSUM APPLIED TO AT LEAST ONE SIDE OR HAVE MID-HEIGHT BLOCKING INSTALLED.
- NON-BEARING WALLS OVER CONCRETE TO BE HELD 1/2" SHORT OF FRAMING ABOVE.

LVL PLY TO PLY FASTENING SCHEDULE: (WHERE APPLICABLE BASED ON LVL USAGE)

- 1.A - (2) PLY UP TO AND INCLUDING 11 7/8" TALL: FASTEN PLYS W/ (2) ROWS 16D NAILS AT 12" O.C. OR ALT 1 1/2" WIDE LVL FASTEN PLYS W/ (3) ROWS 12D NAILS AT 12" O.C.
- 2.A - (2) PLY 14" UP TO AND INCLUDING 18": FASTEN PLYS W/ (3) ROWS 16D NAILS AT 12" O.C. OR ALT 1 1/2" WIDE LVL FASTEN PLYS W/ (4) ROWS 12D NAILS AT 12" O.C.
- 3.A - (2) PLY 20" TALL AND OVER: FASTEN PLYS W/ (4) ROWS 16D NAILS AT 12" O.C. OR ALT 1 1/2" WIDE LVL FASTEN PLYS W/ (5) ROWS 12D NAILS AT 12" O.C.
- 4.A - (3) PLY UP TO AND INCLUDING 11 7/8" TALL: FASTEN PLYS W/ (2) ROWS 16D NAILS AT 12" O.C. FROM EACH SIDE OR ALT 1 1/2" WIDE LVL FASTEN PLYS W/ (3) ROWS 12D NAILS AT 12" O.C. FROM EACH SIDE.
- 5.A - (3) PLY 14" UP TO AND INCLUDING 18": FASTEN PLYS W/ (3) ROWS 16D NAILS AT 12" O.C. FROM EACH SIDE OR ALT 1 1/2" WIDE LVL FASTEN PLYS W/ (4) ROWS 12D NAILS AT 12" O.C. FROM EACH SIDE.
- 6.A - (3) PLY 20" TALL AND OVER: FASTEN PLYS W/ (4) ROWS 16D NAILS AT 12" O.C. FROM EACH SIDE OR ALT 1 1/2" WIDE LVL FASTEN PLYS W/ (5) ROWS 12D NAILS AT 12" O.C. FROM EACH SIDE.
- 7.A - (4) PLY (ALL SIZES): FASTEN PLYS WITH (3) ROWS OF SDW22634 STRUCTURAL WOOD SCREWS, OR EQUIVALENT, AT 16" O.C. STAGGERED. SEE SHOP DRAWING FOR ADDITIONAL INFORMATION.

FIELD INSTALLED FIRST FLOOR BEAM/HEADER SCHEDULE


IDENTIFIER	DESCRIPTION	LENGTH	OPTIONS	ENG. NUM.	REMARKS
B101	BEAM STEEL - W12X30 W 2X6 SILL	23'-10 3/4"		1023	
PF101-2	LVL 1.75 - 11-04	20'-1"	6CB/ 6CF	1035	

STEEL COLUMN SCHEDULE

IDENTIFIER	STYLE	HEIGHT	OPTIONS	ENG. NUM.	REMARKS
C101	STANCHION - 3 IN SCHED 40	4'-6"	6CB/ 6CF, ELA/ ELB/ ELK/ ELL, 5XC, FBA/ FCA, SZL	1006	
C105	STANCHION PORCH - 3 IN DIA 11GA ADJ	4'-4 1/8"	FBA	1063	

FIRST FLOOR JACK SCHEDULE

IDENTIFIER	DESCRIPTION	OPTIONS	ENG. NUM.	REMARKS
J103	JACK - (4) 2X4 SPF STUD GRADE	5XC, ELA/ ELK, SZL	1006	
J108	JACK - (4) 2X4 SPF STUD GRADE		1014	
J109	JACK - (4) 2X6 SPF STUD GRADE		1016	
J110	JACK - (4) 2X4 SPF STUD GRADE		1016	
J111	JACK - (2) 2X4 SPF STUD GRADE		1018	
J112	JACK - (2) 2X4 SPF STUD GRADE		1020	
J117	JACK - (5) 2X4 SPH		1023	
J118	JACK - (3) 2X4 SPF STUD GRADE		1027	
J119	JACK - (3) 2X4 SPF STUD GRADE	ELA/ ELK/ ELK	1031	
J120	JACK - (2) 2X4 SPF STUD GRADE	ELA/ ELK/ ELK	1031	
J121	JACK - (2) 2X4 SPF STUD GRADE	6CB/ 6CF	1035	
J122	JACK - (2) 2X4 SPF STUD GRADE	6CB/ 6CF	1035	
J131	JACK - (2) 2X4 SPF STUD GRADE		1053	
J132	JACK - (2) 2X4 SPF STUD GRADE		1055	
J133	JACK - (2) 2X4 SPF STUD GRADE		1055	
J135	JACK - (2) 2X4 SPF STUD GRADE		1063	
J144	JACK - (2) 2X4 SPF STUD GRADE		1018	
J145	JACK - (3) 2X4 SPF STUD GRADE		1027	
J147	JACK - (5) 2X4 SPH		1023	

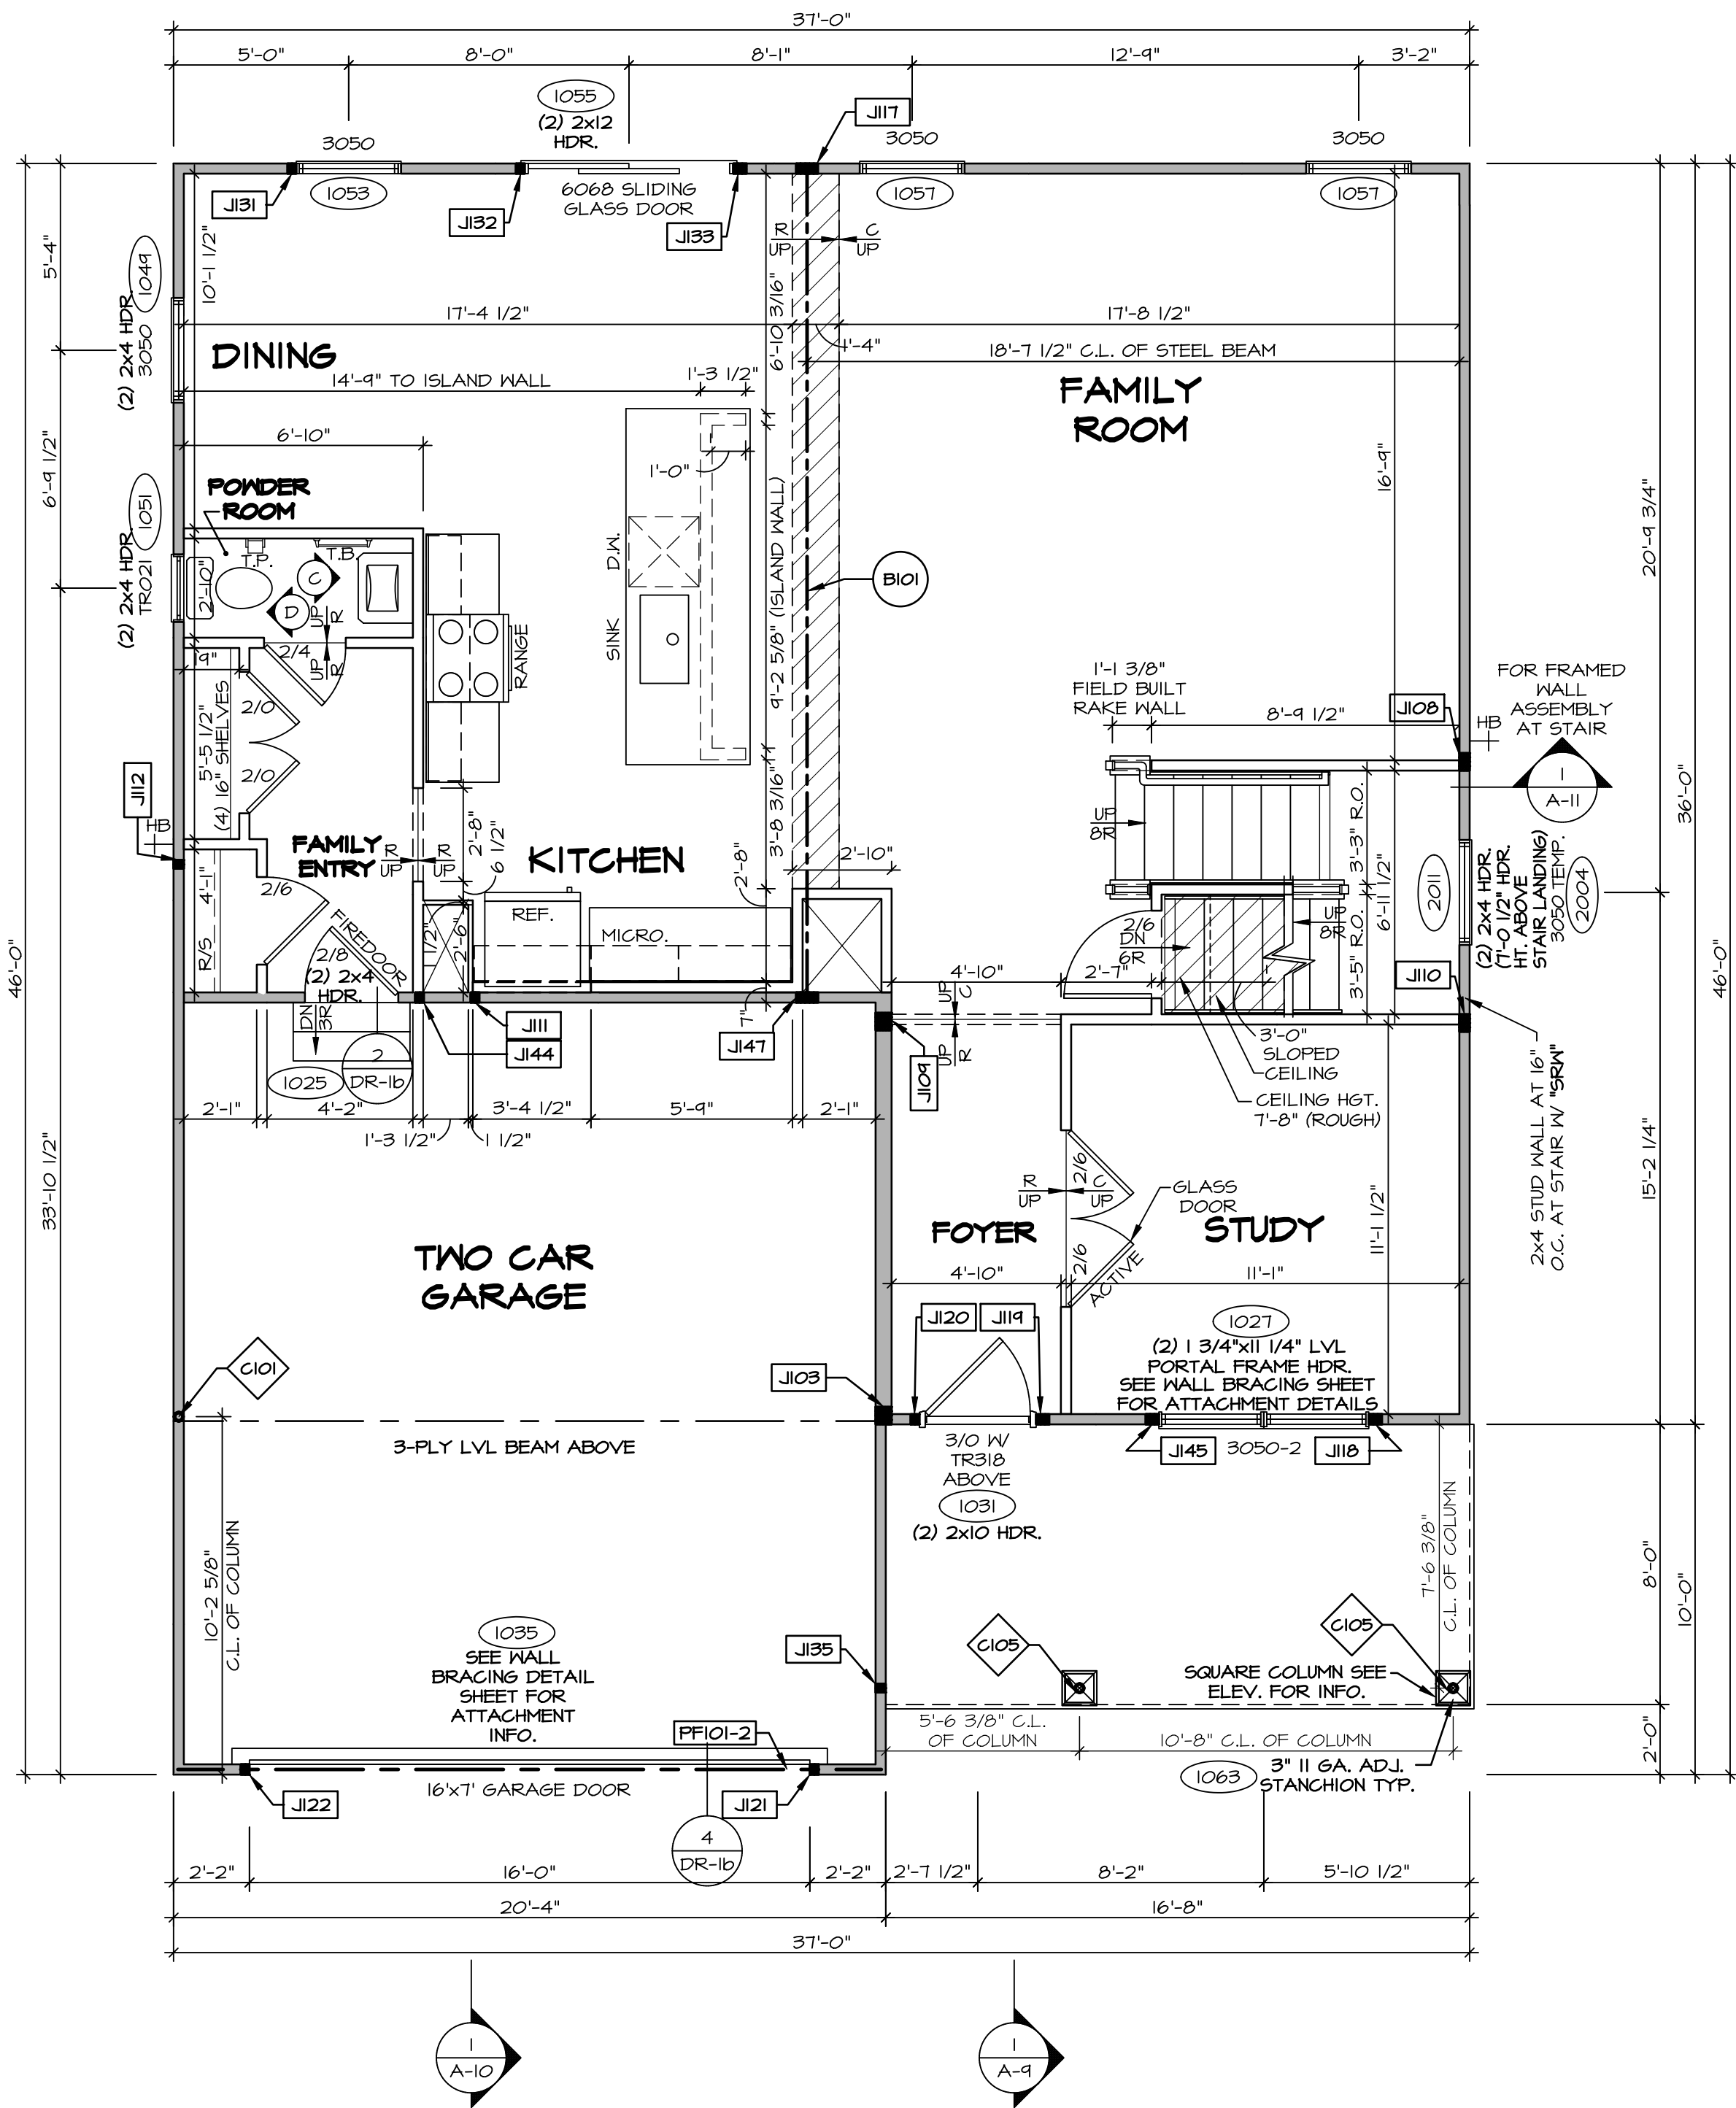

FIRST FLOOR PLAN
SCALE: 1/4" = 1'-0"

DCY-VG-0782

DIV-COMM-LOT-UNIT

COM-LOT

STREET ADDRESS

CITY

STATE

ZIP

APT. NO.

45458

OH

45458

45458


45458

45458

45458

45458

45458

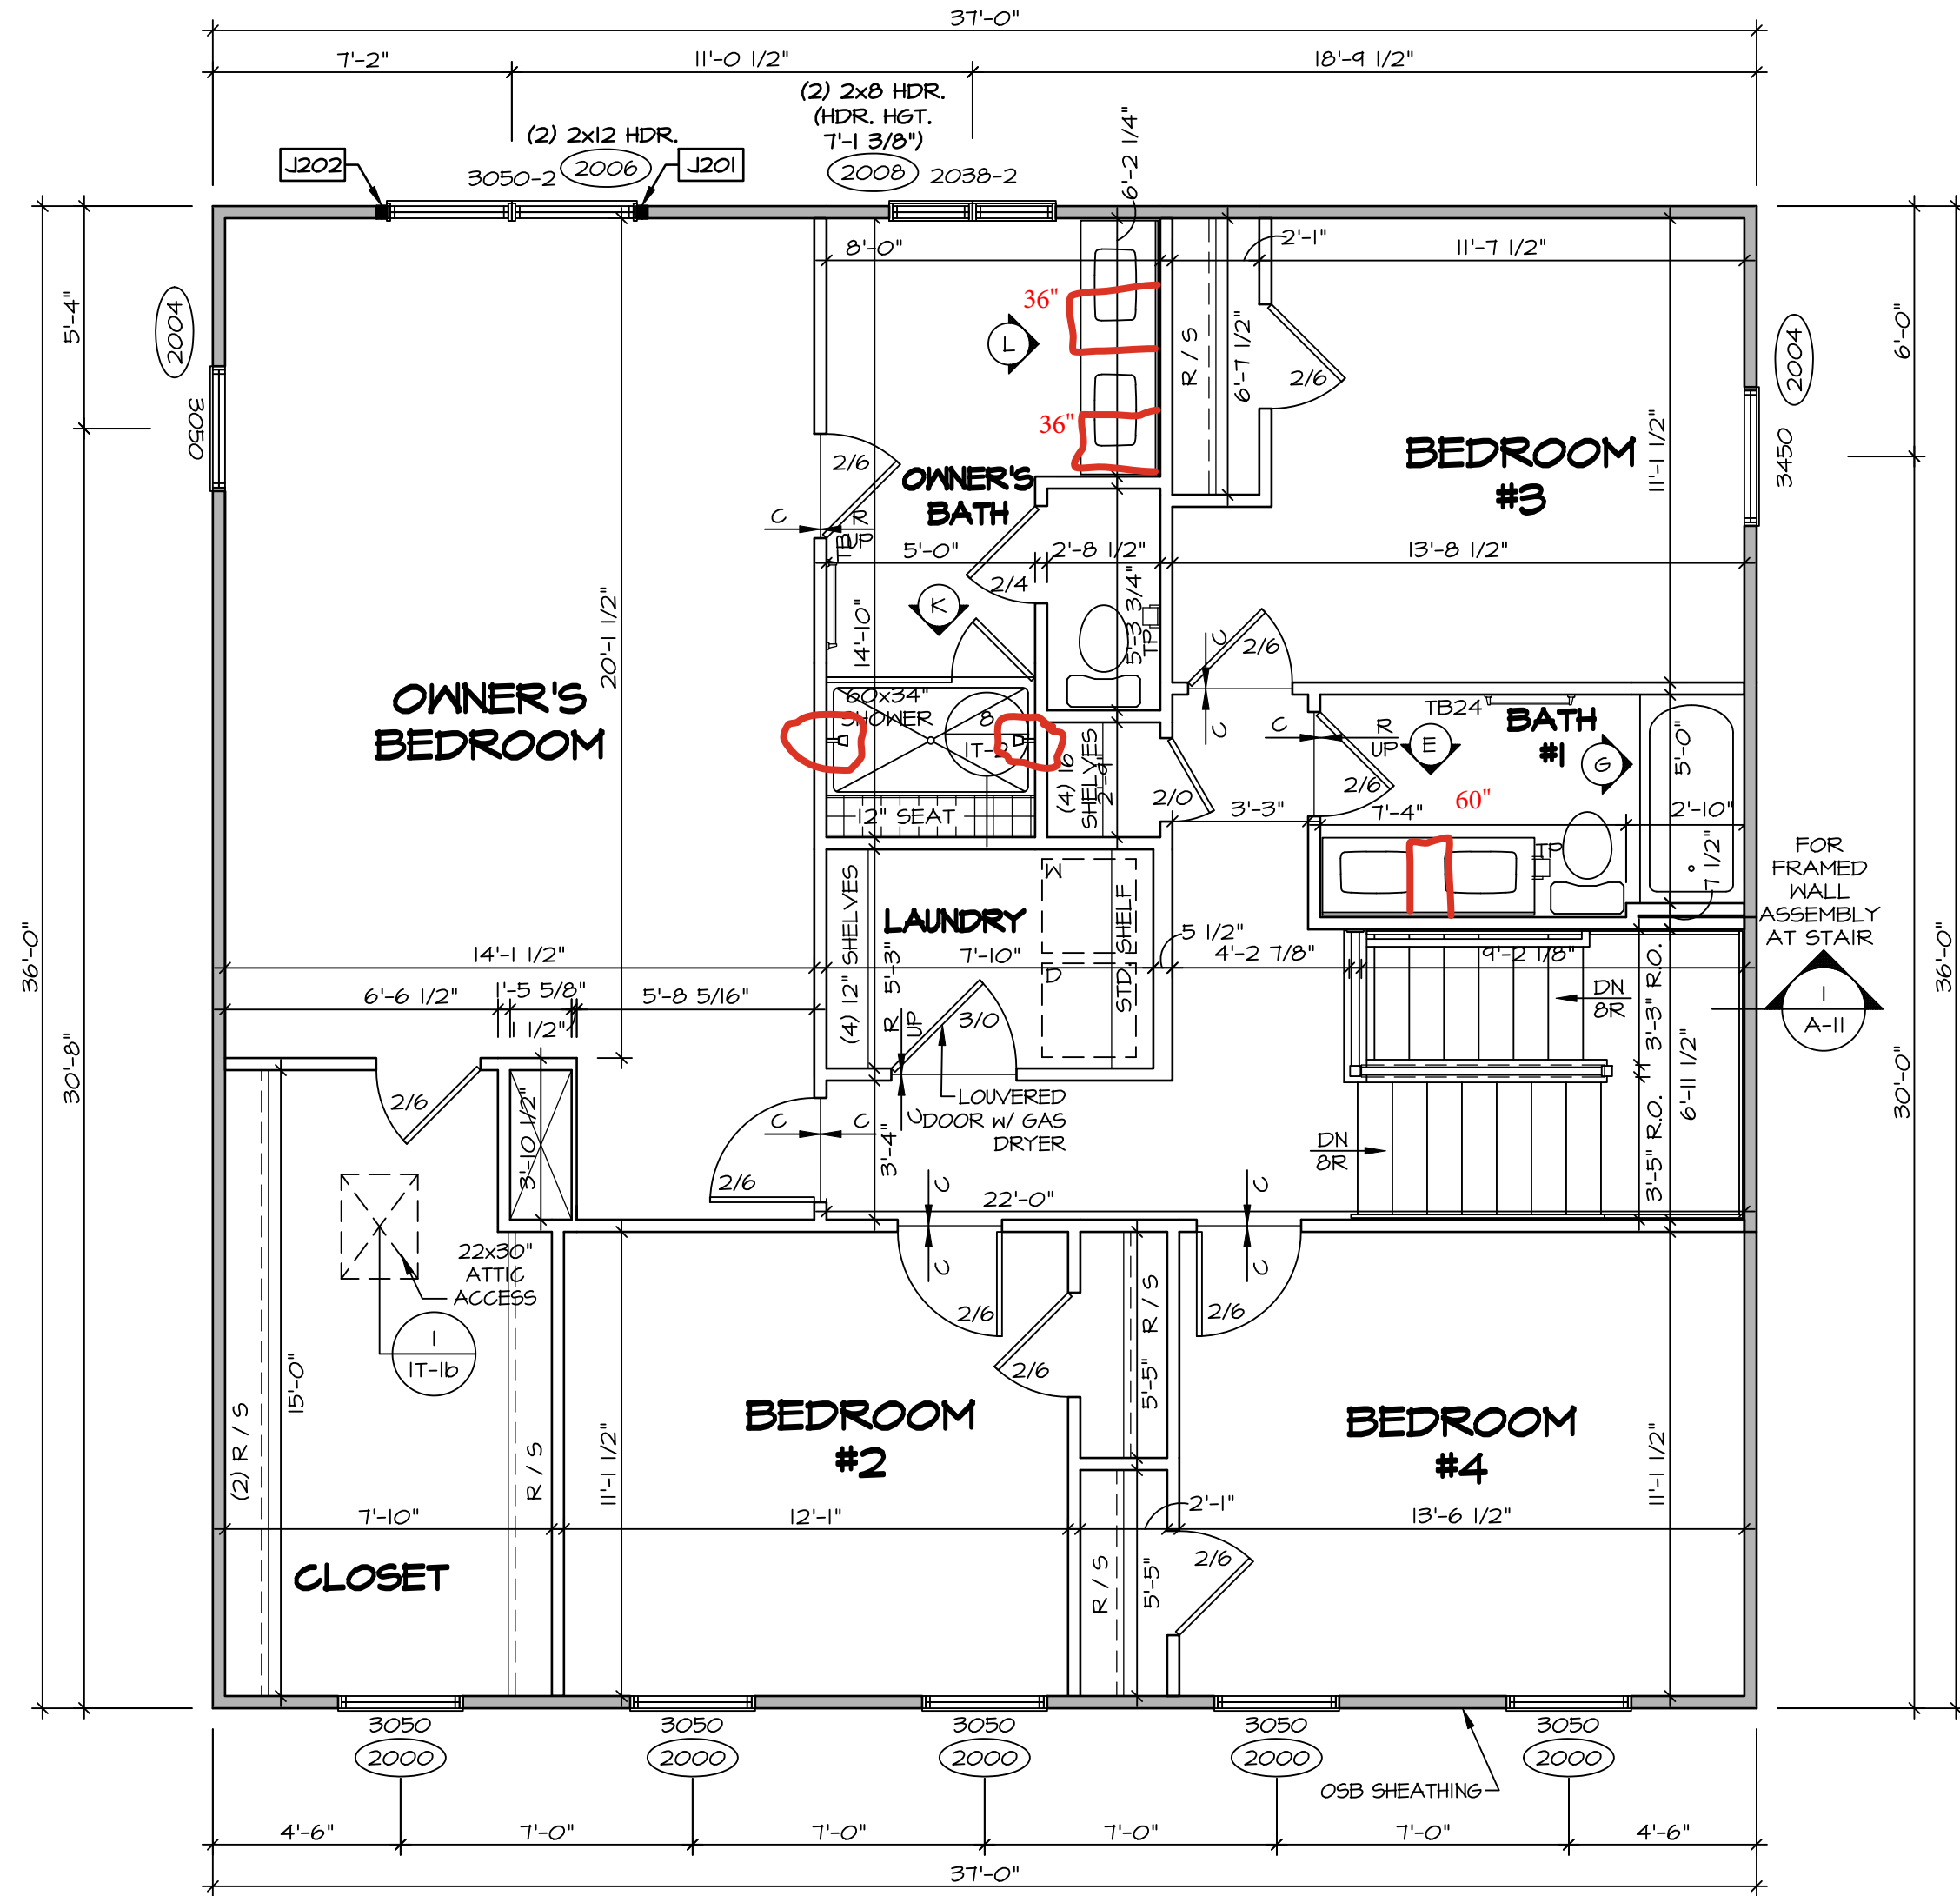

SECOND FLOOR PLAN
SCALE: 1/4" = 1'-0"

ALL WINDOWS HAVE 1'-0 1/2" HEADER
HEIGHT UNLESS OTHERWISE NOTED

NOTE:
EXTERIOR WALLS DRAWN TO FRAMING
WIDTH, EXTERIOR SHEATHING IS NOT
INCLUDED IN WALL THICKNESS.

LEGEND

- BEARING WALL
- NON BEARING WALL
- MASONRY WALL
- INDICATES BEARING FROM
POINT-LOAD ABOVE
- JACKS
- BEAM/HEADER
- FOOTING/THICKENED SLAB
- STEEL COLUMN
- TRUSS TIE DOWN
- PORTAL FRAME
- JOIST/TRUSS
- LVL
- ENGINEERING PAGE NUMBER
- WINDOW/DOOR TAG
- PRECAST LINTEL TAG
- SEE FA DETAILS FOR FIRE
ASSEMBLIES
- SEE FC DETAILS FOR FRAMING
CONNECTORS AND MATERIAL USAGE

FLOOR PLAN NOTES:

- ALL HEADERS ARE (2) 2x6 w/ 2x4 WALLS OR (3) 2x6 w/ 2x6 WALLS, UNLESS OTHERWISE NOTED.
- ALL HEADERS TO HAVE (1) 2x4 OR 2x6 JACK AND KING STUD EACH END, UNLESS OTHERWISE NOTED.
- MULTI-OPENING HEADERS TO HAVE (2) JACKS AT INTERMEDIATE BEARINGS, UNLESS OTHERWISE NOTED. NO ADDITIONAL FLOOR SYSTEM BLOCKING OR CONTINUOUS LOAD PATH JACKS ARE REQUIRED UNLESS OTHERWISE NOTED.
- ALL EXTERIOR WALLS TO BE 4" OR 6" AND ALL INTERIOR WALLS TO BE 3 1/2", UNLESS OTHERWISE NOTED.
- HATCHED AREAS INDICATE DROPPED CEILINGS. ALL DROPPED CEILINGS ARE 12" UNLESS OTHERWISE NOTED. SEE ARCHITECTURAL DETAIL 8/IT-1B FOR 3/4" FIRE STOPPING AT BULKHEAD / CEILING PANELS.
- SEE "BRACED WALL PANEL DETAIL SHEET" FOR SPECIAL WALL FRAMING LOCATIONS AND HEADER SIZES, IF APPLICABLE.
- SEE STANDARD DETAIL CATEGORY "IT" SHEET(S) FOR INTERIOR TRIM DETAILS.
- SEE DETAIL SHEET "AD" FOR HOUSE SPECIFIC INTERIOR TRIM OPTION TABLE.
- ALL HEADERS IN NON-BEARING WALLS SHALL BE A SINGLE FLAT 2x4 OR 2x6 ATTACHED TO CRIPPLES ABOVE, UNLESS OTHERWISE NOTED.
- TANKED WATER HEATER SHOWN AS BASE CONDITION, OPTIONAL TANKLESS WATER HEATER IS AVAILABLE IN LIEU OF TANKED WATER HEATER.
- INTERIOR HEADER HEIGHT FOR 8' CEILING WILL BE 6'-11", 9' CEILING WILL BE 7'-11", 10' CEILING WILL BE 8'-3", UNLESS OTHERWISE NOTED.
- BASEMENT FINISH DIMENSIONS ASSUME A 1/2" GAP BETWEEN FRAME WALL AND CONCRETE WALL.
- ALL INTERIOR BEARING WALLS SHALL HAVE GYPSUM BLOCKING INSTALLED.
- NON-BEARING WALLS OVER CONCRETE TO BE HELD 1/2" SHORT OF FRAMING ABOVE.

GYPSUM NOTES:

AT GARAGE:

GYPSUM BOARD AT COMMON WALLS, CEILINGS, BEAM WRAPS AND SUPPORTS PER STANDARD DETAIL FA-1(b) FIRE ASSEMBLIES OR AS REQUIRED BY LOCAL CODE.

AT STAIRS:

1/2" GYPSUM BOARD AT UNDERSIDE OF STAIRS AND WALLS IN CLOSET

SECOND FLOOR JACK SCHEDULE

IDENTIFIER	DESCRIPTION	OPTIONS	ENG. NUM.	REMARKS
J201	JACK - (2) 2X4 SPF STUD GRADE		2006	
J202	JACK - (2) 2X4 SPF STUD GRADE		2006	

© NVR, Inc., expressly reserves its copyright and other property rights in these plans. These plans are not to be reproduced, stored in a retrieval system, or transmitted in any form or by any means, electronic, mechanical, photocopying, recording, or otherwise, without the prior written consent of NVR, Inc.

NVR
NVR, Inc., Suite 100
5285 Westwood Drive
Frederick, MD 21703

SET NO. CLM00
VERSION 01
RELEASE NO. ----
DRAWN BY ARM
DATE:
OPTION

MODEL
COLUMBIA
DRAWING TITLE
SECOND FLOOR PLAN
OPTION DESCRIPTION

SHEET NO.
A-8

15

DIV-COMM-LOT-UNIT
DCY-VG-0782

COM-LOT
VLE5 OF WINING CREEK MARR CO - 0782

STREET ADDRESS
4808 KNOLL CREEK CT

CITY
CENTERVILLE

STATE
OH

ZIP
45458

APT. NO.

APR. NO.

ZIP
45458

STATE
OH

CITY
CENTERVILLE

STREET ADDRESS
4808 KNOLL CREEK CT

COM-LOT
VLE5 OF WINING CREEK MARR CO - 0782

DIV-COMM-LOT-UNIT
DCY-VG-0782

SHEET NO.
A-8

OPTION DESCRIPTION

DRAWING TITLE
SECOND FLOOR PLAN

MODEL
COLUMBIA

SET NO. CLM00

VERSION 01

RELEASE NO. ----

DRAWN BY ARM

DATE:

OPTION

APT. NO.

APR. NO.

ZIP
45458

STATE
OH

CITY
CENTERVILLE

STREET ADDRESS
4808 KNOLL CREEK CT

COM-LOT
VLE5 OF WINING CREEK MARR CO - 0782

DIV-COMM-LOT-UNIT
DCY-VG-0782

SHEET NO.
A-8

OPTION DESCRIPTION

DRAWING TITLE
SECOND FLOOR PLAN

MODEL
COLUMBIA

SET NO. CLM00

VERSION 01

RELEASE NO. ----

DRAWN BY ARM

DATE:

OPTION

APT. NO.

APR. NO.

ZIP
45458

STATE
OH

CITY
CENTERVILLE

STREET ADDRESS
4808 KNOLL CREEK CT

COM-LOT
VLE5 OF WINING CREEK MARR CO - 0782

DIV-COMM-LOT-UNIT
DCY-VG-0782

SHEET NO.
A-8

OPTION DESCRIPTION

DRAWING TITLE
SECOND FLOOR PLAN

MODEL
COLUMBIA

SET NO. CLM00

VERSION 01

RELEASE NO. ----

DRAWN BY ARM

DATE:

OPTION

APT. NO.

APR. NO.

ZIP
45458

STATE
OH

CITY
CENTERVILLE

STREET ADDRESS
4808 KNOLL CREEK CT

COM-LOT
VLE5 OF WINING CREEK MARR CO - 0782

DIV-COMM-LOT-UNIT
DCY-VG-0782

SHEET NO.
A-8

OPTION DESCRIPTION

DRAWING TITLE
SECOND FLOOR PLAN

MODEL
COLUMBIA

SET NO. CLM00

VERSION 01

RELEASE NO. ----

DRAWN BY ARM

DATE:

OPTION

APT. NO.

APR. NO.

ZIP
45458

STATE
OH

CITY
CENTERVILLE

STREET ADDRESS
4808 KNOLL CREEK CT

COM-LOT
VLE5 OF WINING CREEK MARR CO - 0782

DIV-COMM-LOT-UNIT
DCY-VG-0782

SHEET NO.
A-8

OPTION DESCRIPTION

DRAWING TITLE
SECOND FLOOR PLAN

MODEL
COLUMBIA

SET NO. CLM00

VERSION 01

RELEASE NO. ----

DRAWN BY ARM

DATE:

OPTION

APT. NO.

APR. NO.

ZIP
45458

STATE
OH

CITY
CENTERVILLE

STREET ADDRESS
4808 KNOLL CREEK CT

COM-LOT
VLE5 OF WINING CREEK MARR CO - 0782

DIV-COMM-LOT-UNIT
DCY-VG-0782

SHEET NO.
A-8

OPTION DESCRIPTION

DRAWING TITLE
SECOND FLOOR PLAN

MODEL
COLUMBIA

SET NO. CLM00

VERSION 01

RELEASE NO. ----

DRAWN BY ARM

DATE:

OPTION

APT. NO.

APR. NO.

ZIP
45458

STATE
OH

CITY
CENTERVILLE

STREET ADDRESS
4808 KNOLL CREEK CT

COM-LOT
VLE5 OF WINING CREEK MARR CO - 0782

DIV-COMM-LOT-UNIT
DCY-VG-0782

SHEET NO.
A-8

OPTION DESCRIPTION

DRAWING TITLE
SECOND FLOOR PLAN

MODEL
COLUMBIA

SET NO. CLM00

VERSION 01

RELEASE NO. ----

DRAWN BY ARM

DATE:

OPTION

APT. NO.

APR. NO.

ZIP
45458

STATE
OH

CITY
CENTERVILLE

STREET ADDRESS
4808 KNOLL CREEK CT

COM-LOT
VLE5 OF WINING CREEK MARR CO - 0782

DIV-COMM-LOT-UNIT
DCY-VG-0782

SHEET NO.
A-8

OPTION DESCRIPTION

DRAWING TITLE
SECOND FLOOR PLAN

MODEL
COLUMBIA

SET NO. CLM00

VERSION 01

RELEASE NO. ----

DRAWN BY ARM

DATE:

OPTION

APT. NO.

APR. NO.

ZIP
45458

STATE
OH

CITY
CENTERVILLE

STREET ADDRESS
4808 KNOLL CREEK CT

COM-LOT
VLE5 OF WINING CREEK MARR CO - 0782

DIV-COMM-LOT-UNIT
DCY-VG-0782

SHEET NO.
A-8

OPTION DESCRIPTION

DRAWING TITLE
SECOND FLOOR PLAN

MODEL
COLUMBIA

SET NO. CLM00

VERSION 01

RELEASE NO. ----

DRAWN BY ARM

DATE:

OPTION

APT. NO.

APR. NO.

ZIP
45458

STATE
OH

CITY
CENTERVILLE

STREET ADDRESS
4808 KNOLL CREEK CT

COM-LOT
VLE5 OF WINING CREEK MARR CO - 0782

DIV-COMM-LOT-UNIT
DCY-VG-0782

SHEET NO.
A-8

OPTION DESCRIPTION

DRAWING TITLE
SECOND FLOOR PLAN

MODEL
COLUMBIA

SET NO. CLM00

VERSION 01

RELEASE NO. ----

DRAWN BY ARM

DATE:

OPTION

APT. NO.

APR. NO.

ZIP
45458

STATE
OH

CITY
CENTERVILLE

STREET ADDRESS
4808 KNOLL CREEK CT

COM-LOT
VLE5 OF WINING CREEK MARR CO - 0782

DIV-COMM-LOT-UNIT
DCY-VG-0782

SHEET NO.
A-8

OPTION DESCRIPTION

DRAWING TITLE
SECOND FLOOR PLAN

MODEL
COLUMBIA

SET NO. CLM00

VERSION 01

RELEASE NO. ----

DRAWN BY ARM

DATE:

OPTION

APT. NO.

APR. NO.

ZIP
45458

STATE
OH

CITY
CENTERVILLE

STREET ADDRESS
4808 KNOLL CREEK CT

COM-LOT
VLE5 OF WINING CREEK MARR CO - 0782

DIV-COMM-LOT-UNIT
DCY-VG-0782

SHEET NO.
A-8

OPTION DESCRIPTION

DRAWING TITLE
SECOND FLOOR PLAN

MODEL
COLUMBIA

SET NO. CLM00

VERSION 01

RELEASE NO. ----

DRAWN BY ARM

DATE:

OPTION

APT. NO.

APR. NO.

ZIP
45458

STATE
OH

CITY
CENTERVILLE

STREET ADDRESS
4808 KNOLL CREEK CT

COM-LOT
VLE5 OF WINING CREEK MARR CO - 0782

DIV-COMM-LOT-UNIT
DCY-VG-0782

SHEET NO.
A-8

OPTION DESCRIPTION

DRAWING TITLE
SECOND FLOOR PLAN

MODEL
COLUMBIA

SET NO. CLM00

VERSION 01

RELEASE NO. ----

DRAWN BY ARM

DATE:

OPTION

APT. NO.

APR. NO.

ZIP
45458

STATE
OH

CITY
CENTERVILLE

STREET ADDRESS
4808 KNOLL CREEK CT

COM-LOT
VLE5 OF WINING CREEK MARR CO - 0782

DIV-COMM-LOT-UNIT
DCY-VG-0782

SHEET NO.
A-8

OPTION DESCRIPTION

DRAWING TITLE
SECOND FLOOR PLAN

MODEL
COLUMBIA

SET NO. CLM00


KITCHEN NOTES:

1. CABINET LAYOUT (S) ARE BASED ON FINISHED DIMENSIONS TO DRYWALL.
2. IF KITCHEN PLANS/ELEVATIONS CALL-OUT STANDARD MOLDINGS, REFER TO STANDARD DETAIL UK1KT-FR FOR REPLACEMENT BASED ON CABINET STYLE.
3. ALL (IF) FILLERS ARE TO BE "TRIM TO FIT" UNLESS OTHERWISE NOTED.
4. CABINET MUST BE SET, SHIMMED, LEVELLED AND FLUME W/ ADJOINING BASE CABINETS.
5. PRE-FINISHED CABINET BULKHEADS AND AT ENDS (WHERE CABINETS MEET DRYWALL) PRE-FINISHED SCRIBE MOLDING SHALL BE USED TO PAD OUT CABINET SIDES AT STILE FOR RETURN FROM THE FACE-MOUNTED CABINET CROWN MOLDING.
6. HARDWARE INSTALL NOTE: KNOBS GO ON OPERABLE DOORS AND DRAWERS FOR ALL CUPBDS AND DOORS GO ON NON-OPER. FRONTS AND DOORS GET (1) KNOB/PULL. NO HARDWARE ON FALSE DRAINER FRONTS. REFER TO STANDARD DETAIL 5/KT-10.




BATH NOTES:


1. TEMPERED GLASS SHOWER ENCLOSURE WITH SWING DOOR OR OPTIONAL SLIDING DOOR BY DIVISION.
2. TUB ACCESS PANELS PROVIDED AS NEEDED, ALL MATERIALS BY DIVISION.
3. REFER TO DETAILS IT- FOR TUB AND SHOWER.
4. ALL VANITIES WITH DRAWERS TO BE SET WITH DRAWERS ON RIGHT HAND SIDE.
5. BATH ELEVATIONS ARE SHOWN PER PLAN.
6. ALL DIMENSIONS SHOWN ON BATH ELEVATIONS ARE ROUGH FRAMING REFERENCES ONLY.

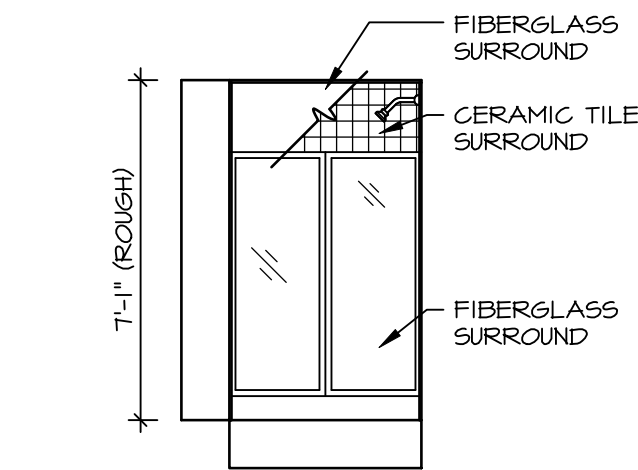


B BASEMENT BATH
SCALE: 1/4" = 1'-0" BASEMENT BATH "AEB"

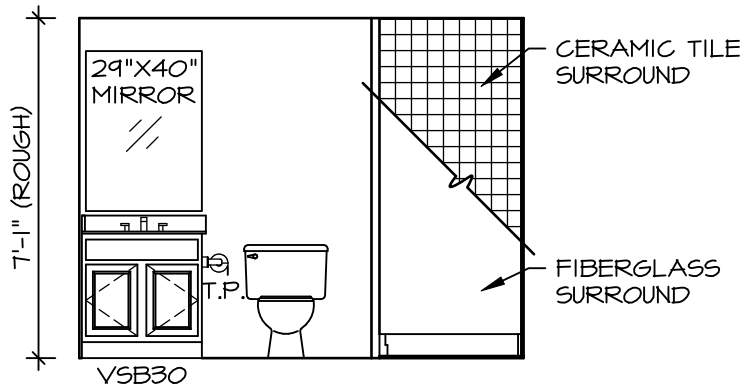


A BASEMENT BATH
SCALE: 1/4" = 1'-0" BASEMENT BATH "AEB"

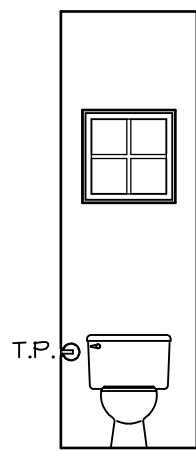


D POWDER ROOM
SCALE: 1/4" = 1'-0"

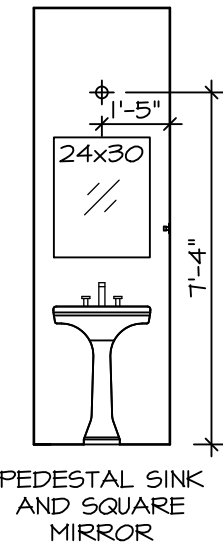


C POWDER ROOM
SCALE: 1/4" = 1'-0"

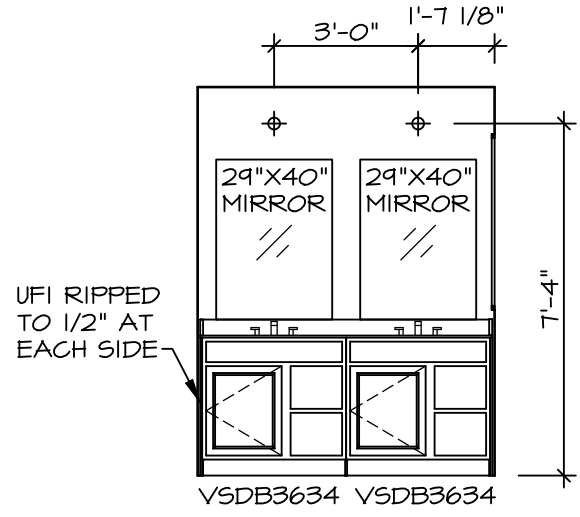


L OWNER'S BATH
SCALE: 1/4" = 1'-0" OWNER'S BATHROOM
W/ ROMAN SHOWER
"AMG"
NEW LIGHT/MIRROR
LAYOUT DEL.
VANITY "AEB"

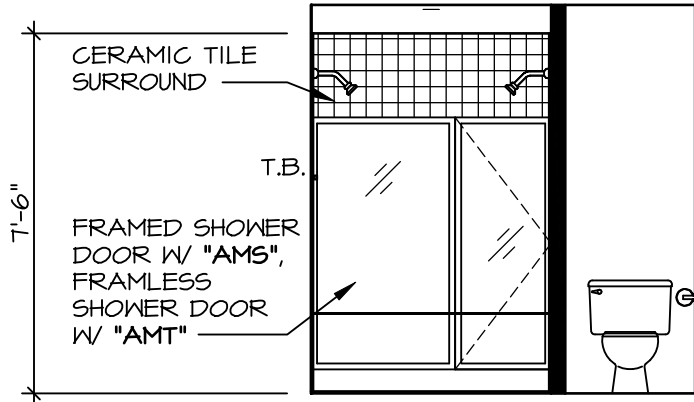

K OWNER'S BATH
SCALE: 1/4" = 1'-0" OWNER'S BATHROOM
W/ ROMAN SHOWER
"AMG"

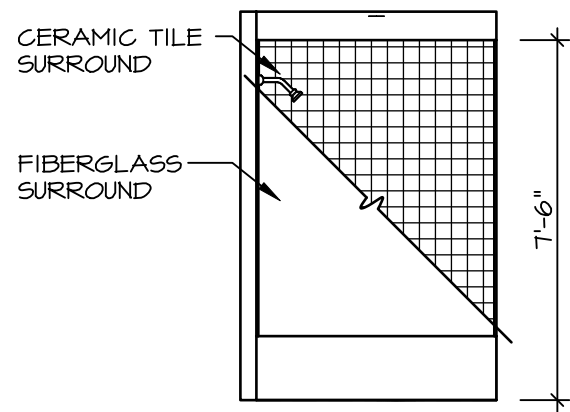


G BATH #1
SCALE: 1/4" = 1'-0"

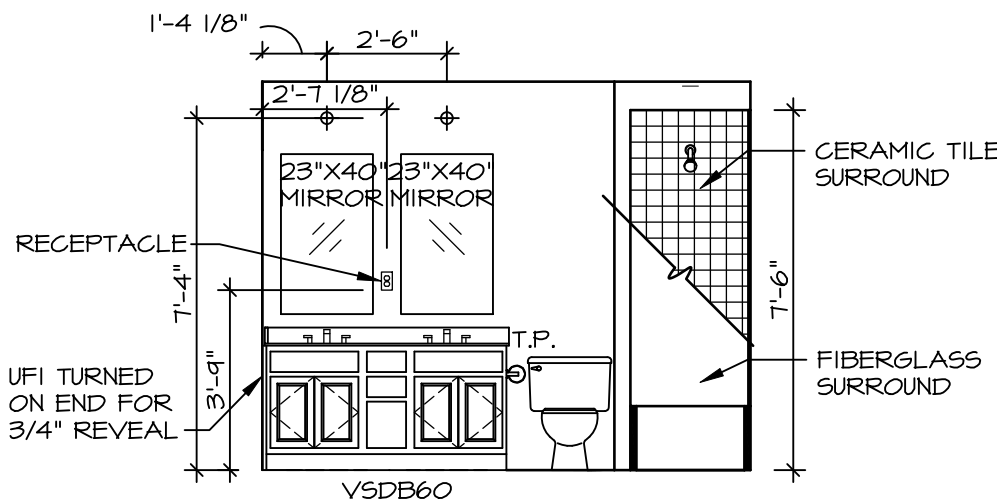

E BATH #1
SCALE: 1/4" = 1'-0"

© NVR, Inc., expressly reserves its copyright and other property rights in these plans. These plans are not to be reproduced, stored in a retrieval system, or transmitted in any form or manner whatsoever, nor are they to be used for any purpose without the written consent of NVR, Inc.

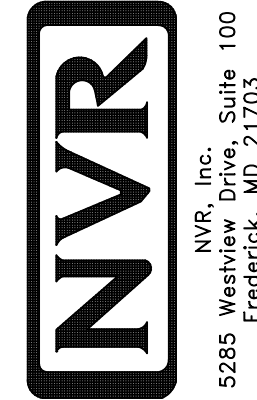

SET NO. CLM00	VERSION 01
RELEASE NO. ----	DRAWN BY ARM
DATE:	OPTION

SHEET NO. **A-13**

20

DIV-COMM-LOT-UNIT
DCY-VG-0782

COM-LOT
V555 OF KINDING CREEK MARR CO - 0782

STREET ADDRESS
4818 KNOLL CREEK CT

CITY
CENTERVILLE

STATE
OH

ZIP
45458